

ARKANSAS STATE HIGHWAY & TRANSPORTATION DEPARTMENT
EQUIPMENT AND PROCUREMENT OFFICE
LITTLE ROCK, ARKANSAS

February 15, 2017

NOTICE TO BIDDERS
ADDENDUM

 
Bid No. M-17-028P

District 3 Headquarters Administration Office Renovations



OPENING DATE: February 22, 2017

Contractors may use the attached plans to estimate flowable fill quantity in ductwork beneath slab.

ALL OTHER SPECIFICATIONS SHALL REMAIN THE SAME.




Danny Keene
Division Head
Equipment and Procurement

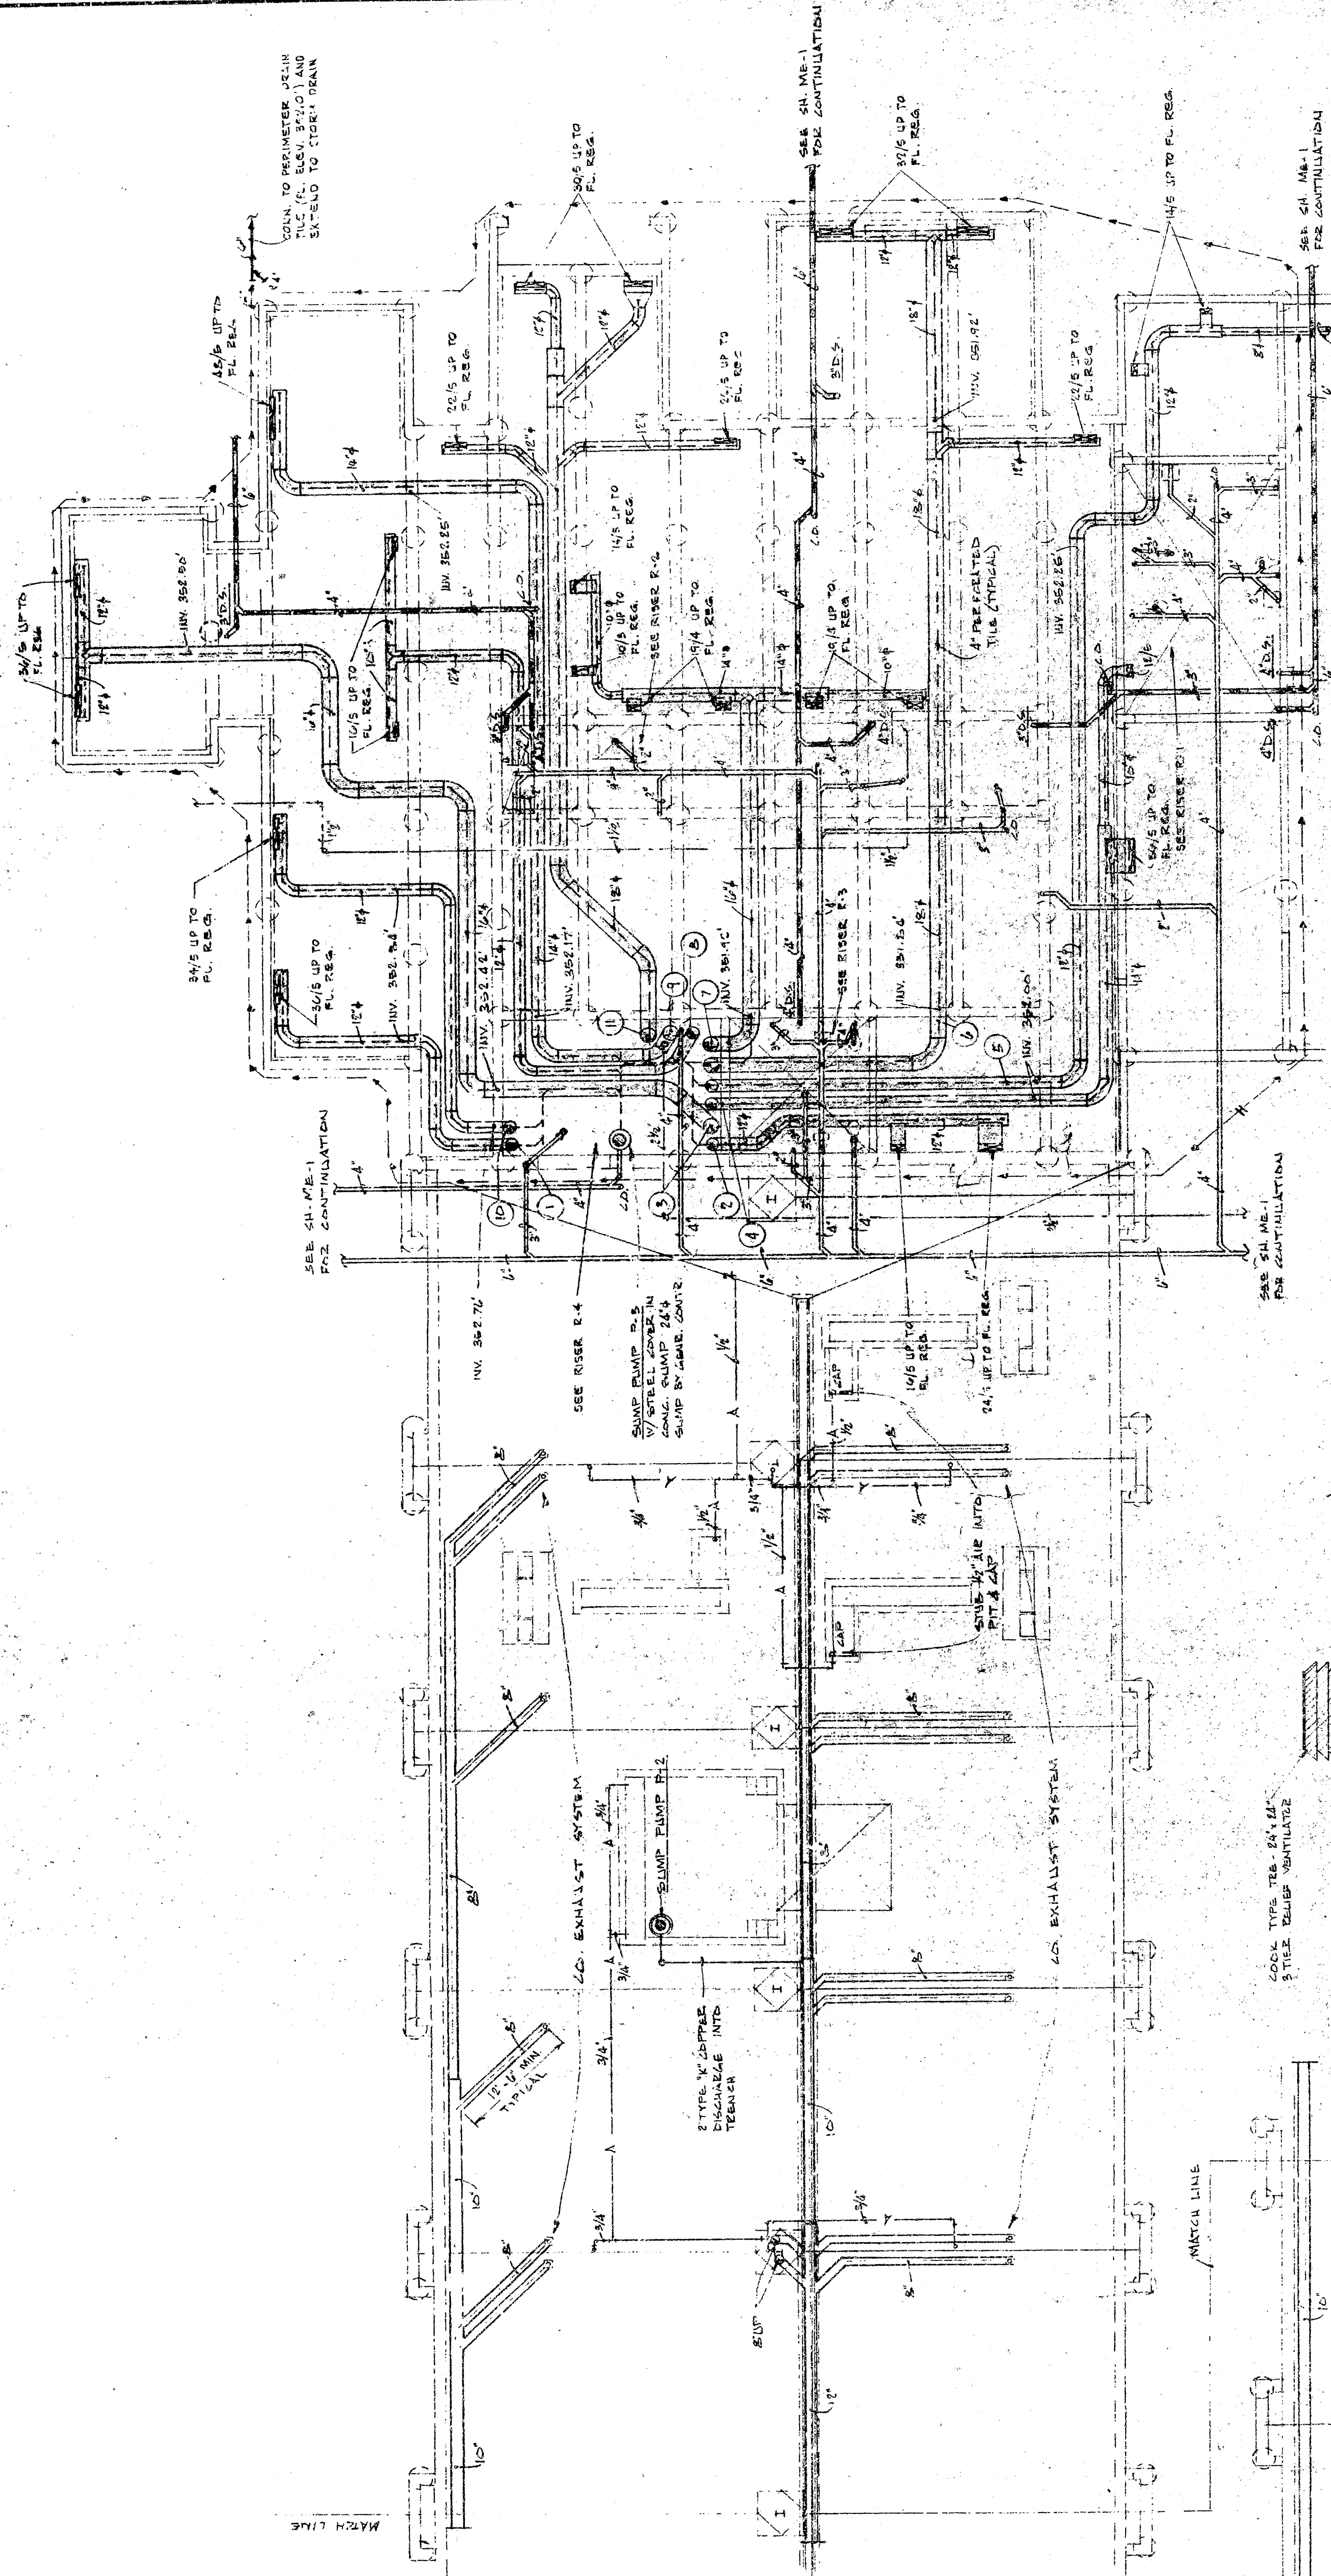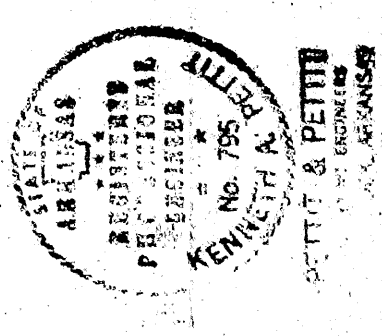


FOUNDATION PLAN SCALE 1/8"=1'-0"
 ADMINISTRATION & MAINTENANCE BUILDING


- NOTES
1. ENLARGED SHEETMETAL DUCT FROM TRANSITE BOARD SHALL BE GALVANIZED STEEL WITH AN INSULATED JOINT.
 2. JOINTS OF TRANSITE DUCT SHALL BE MIN. OF 2" BELOW TOP OF SLAB AT LAST R.F. RES.
 3. REMOVE SCHEDULE NUMBER & DOWNPOUT UNLESS THEY BECOME BEAMS.

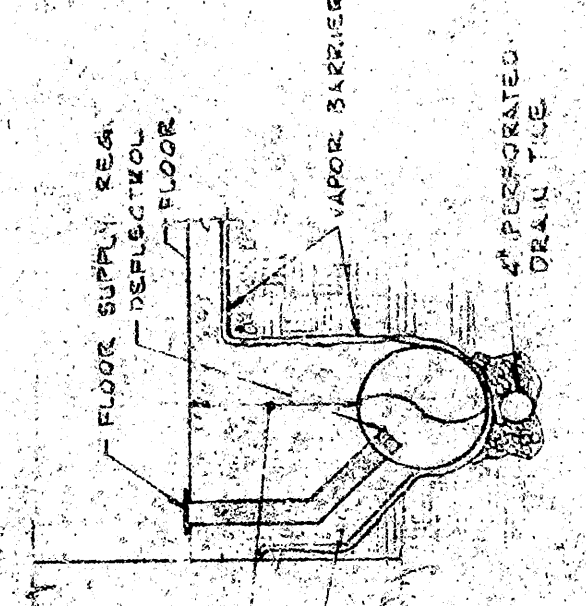














SECTION AT EXTERIOR
 OF UNDERFLOOR DUCTS
 TO SCALE

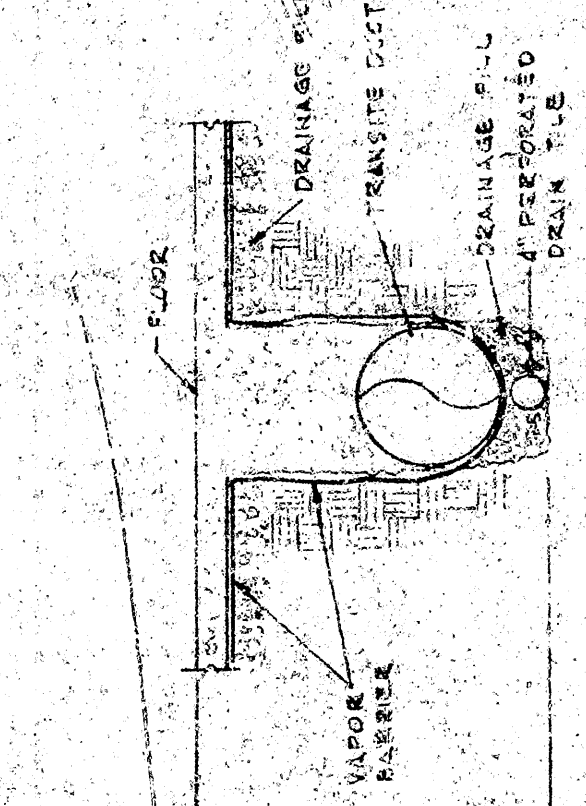

SECTION THRU INTERIOR
 OF UNDERFLOOR DUCTS
 NOT TO SCALE

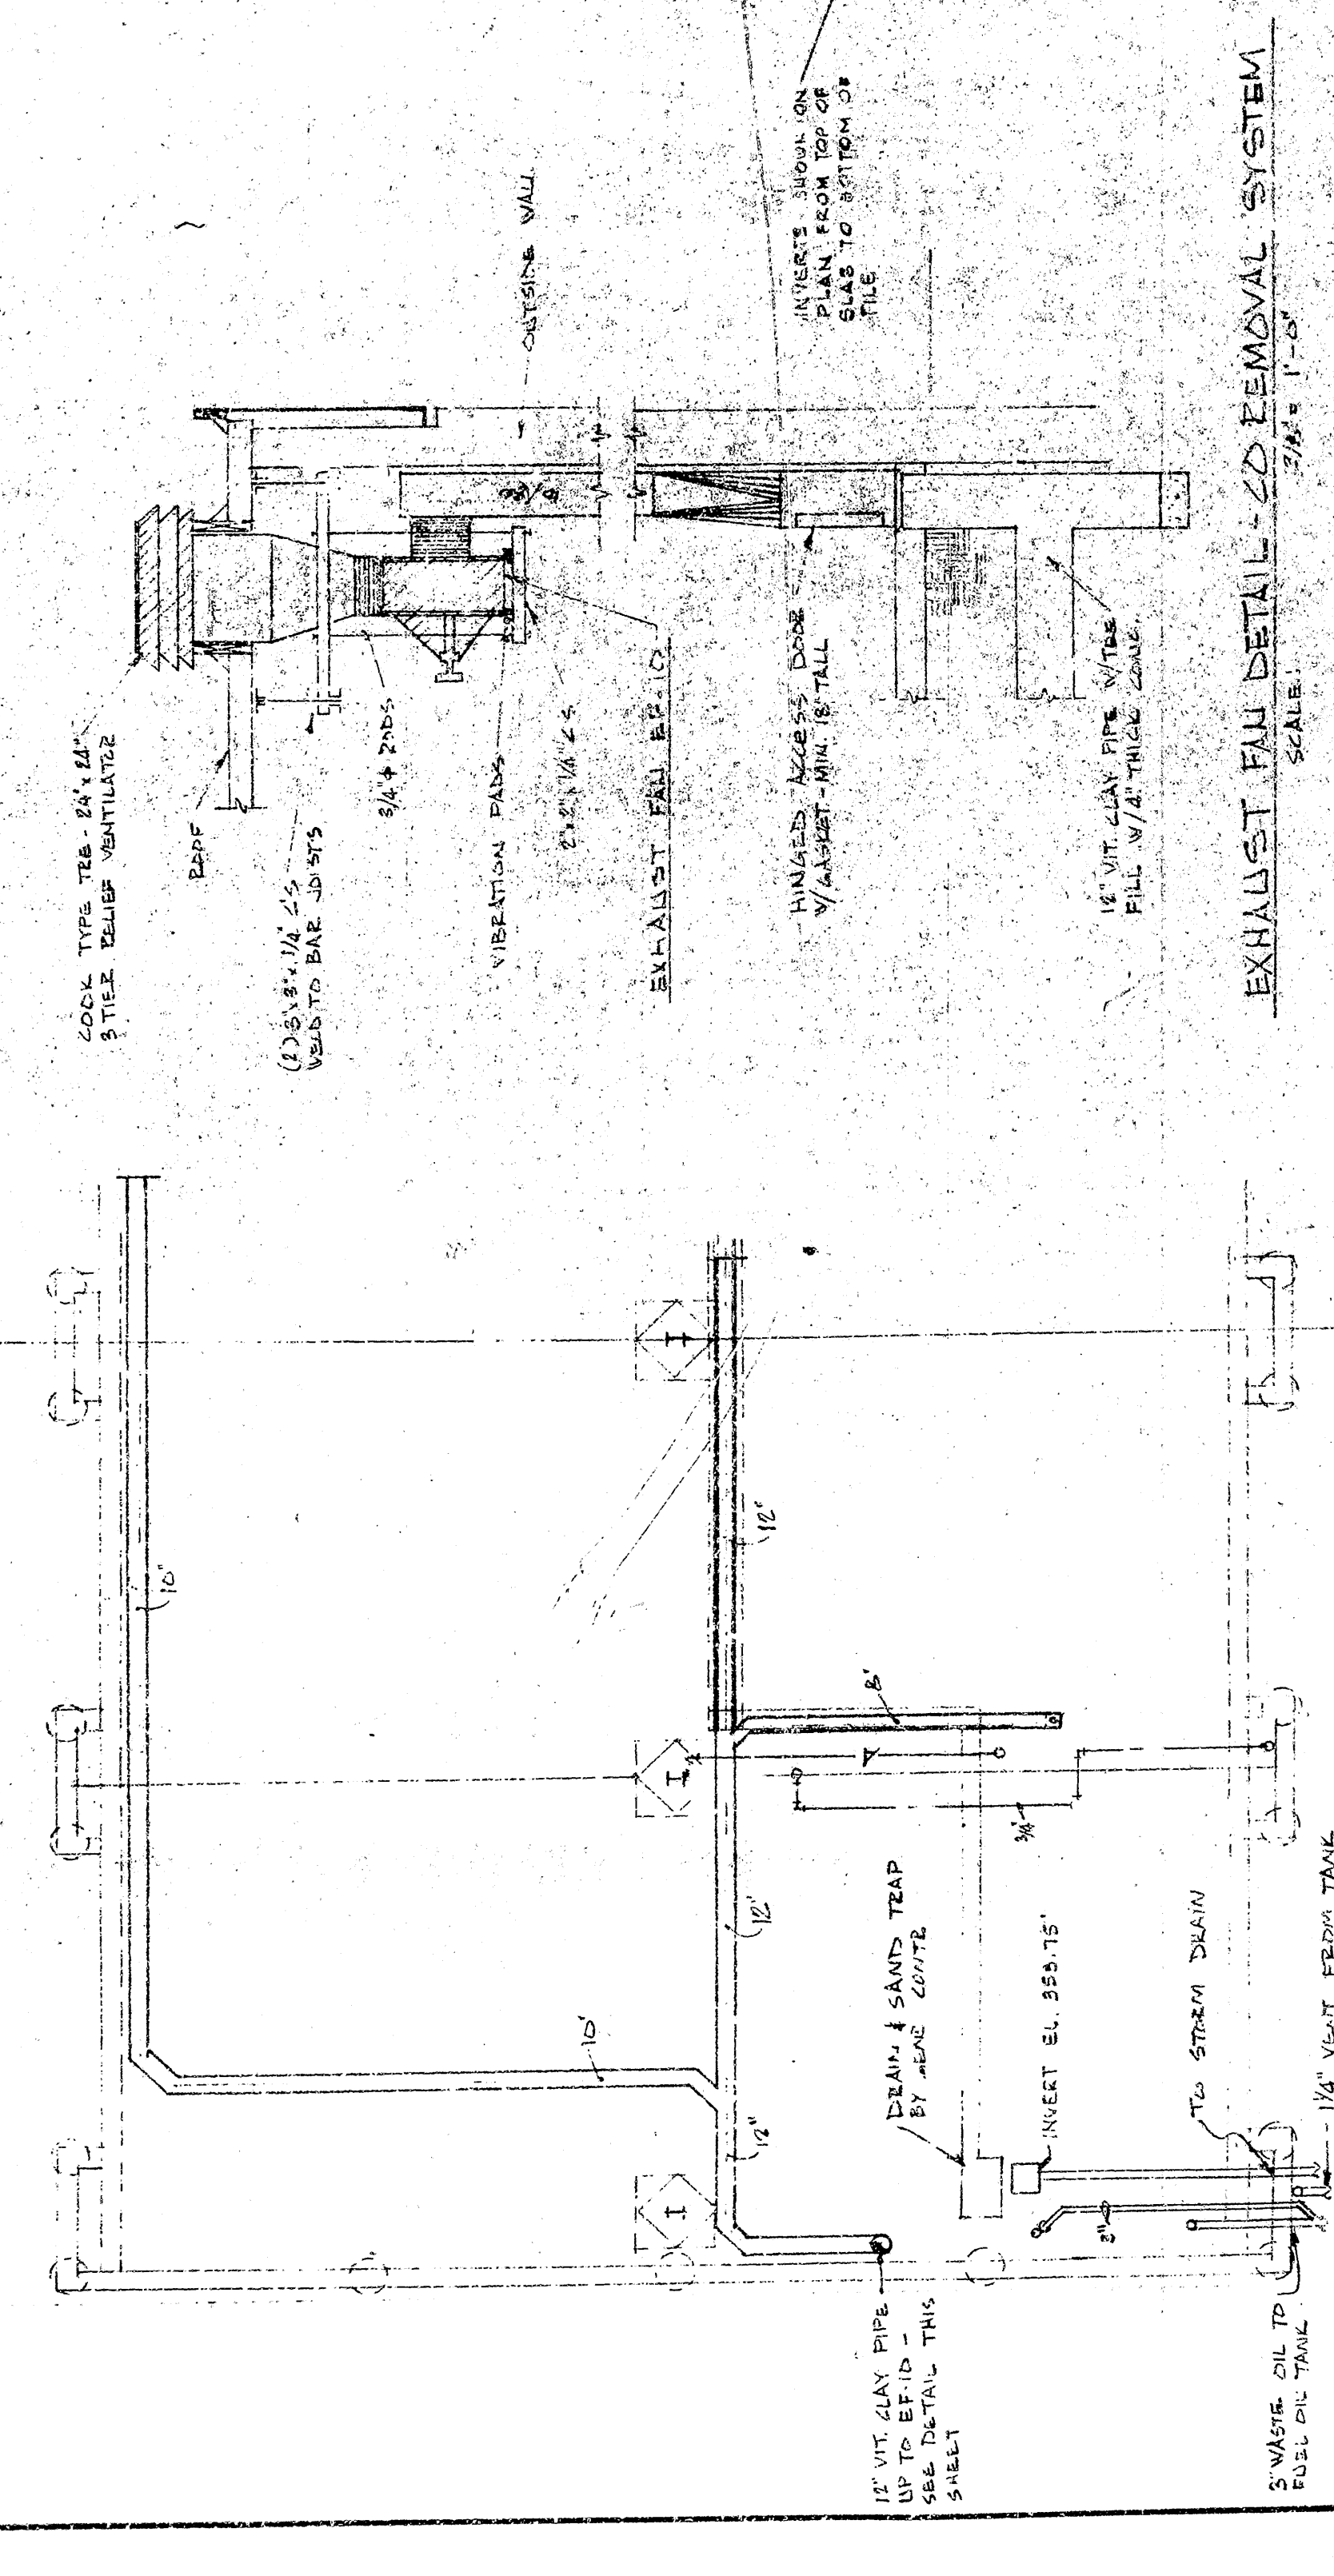

EXHAUST FAN DETAIL - CO REMOVAL SYSTEM
 SCALE 3/4"=1'-0"

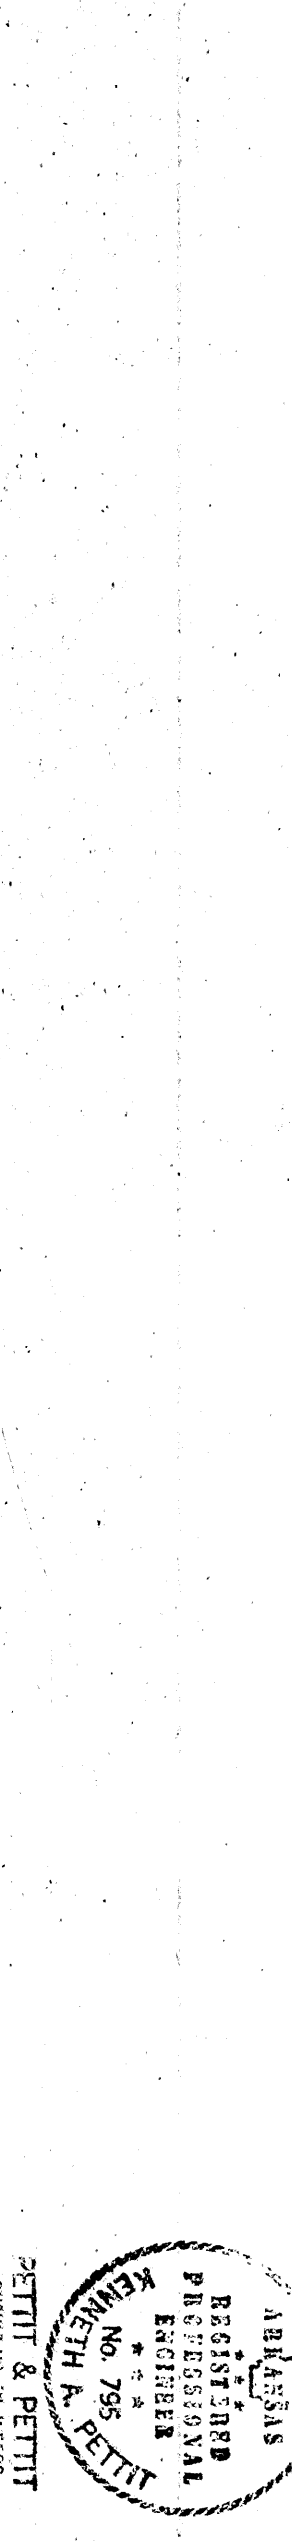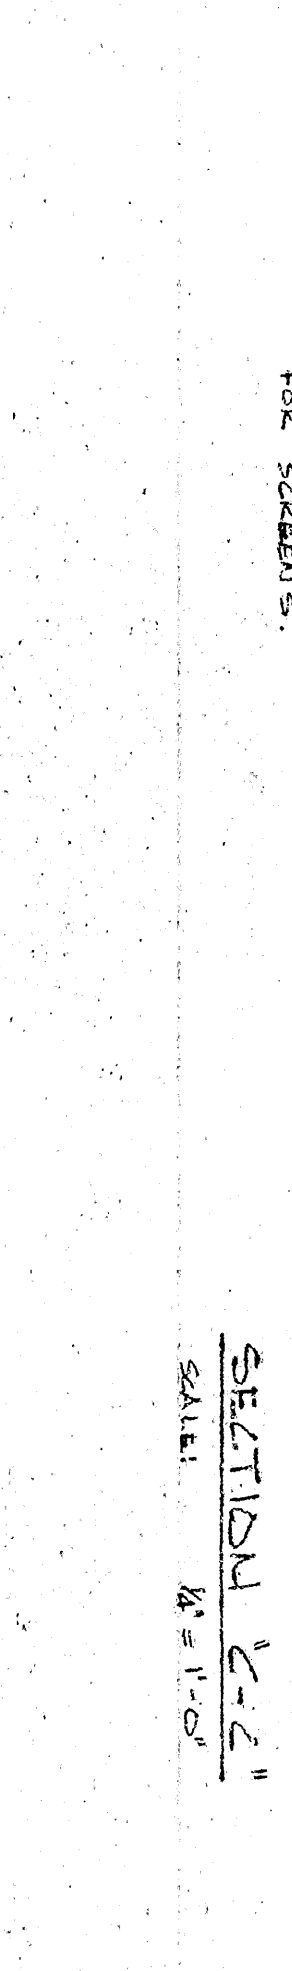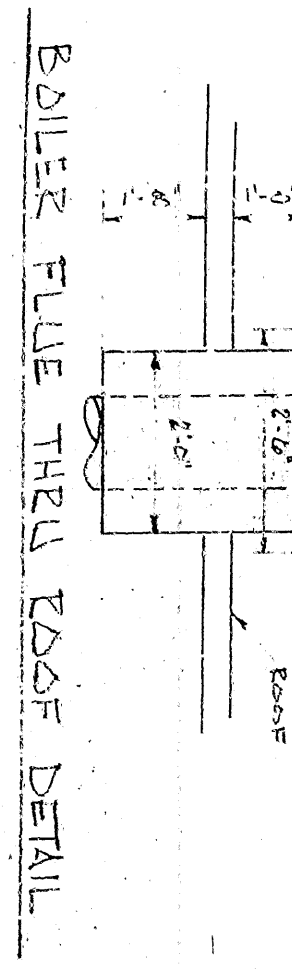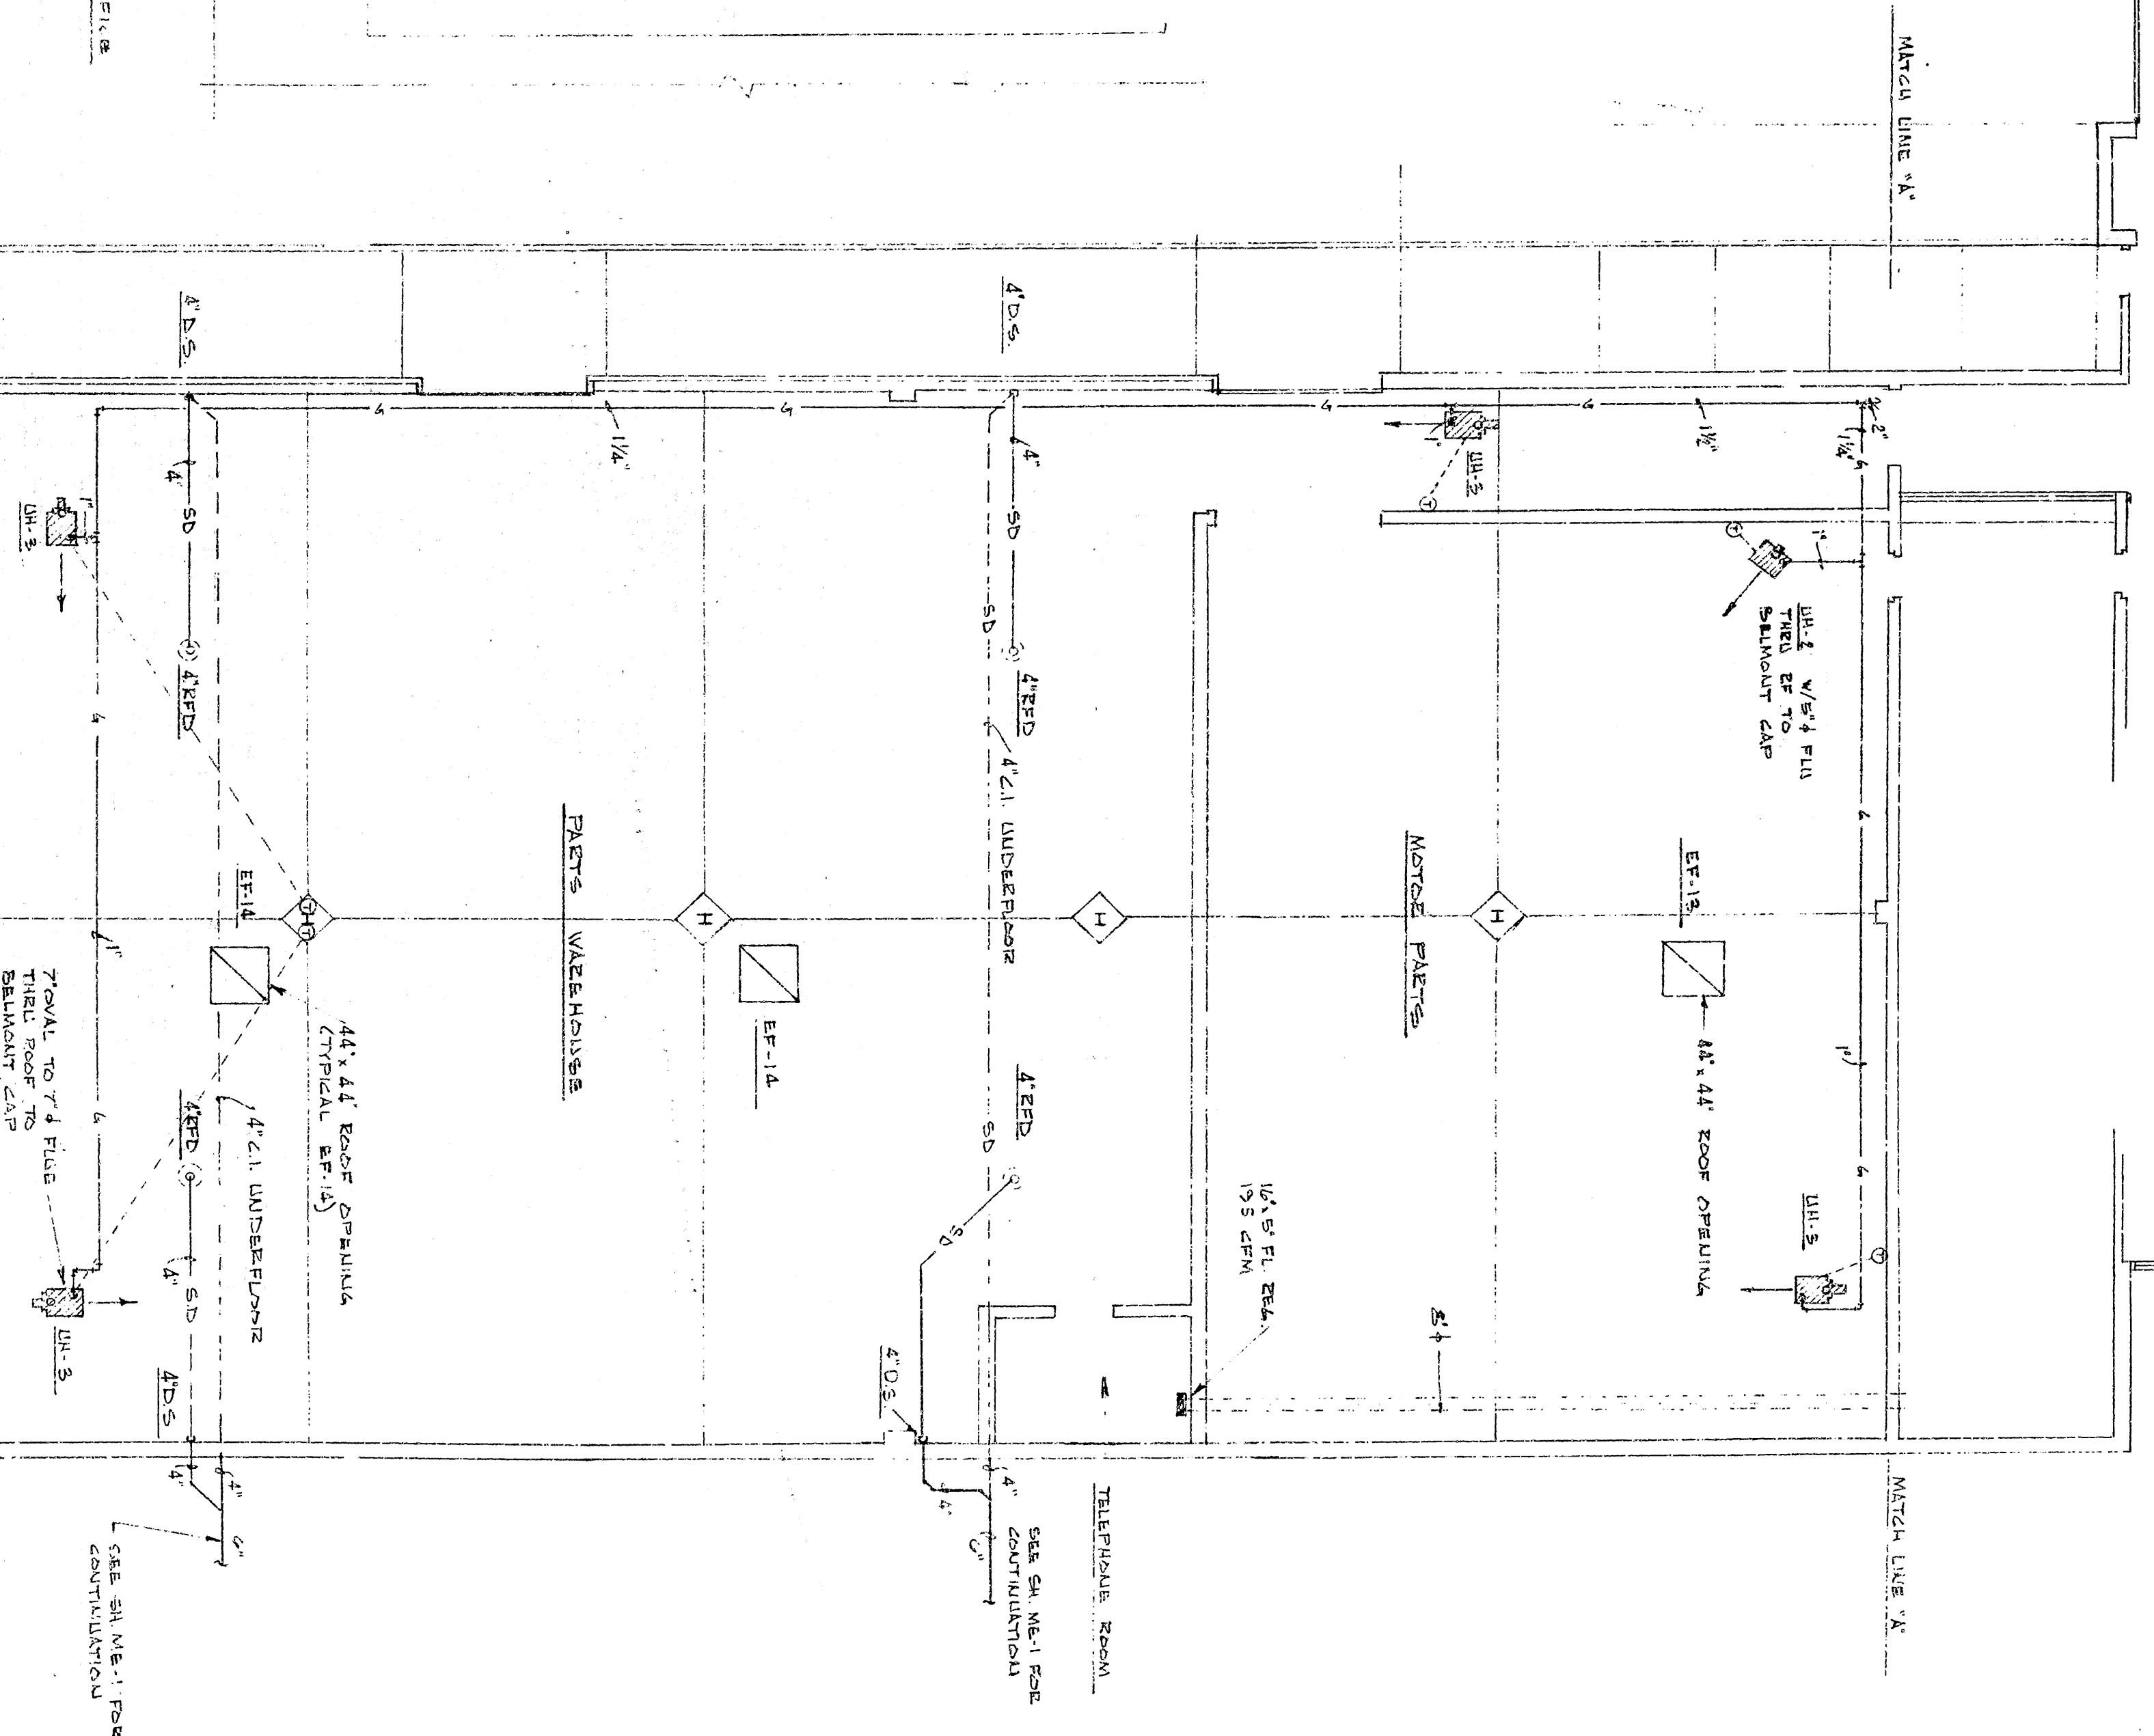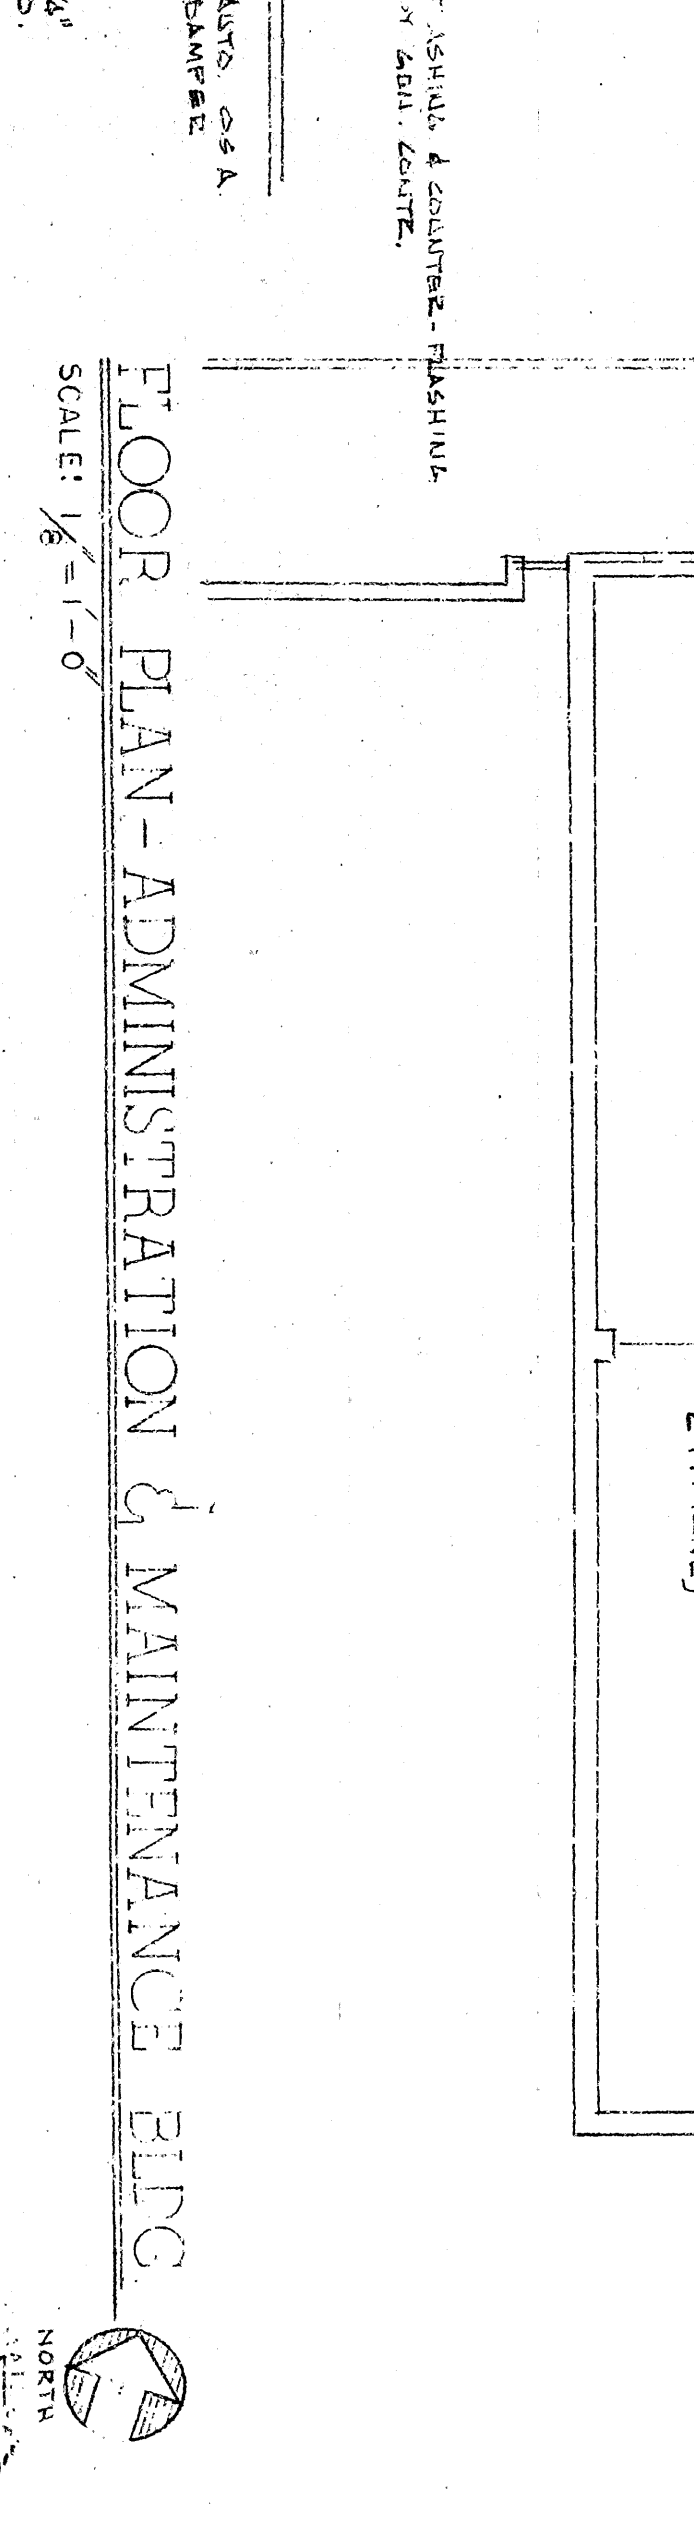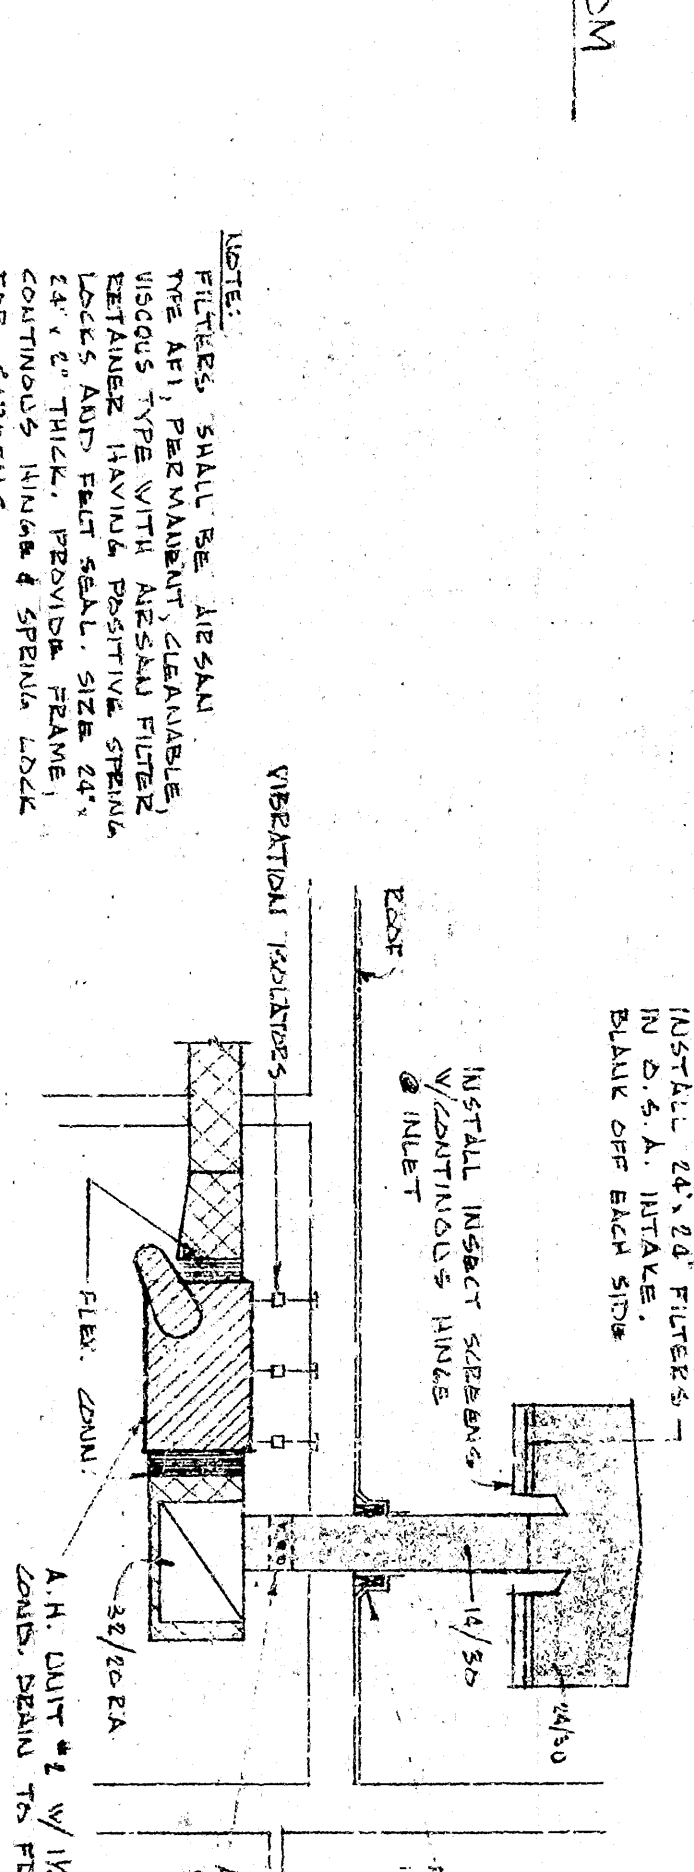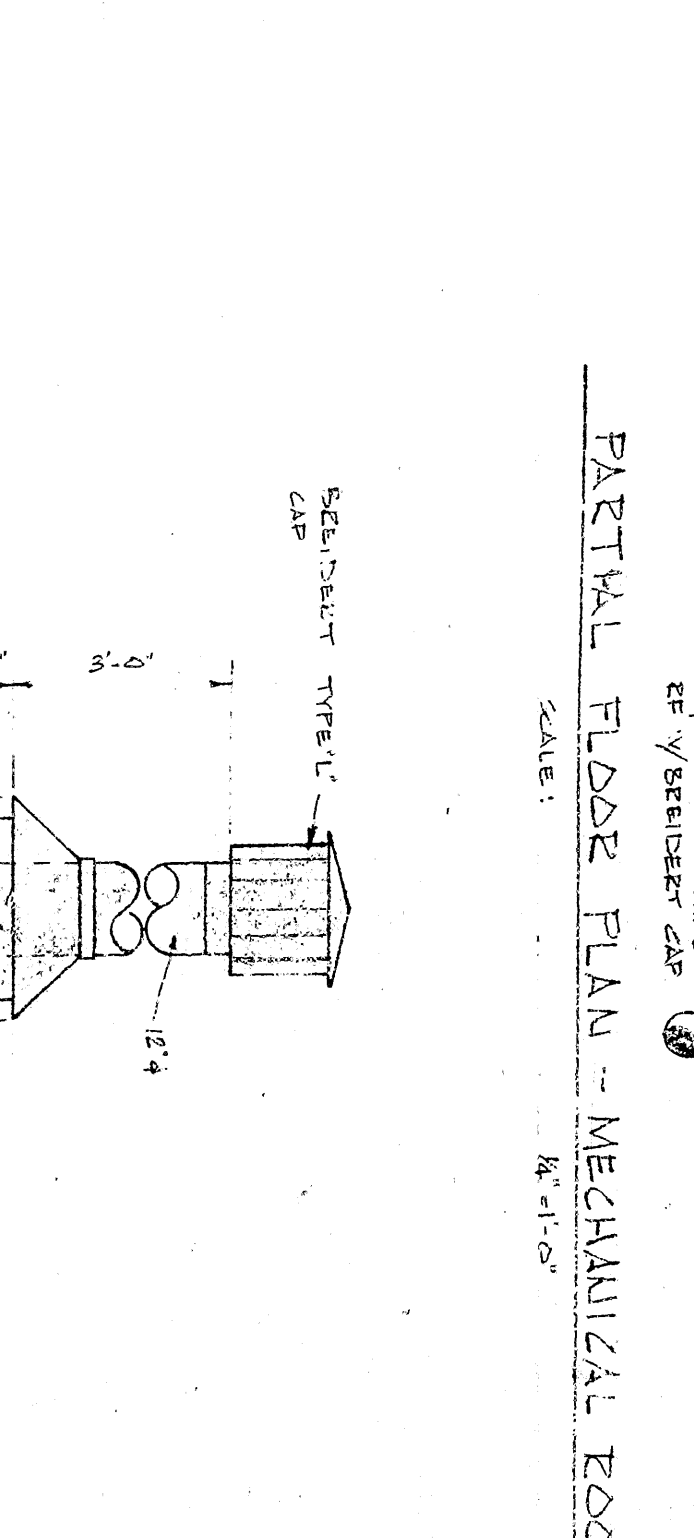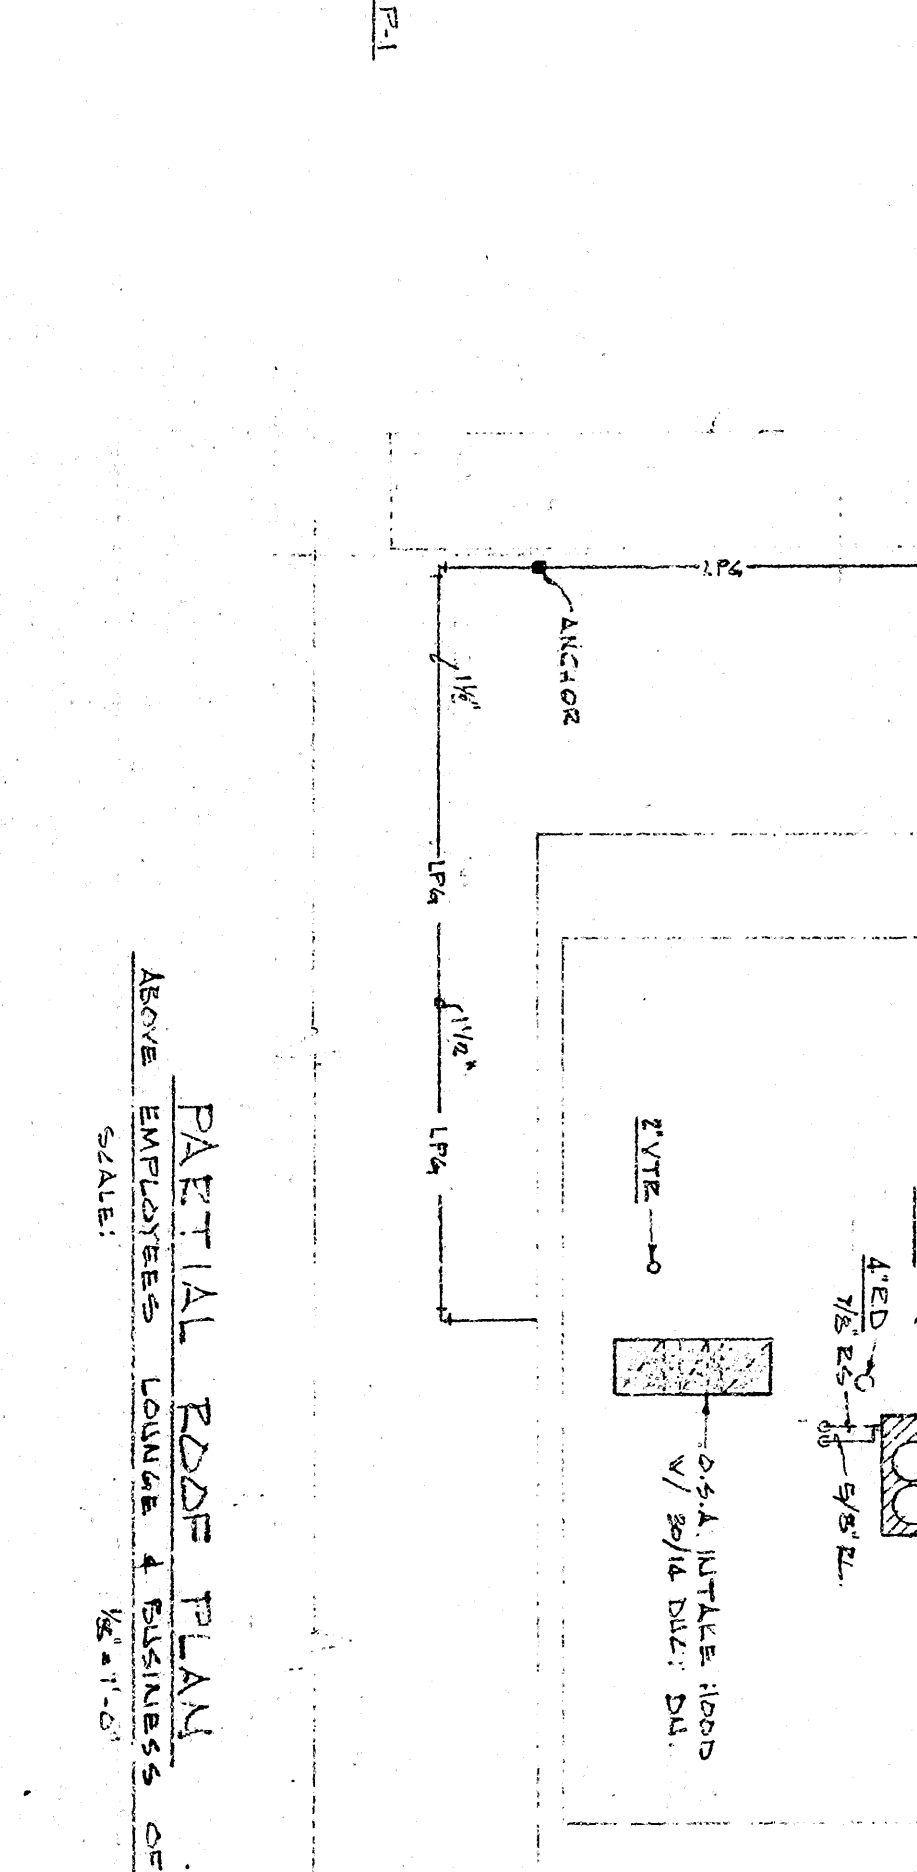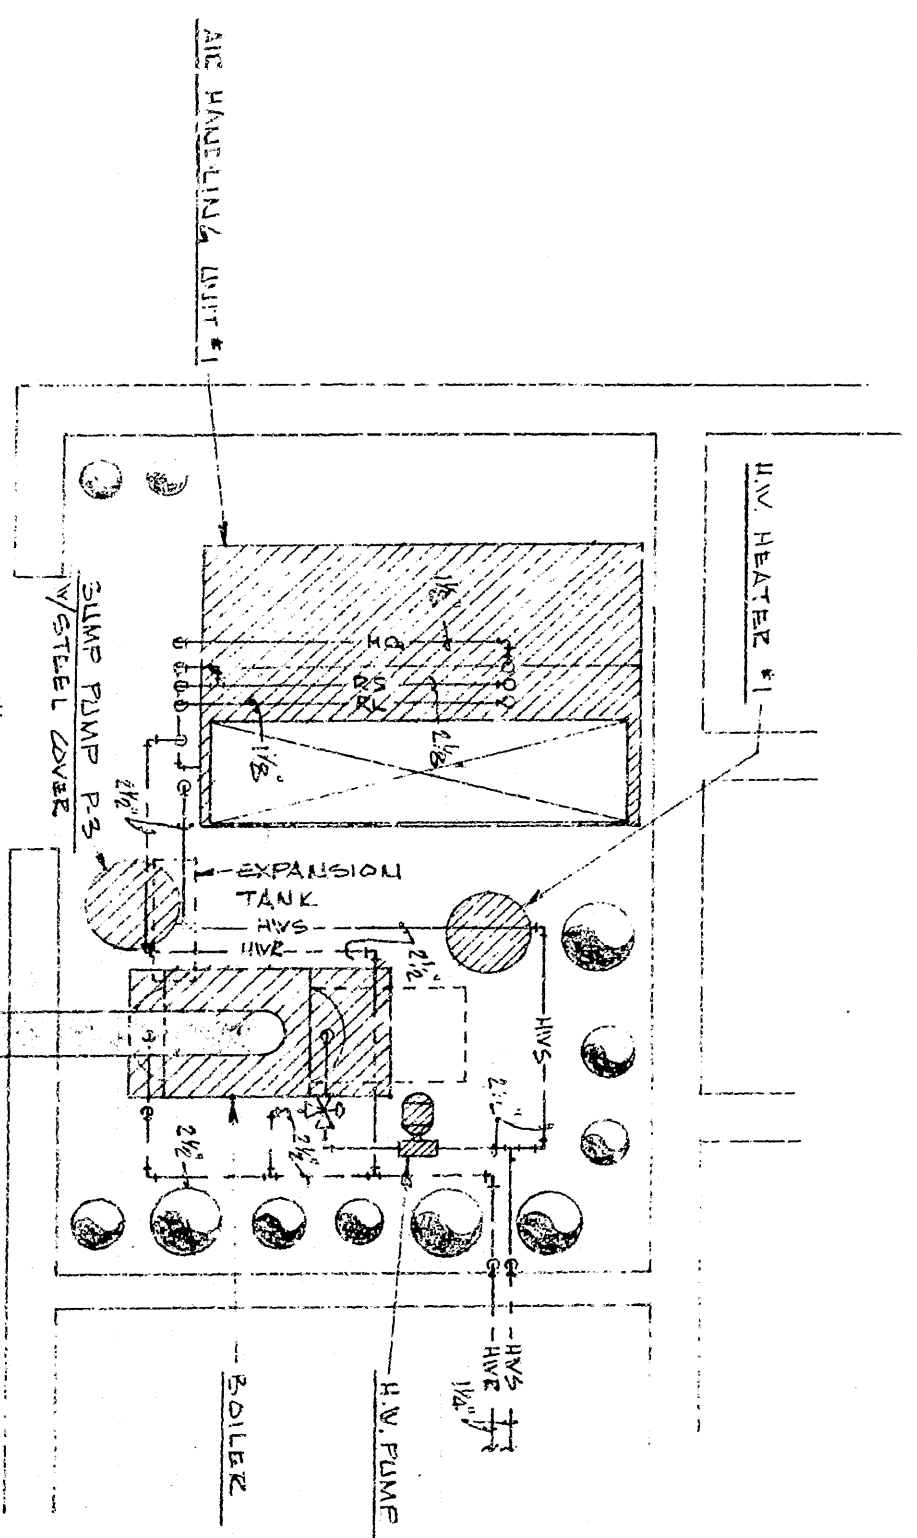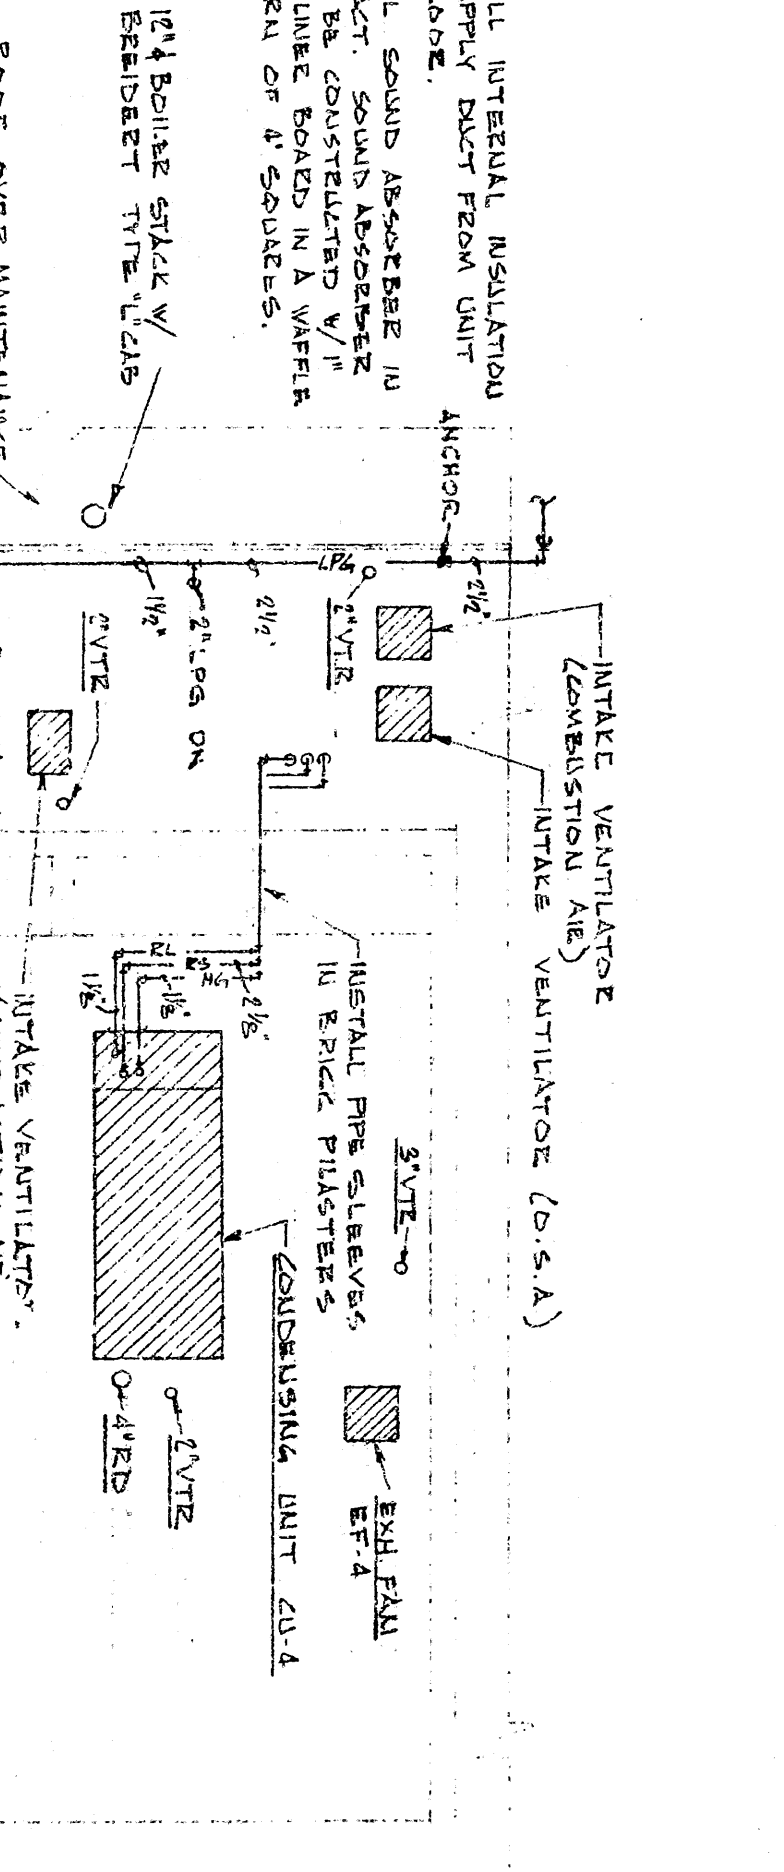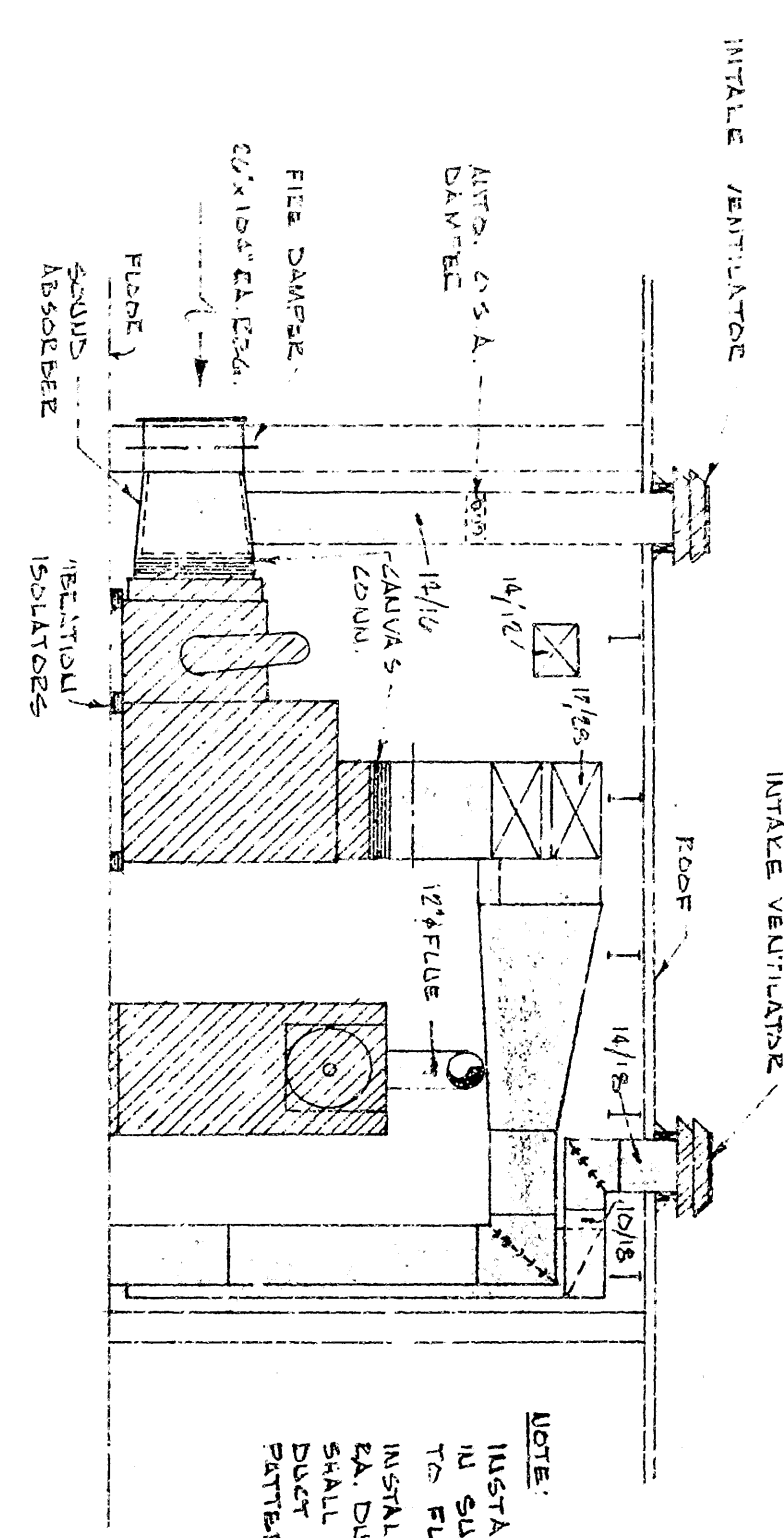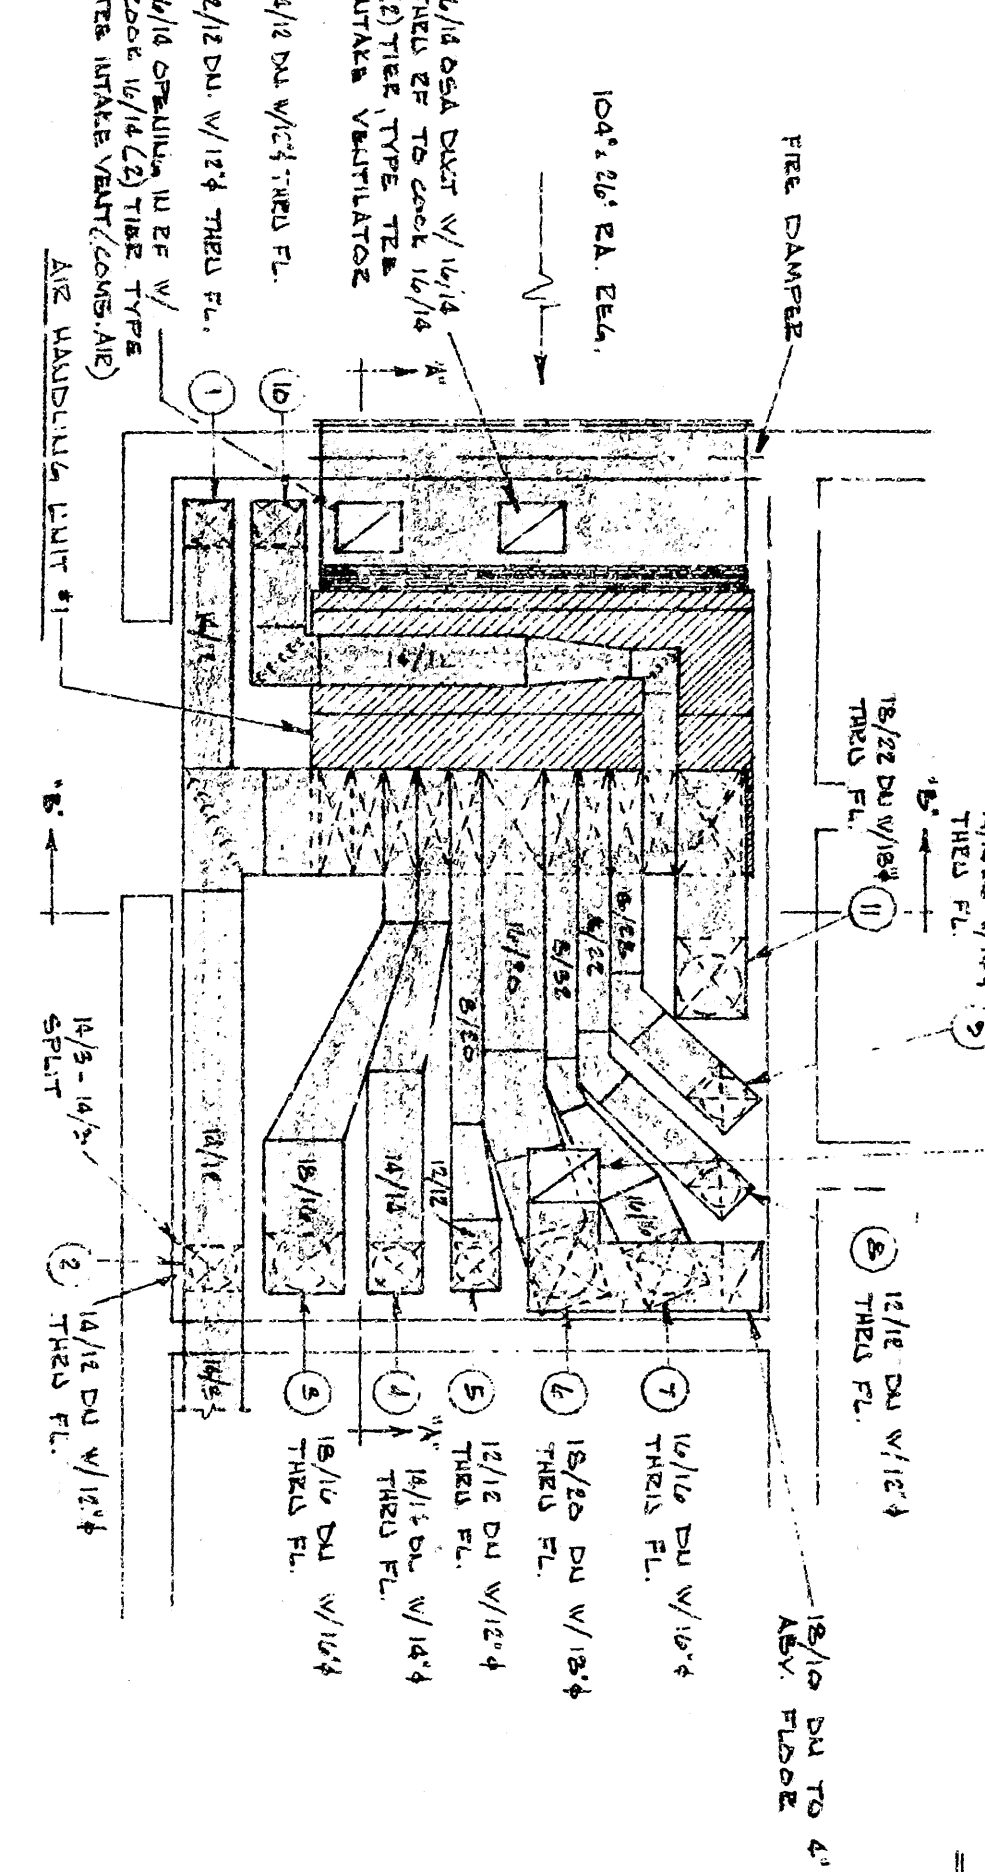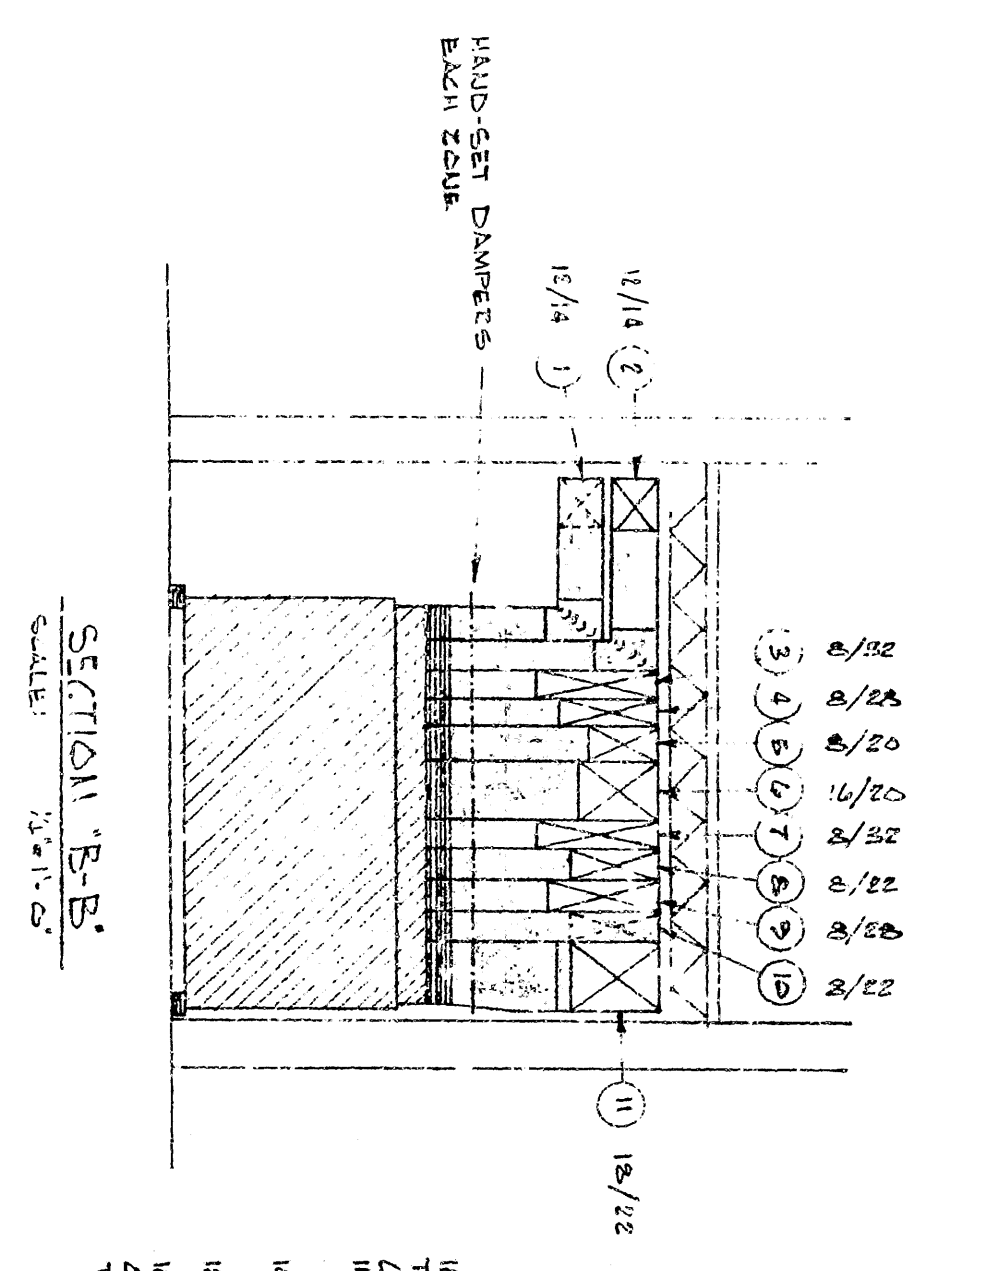

DISTRICT 3 HEADQUARTERS
 STATE OF ARKANSAS HIGHWAY DEPARTMENT
 HOPE, ARKANSAS
 WITTENBERG, DELONY & DAVIDSON, INC.
 ARCHITECTS - ENGINEERS
 LITTLE ROCK, ARKANSAS
 DISTRICT 3 HEADQUARTERS
 STATE JOB 3-746B
 PLUMBING, HEATING & AIR CONDITIONING
 ADMINISTRATION & MAINTENANCE BUILDING
 FLOOR PLAN & DETAILS
 1550E
 3-15-72
 1001
 REGISTERED
 PROFESSIONAL
 ARCHITECT
 STATE OF ARKANSAS
 NO. 795
 KENNETH A.
 PETTIT & PETTIT
 ARCHITECTS
 LITTLE ROCK, ARKANSAS