

ARKANSAS STATE HIGHWAY AND TRANSPORTATION DEPARTMENT
CONSTRUCTION PLANS FOR STATE HIGHWAY

**FREEMAN BRANCH
STR. & APPRS. (S)**

CARROLL COUNTY


ROUTE 221 SECTION 0

JOB 090346

FEDERAL AID PROJ. NHPP-0008(32)


DATE REVISED	DATE FILMED	DATE REVISED	DATE FILMED	FED. DIST. NO.	STATE	FED. AID PROJ. NO.	SHEET NO.	TOTAL SHEETS
				6	ARK.			
						JOB NO. 090346	1	56

② FREEMAN BRANCH STR. & APPRS. (S)

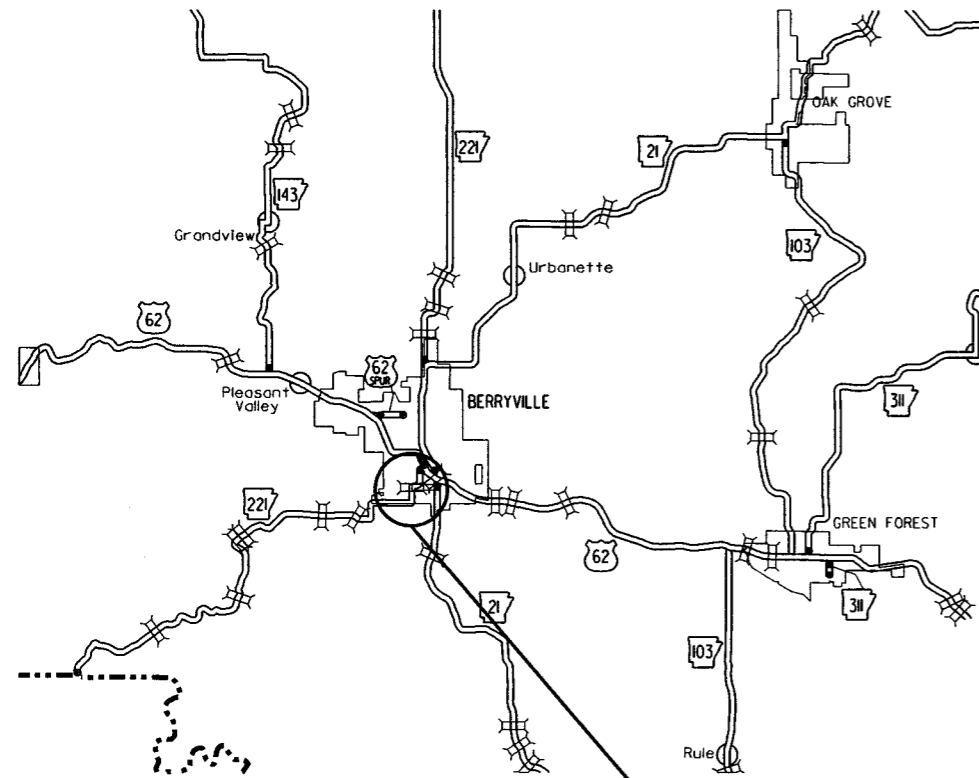

VICINITY MAP

PROJECT LOCATION

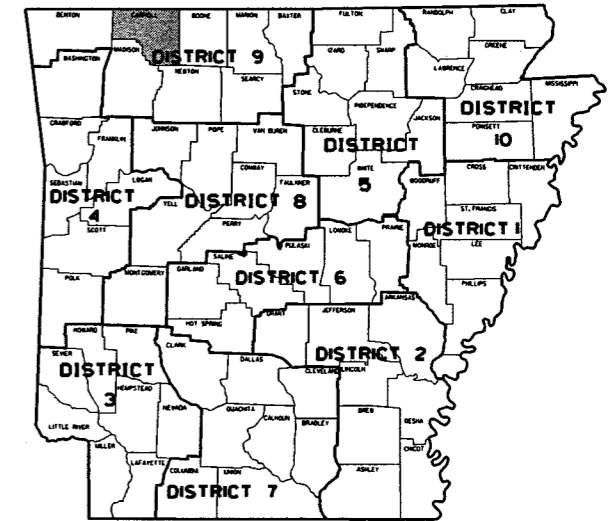


ARK. HWY. DIST. NO. 9

NOT TO SCALE

STRUCTURES OVER 20'-0" SPAN

- ① STA. 109+90 CONSTRUCT
TRI. 10' X 7' X 59" R.C. BOX CULVERT
(15° RT. FWD. SKEW)
WITH 3:1 WINGS
0.25 = 1210 C.F.S. D.A. = 1107 ACRES
SPAN = 33'-11"

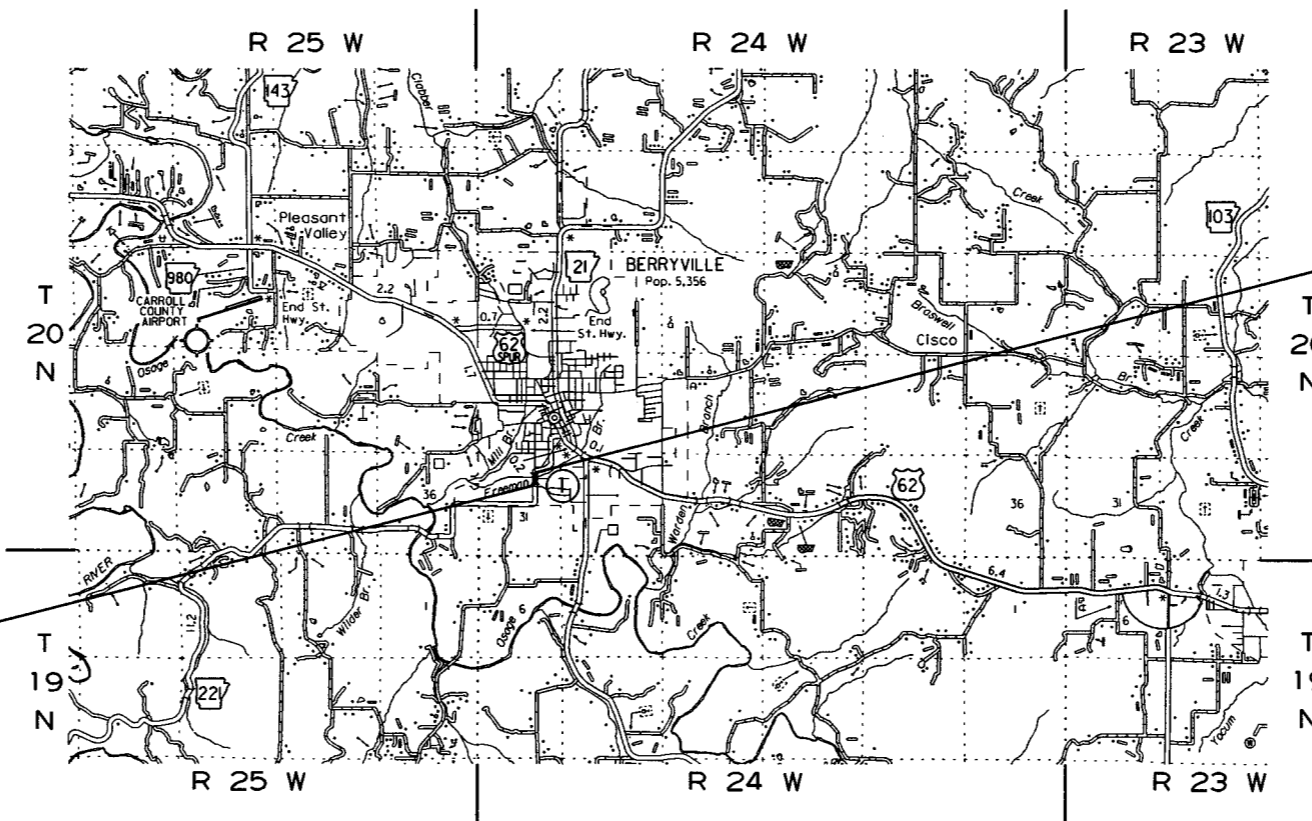

STA. 107+33.00
BEGIN JOB 090346
LOG MILE 9.87

STA. 110+67.66
END JOB 090346



APPROVED



7-28-16
DEPUTY DIRECTOR
AND CHIEF ENGINEER

	BEGIN PROJECT	MID-POINT OF PROJECT	END PROJECT
LONGITUDE	N 36°21'22"	N 36°21'25"	N 36°21'26"
LATITUDE	W 93°34'16"	W 94°34'16"	W 93°34'16"

	GROSS LENGTH OF PROJECT	334.66	FEET	OR	0.063	MILES
NET	" " ROADWAY	300.74	"	"	0.057	"
NET	" " BRIDGES	33.92	"	"	0.006	"
NET	" " PROJECT	334.66	"	"	0.063	"

DATE REVISED	DATE FILED	DATE REVISED	DATE FILED	FED. DIST. NO.	STATE	FED. AID PROJ. NO.	SHEET NO.	TOTAL SHEETS
				6	ARK.		2	56
				JOB NO.	090346			

2 INDEX OF SHEETS, GOV. SPECS., AND GEN. NOTES

INDEX OF SHEETS

SHEET NO.	TITLE	DRWG.NO.	DATE
1	TITLE SHEET		
2	INDEX OF SHEETS, GOVERNING SPECIFICATIONS, AND GENERAL NOTES		
3 - 4	TYPICAL SECTIONS OF IMPROVEMENT		
5 - 13	SPECIAL DETAILS		
14 - 17	TEMPORARY EROSION CONTROL DETAILS		
18 - 21	MAINTENANCE OF TRAFFIC DETAILS		
22	PERMANENT PAVEMENT MARKING DETAILS		
23 - 25	QUANTITIES		
26	SUMMARY OF QUANTITIES AND REVISIONS		
27 - 28	SURVEY CONTROL DETAILS		
29 - 30	PLAN AND PROFILE SHEETS		
31	CONCRETE DITCH PAVING	CDP-1	11-17-10
32	CONCRETE PIPE CULVERT FILL HEIGHTS & BEDDING	PCC-1	2-27-14
33	METAL PIPE CULVERT FILL HEIGHTS & BEDDING	PCM-1	2-27-14
34	PLASTIC PIPE CULVERT (HIGH DENSITY POLYETHYLENE)	PCP-1	2-27-14
35	PLASTIC PIPE CULVERT (PVC F949)	PCP-2	2-27-14
36	PAVEMENT MARKING DETAILS	PM-1	5-12-16
37	DETAILS OF PIPE UNDERDRAIN	PU-1	4-10-03
38	REINFORCED CONCRETE BOX CULVERT DETAILS	RCB-1	7-26-12
39	EXCAVATION PAY LIMITS, BACKFILL, & SOLID SODDING FOR BOX CULVERTS	RCB-2	11-20-03
40	STANDARD TRAFFIC CONTROLS FOR HIGHWAY CONSTRUCTION	TC-1	9-02-15
41	STANDARD TRAFFIC CONTROLS FOR HIGHWAY CONSTRUCTION	TC-2	9-02-15
42	STANDARD TRAFFIC CONTROLS FOR HIGHWAY CONSTRUCTION	TC-3	9-02-15
43	STANDARD TRAFFIC CONTROLS FOR HIGHWAY CONSTRUCTION-TEMPORARY PRECAST BARRIER	TC-4	2-27-14
44	STANDARD TRAFFIC CONTROLS FOR HIGHWAY CONSTRUCTION-TEMPORARY PRECAST BARRIER	TC-5	10-15-09
45	TEMPORARY EROSION CONTROL DEVICES	TEC-1	12-15-11
46	TEMPORARY EROSION CONTROL DEVICES	TEC-2	6-02-94
47	TEMPORARY EROSION CONTROL DEVICES	TEC-3	11-03-94
48	TEMPORARY EROSION CONTROL DEVICES	TEC-4	7-26-12
49	WIRE FENCE TYPE C AND D	WF-4	8-22-02
50 - 56	CROSS SECTIONS		


GOVERNING SPECIFICATIONS

ARKANSAS STATE HIGHWAY COMMISSION STANDARD SPECIFICATIONS FOR HIGHWAY CONSTRUCTION, EDITION OF 2014, AND THE FOLLOWING SPECIAL PROVISIONS AND SUPPLEMENTAL SPECIFICATIONS:

NUMBER	TITLE
ERRATA	ERRATA FOR THE BOOK OF STANDARD SPECIFICATIONS
FHWA-1273	REQUIRED CONTRACT PROVISIONS FEDERAL-AID CONSTRUCTION CONTRACTS
FHWA-1273	SUPPLEMENT - EQUAL EMPLOYMENT OPPORTUNITY - NOTICE TO CONTRACTORS
FHWA-1273	SUPPLEMENT - SPECIFIC EQUAL EMPLOYMENT OPPORTUNITY RESPONSIBILITIES (23 U.S.C. 140)
FHWA-1273	SUPPLEMENT - EQUAL EMPLOYMENT OPPORTUNITY - GOALS AND TIMETABLES
FHWA-1273	SUPPLEMENT - EQUAL EMPLOYMENT OPPORTUNITY - FEDERAL STANDARDS
FHWA-1273	SUPPLEMENT - POSTERS AND NOTICES REQUIRED FOR FEDERAL-AID PROJECTS
FHWA-1273	SUPPLEMENT - WAGE RATE DETERMINATION
100-3	CONTRACTOR'S LICENSE
108-1	LIQUIDATED DAMAGES
108-2	WORK ALLOWED PRIOR TO ISSUANCE OF WORK ORDER
303-1	AGGREGATE BASE COURSE
400-1	TACK COATS
410-1	CONSTRUCTION REQUIREMENTS AND ACCEPTANCE OF ASPHALT CONCRETE PLANT MIX COURSES
604-1	RETROREFLECTIVE SHEETING FOR TRAFFIC CONTROL DEVICES IN CONSTRUCTION ZONES
620-1	MULCH COVER
JOB 090346	BIDDING REQUIREMENTS AND CONDITIONS
JOB 090346	BROADBAND INTERNET SERVICE FOR ASPHALT CONCRETE PLANT
JOB 090346	BROADBAND INTERNET SERVICE FOR FIELD OFFICE
JOB 090346	CARGO PREFERENCE ACT REQUIREMENTS
JOB 090346	COMPACTED EMBANKMENT
JOB 090346	CONSTRUCTION IN SPECIAL FLOOD HAZARD AREAS
JOB 090346	DOCUMENTATION OF PAYMENTS MADE TO DISADVANTAGED BUSINESS ENTERPRISES
JOB 090346	ISSUANCE OF PROPOSALS
JOB 090346	MANDATORY ELECTRONIC CONTRACT
JOB 090346	MANDATORY ELECTRONIC DOCUMENT SUBMITTAL
JOB 090346	OFF-SITE RESTRAINING CONDITIONS FOR BATS
JOB 090346	SHORING FOR CULVERTS
JOB 090346	SOIL STABILIZATION
JOB 090346	SPECIAL CLEARING REQUIREMENTS
JOB 090346	STORM WATER POLLUTION PREVENTION PLAN
JOB 090346	SUBMISSION OF ASPHALT CONCRETE HOT MIX ACCEPTANCE TEST RESULTS
JOB 090346	UTILITY ADJUSTMENTS
JOB 090346	WARM MIX ASPHALT
JOB 090346	WELLHEAD PROTECTION

GENERAL NOTES

- GRADE LINE DENOTES FINISHED GRADE WHERE SHOWN ON PLANS.
- ALL PIPE LINES, POWER, TELEPHONE, AND TELEGRAPH LINES TO BE MOVED OR LOWERED BY THE RESPECTIVE OWNERS AS PER AGREEMENT WITH SUCH OWNERS.
- ANY EQUIPMENT OR APPURTENANCE THAT INTERFERES WITH THE PROPOSED CONSTRUCTION AND WHICH MAY BE THE PROPERTY OF UTILITY SERVICE ORGANIZATIONS SHALL BE MOVED BY THE OWNERS UNLESS OTHERWISE PROVIDED.
- ALL LAND MONUMENTS LOCATED WITHIN THE CONSTRUCTION AREA SHALL BE PROTECTED IN ACCORDANCE WITH SECTION 107.12 OF THE STANDARD SPECIFICATIONS.
- ALL TREES THAT DO NOT DIRECTLY INTERFERE WITH THE PROPOSED CONSTRUCTION SHALL BE SPARED AS DIRECTED BY THE ENGINEER. CARE AND DISCRETION SHALL BE USED TO INSURE THAT ALL TREES NOT TO BE REMOVED SHALL BE HARMED AS LITTLE AS POSSIBLE DURING THE CONSTRUCTION OPERATIONS.
- THE CONTRACTOR SHALL BE RESPONSIBLE FOR PROVIDING A FENCE TO CONTROL LIVESTOCK IN AREAS WHERE PASTURES ARE SEVERED. WIRE FENCE MAY BE CONSTRUCTED INITIALLY, OR IN LIEU THEREOF, THE CONTRACTOR AT HIS OWN EXPENSE, MAY ELECT TO PROVIDE TEMPORARY FENCING SUITABLE TO CONTAIN LIVESTOCK.
- THIS PROJECT IS COVERED UNDER A SECTION 404 NATIONWIDE 14 PERMIT. REFER TO SECTION 110 OF THE STANDARD SPECIFICATIONS, EDITION OF 2014, FOR PERMIT REQUIREMENTS.
- ALL FLEXIBLE BASE AND ASPHALTIC PAVEMENTS REMOVED SHALL BE PAID FOR UNDER THE ITEM NO. 210 - UNCLASSIFIED EXCAVATION.
- THE EXISTING ASPHALT PAVEMENT TO BE REMOVED FROM THE REMAINING PAVEMENT SHALL BE SEPARATED BY SAWING ALONG A NEAT LINE. AFTER SAWING, THE PAVEMENT TO BE REMOVED SHALL BE CAREFULLY REMOVED IN A MANNER THAT WILL NOT DAMAGE THE PAVEMENT THAT IS TO REMAIN. ANY DAMAGE OF THE ASPHALT PAVEMENT THAT IS TO REMAIN IN PLACE SHALL BE REPAIRED AT THE CONTRACTOR'S EXPENSE.


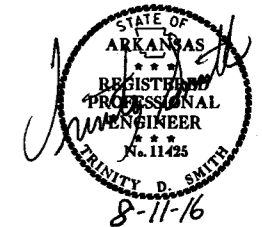


8/11/2016

R090346.DGN

DATE REVISED	DATE FILMED	DATE REVISED	DATE FILMED	FED. RD. DIST. NO.	STATE	FED. AID PROJ. NO.	SHEET NO.	TOTAL SHEETS
				6	ARK.			
						JOB NO. 090346	3	56

② TYPICAL SECTIONS OF IMPROVEMENT

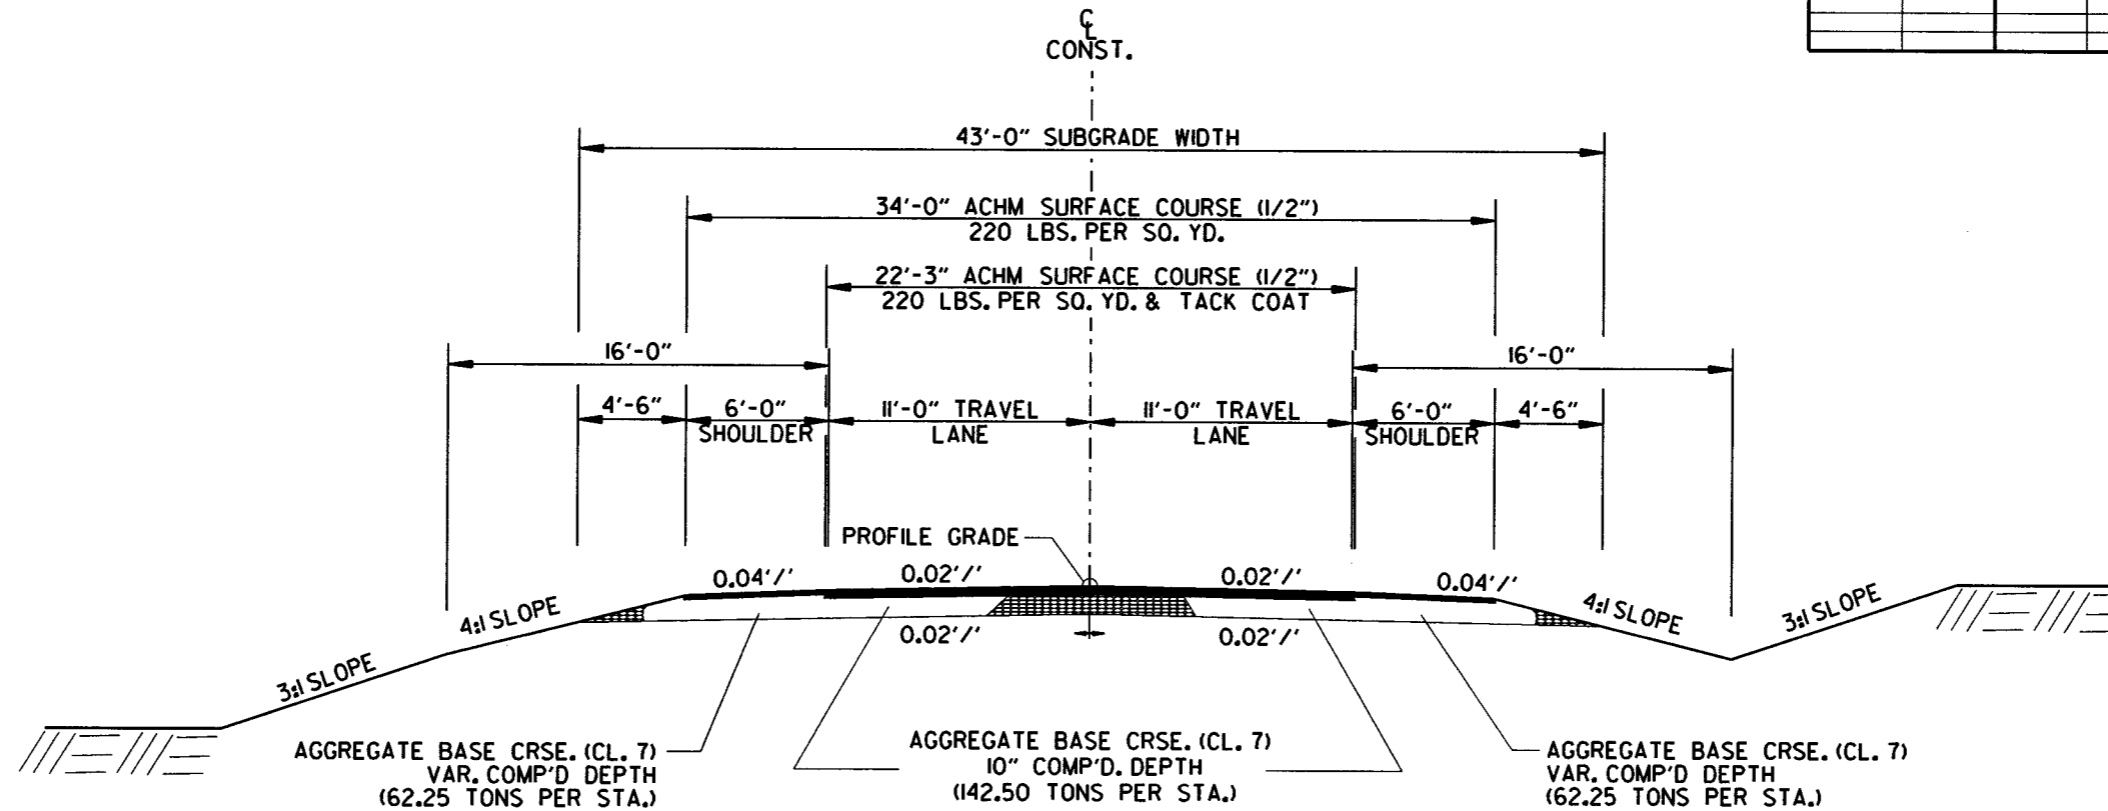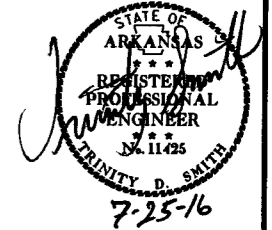

HWY. 221

NOTES:


REFER TO CROSS SECTIONS FOR DEVIATION FROM THE NORMAL SLOPES. NO CHANGES SHALL BE MADE FROM THE PLANNED SLOPES WITHOUT THE APPROVAL OF THE ENGINEER.

THE THICKNESS OF AGGREGATE BASE COURSE SHALL BE WITHIN PLUS OR MINUS ONE INCH OF THE PLAN THICKNESS SHOWN. THE CONTRACTOR WILL CORRECT ANY DEFICIENT THICKNESS THAT DOES NOT MEET TOLERANCE INDICATED. PAYMENT WILL NOT BE MADE FOR MATERIAL PLACED IN EXCESS OF THE TOLERANCE INDICATED.

THE FINAL 2" OF SURFACE COURSE IS TO BE PLACED AFTER ALL OTHER COURSES HAVE BEEN LAID. LONGITUDINAL JOINTS SHALL BE AT LANE LINES.

THE EXISTING ASPHALT PAVEMENT TO BE REMOVED FROM THE REMAINING PAVEMENT SHALL BE SEPARATED BY SAWING ALONG A NEAT LINE. AFTER SAWING, THE PAVEMENT TO BE REMOVED SHALL BE CAREFULLY REMOVED IN A MANNER THAT WILL NOT DAMAGE THE PAVEMENT THAT IS TO REMAIN. ANY DAMAGE OF THE ASPHALT PAVEMENT THAT IS TO REMAIN IN PLACE SHALL BE REPAIRED AT THE CONTRACTOR'S EXPENSE.

WITH APPROVAL OF THE ENGINEER, THE CONTRACTOR WILL BE ALLOWED TO SUBSTITUTE, AT NO ADDITIONAL COST TO THE DEPARTMENT, THE FIRST LIFT OF ACHM SURFACE COURSE (1/2") IN LIEU OF AGGREGATE BASE COURSE ON THE SHOULDERS.

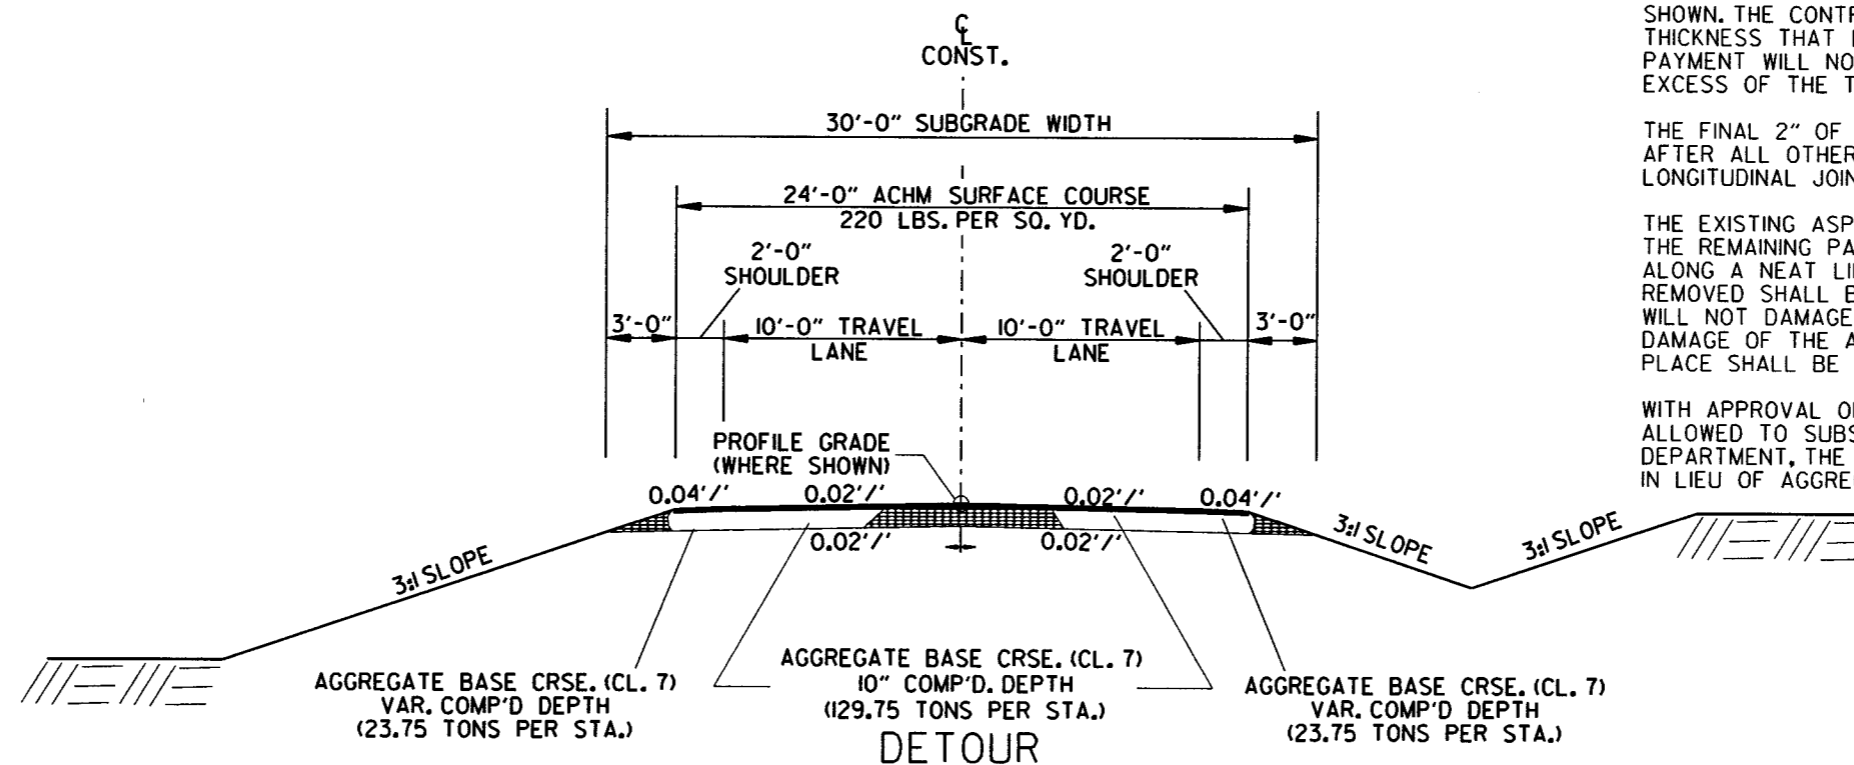

DETOUR



TYPICAL SECTIONS OF IMPROVEMENT

7/21/2016

R090346.DGN

DATE REVISED	DATE FILMED	DATE REVISED	DATE FILMED	FED. DIST. NO.	STATE	FED. PROJ. NO.	SHEET NO.	TOTAL SHEETS
				6	ARK.			
						JOB NO. 090346	4	56

② TYPICAL SECTIONS OF IMPROVEMENT

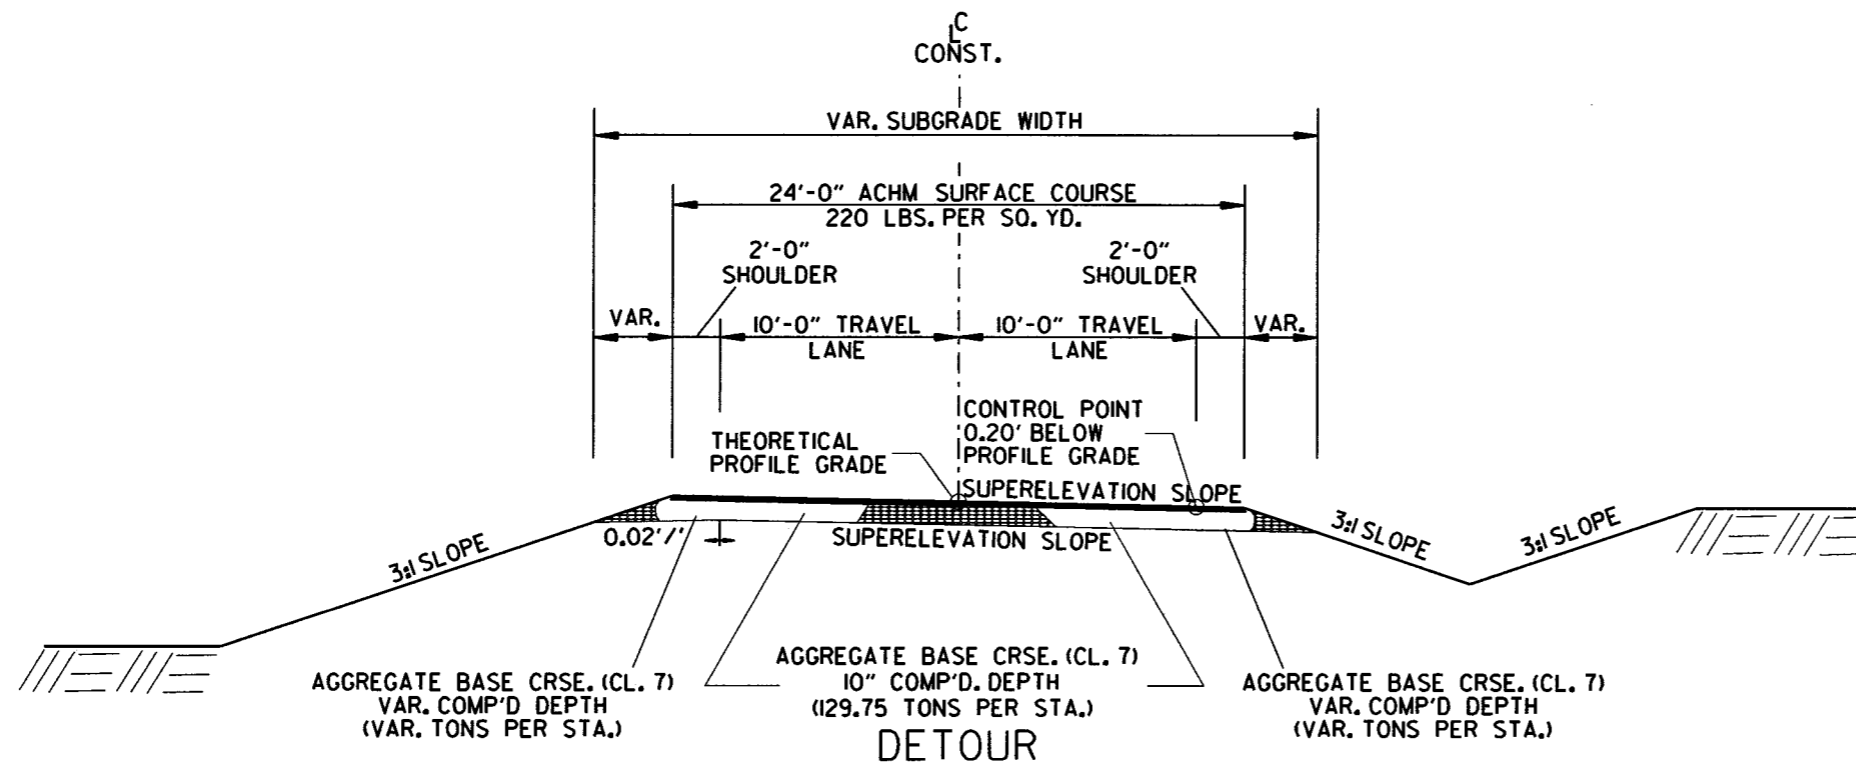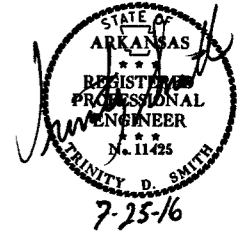

NOTES:

REFER TO CROSS SECTIONS FOR DEVIATION FROM THE NORMAL SLOPES. NO CHANGES SHALL BE MADE FROM THE PLANNED SLOPES WITHOUT THE APPROVAL OF THE ENGINEER.

THE THICKNESS OF AGGREGATE BASE COURSE SHALL BE WITHIN PLUS OR MINUS ONE INCH OF THE PLAN THICKNESS SHOWN. THE CONTRACTOR WILL CORRECT ANY DEFICIENT THICKNESS THAT DOES NOT MEET TOLERANCE INDICATED. PAYMENT WILL NOT BE MADE FOR MATERIAL PLACED IN EXCESS OF THE TOLERANCE INDICATED.



THE FINAL 2" OF SURFACE COURSE IS TO BE PLACED AFTER ALL OTHER COURSES HAVE BEEN LAID. LONGITUDINAL JOINTS SHALL BE AT LANE LINES.

THE EXISTING ASPHALT PAVEMENT TO BE REMOVED FROM THE REMAINING PAVEMENT SHALL BE SEPARATED BY SAWING ALONG A NEAT LINE. AFTER SAWING, THE PAVEMENT TO BE REMOVED SHALL BE CAREFULLY REMOVED IN A MANNER THAT WILL NOT DAMAGE THE PAVEMENT THAT IS TO REMAIN. ANY DAMAGE OF THE ASPHALT PAVEMENT THAT IS TO REMAIN IN PLACE SHALL BE REPAIRED AT THE CONTRACTOR'S EXPENSE.

WITH APPROVAL OF THE ENGINEER, THE CONTRACTOR WILL BE ALLOWED TO SUBSTITUTE, AT NO ADDITIONAL COST TO THE DEPARTMENT, THE FIRST LIFT OF ACHM SURFACE COURSE (1/2") IN LIEU OF AGGREGATE BASE COURSE ON THE SHOULDERS.


DATE REVISED	DATE FILMED	DATE REVISED	DATE FILMED	FED. RD. DIST. NO.	STATE	FED. AID PROJ. NO.	SHEET NO.	TOTAL SHEETS
				6	ARK.			
JOB NO. 090346							5	56

2 SPECIAL DETAILS

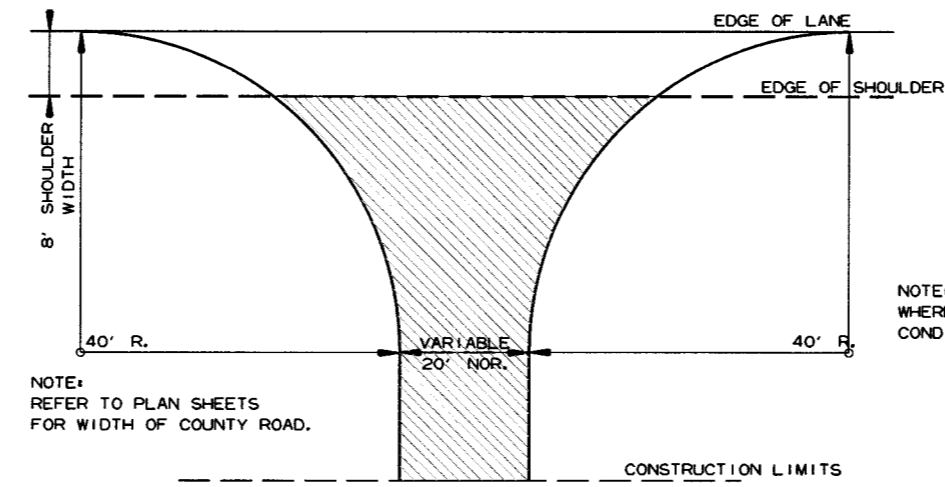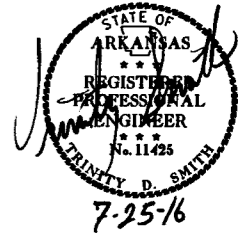


NOTE:
REFER TO PLAN SHEETS
FOR WIDTH OF COUNTY ROAD.

NOTE: TURNOUTS SHALL BE MODIFIED
WHERE NECESSARY TO MEET LOCAL
CONDITIONS AS DIRECTED BY THE ENGINEER.

 ACHM SURFACE COURSE (1/2")
(220 LBS. PER SQ. YD.) AND
AGGREGATE BASE COURSE (CLASS 7)
7" COMP. DEPTH

DETAIL FOR COUNTY ROAD TURNOUTS
OPEN SHOULDER SECTION

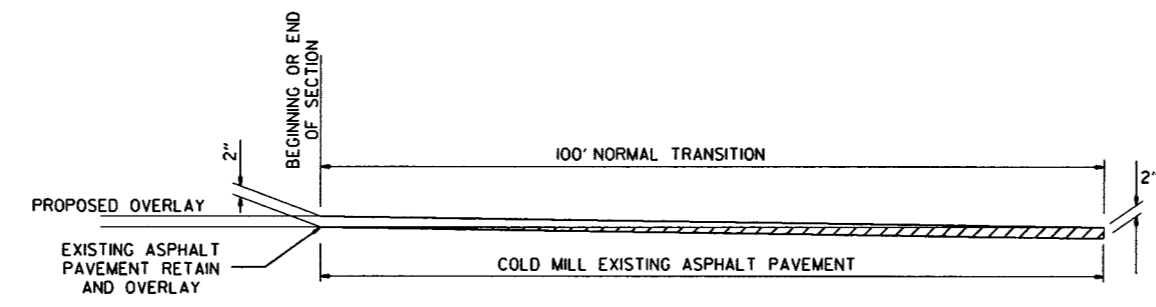

DETAIL FOR TRANSITIONS

7/21/2016

R090346.DGN

MID-SECTION

R.C. BOX SECTION		DESIGN FILL DEPTH (FT.)		CLEAR SPAN (FT.)		CLEAR HEIGHT (FT.)		TOP SLAB THK.		BOTTOM SLAB THK.		SIDE WALL THK.		INTERIOR WALL THK.		OVER ALL WIDTH		OVER ALL HEIGHT		SECTION LENGTH (FT.)		TOP SLAB REINFORCING STEEL				BOTTOM SLAB REINFORCING STEEL				SIDE WALL REINFORCING STEEL "f0"		INTERIOR WALL REINFORCING STEEL "f1"		TOP SLAB DISTRIBUTION REINF. STEEL "g"		BOTTOM SLAB DISTRIBUTION REINF. STEEL "e"		SIDE WALL DISTRIBUTION REINF. STEEL "d1"		INTERIOR WALL DISTRIBUTION REINF. STEEL "d2"			
D	S	H	T	B	C	W	OW	OH	SL	a	Bent b	c	SPACING	NO. REQ'D	d	Bent b1	f	SPACING	NO. REQ'D	SIZE	SPACING	NO. REQ'D	LENGTH	SIZE	SPACING	NO. REQ'D	LENGTH	SIZE	SPACING	NO. REQ'D	LENGTH	SIZE	SPACING	NO. REQ'D	LENGTH	SIZE	SPACING	NO. REQ'D	LENGTH	SIZE	SPACING	NO. REQ'D	LENGTH
A	5	5	4	8.0	9	6.0	8	11'-8"	5'-5"	54.83	4	11'-4"	6	11'-6"	4	11'-4"	16	41	4	11'-4"	4	11'-6"	4	11'-4"	18	36	4	8.5	154	5'-1"	4	12	108	5'-1"	4	12	23	4	12	8	4	12	8

CLASS "S" CONCRETE	REINFORCING STEEL (GR. 60)	ADTL. REINF. PER LONG LAP LOCATION (S)
0.86	97	72

SHEET 1 OF 2
 DETAILS OF R.C. BOX CULVERT
 DOUBLE BARREL BOX CULVERT
 STA. 107+52
 SPECIAL DETAILS



INLET SLOPE SECTION(S)

R.C. BOX SECTION		DESIGN FILL DEPTH (FT.)		CLEAR SPAN (FT.)		CLEAR HEIGHT (FT.)		TOP SLAB THK.		BOTTOM SLAB THK.		SIDE WALL THK.		INTERIOR WALL THK.		OVER ALL WIDTH		OVER ALL HEIGHT		SECTION LENGTH (FT.)		TOP SLAB REINFORCING STEEL				BOTTOM SLAB REINFORCING STEEL				SIDE WALL REINFORCING STEEL "f0"		INTERIOR WALL REINFORCING STEEL "f1"		TOP SLAB DISTRIBUTION REINF. STEEL "g"		BOTTOM SLAB DISTRIBUTION REINF. STEEL "e"		SIDE WALL DISTRIBUTION REINF. STEEL "d1"		INTERIOR WALL DISTRIBUTION REINF. STEEL "d2"					
D	S	H	T	B	C	W	OW	OH	SL	a	Bent b	c	SPACING	NO. REQ'D	d	Bent b1	f	SPACING	NO. REQ'D	SIZE	SPACING	NO. REQ'D	LENGTH	SIZE	SPACING	NO. REQ'D	LENGTH	SIZE	SPACING	NO. REQ'D	LENGTH	SIZE	SPACING	NO. REQ'D	LENGTH	SIZE	SPACING	NO. REQ'D	LENGTH	SIZE	SPACING	NO. REQ'D	LENGTH		

CLASS "S" CONCRETE	REINFORCING STEEL (GR. 60)	ADTL. REINF. PER LONG LAP LOCATION	ADDITIONAL CONCRETE FOR HDWL	TOTAL ADDITIONAL REINF. FOR HDWL

Bar Lap - Add one long lap for each Slope Section, and one additional long lap for Slope Sections greater than 40'-0" in length.

Design Fill Depth	Range of Actual Fill Depth
2	0.0 ft - 2.0 ft
5	>2.0 ft - 5.0 ft
10	>5.0 ft - 10.0 ft
15	>10.0 ft - 15.0 ft
20	>15.0 ft - 20.0 ft
25	>20.0 ft - 25.0 ft
30	>25.0 ft - 30.0 ft
35	>30.0 ft - 35.0 ft
40	>35.0 ft - 40.0 ft

Data shown for Mid-Section, Slope Section(s), and Skewed End Section is based on the design fill depth shown in the table, see PLAN AND PROFILE SHEETS for actual fill depth.

INLET SKEWED END SECTION

SK	SLOPE	FILL DEPTH (FT.)	CLEAR SPAN (FT.)	CLEAR HEIGHT (FT.)	SECTION LENGTH	TOP SLAB THK.	HDWL THK.	BOTTOM SLAB THK.	SIDE WALL THK.	INTERIOR WALL THK.	OVER ALL WIDTH	OVER ALL HEIGHT	TOP SLAB REINFORCING STEEL				BOTTOM SLAB REINFORCING STEEL				SIDE WALL REINFORCING STEEL		INTERIOR WALL REINFORCING STEEL		TOP SLAB DISTRIBUTION REINFORCING STEEL		BOTTOM SLAB DISTRIBUTION REINFORCING STEEL		SIDE WALL DISTRIBUTION REINFORCING STEEL		INTERIOR WALL DISTRIBUTION REINFORCING STEEL									
													SIZE	SPACING	LENGTHS VARY	NO. REQ'D	SIZE	SPACING	LENGTHS VARY	NO. REQ'D	SIZE	SPACING	NO. REQ'D	LENGTH	SIZE	SPACING	NO. REQ'D	LENGTH	SIZE	SPACING	NO. REQ'D	LENGTH	SIZE	SPACING	NO. REQ'D	LENGTH	SIZE	SPACING	NO. REQ'D	LENGTH
15	3:1	5	5	4	3'-7"	8	3	9	6	8	11'-8"	5'-5"	4	6	3	4	5	4	9	4	11	4	8.5	11	4	12	8	5'-1"	4	12	23	4	12	23	4	12	4	12	8	3'-5"

CLASS "S" CONCRETE (includes HDWL)	REINFORCING STEEL (GR. 60) (includes HDWL)
3.30	489

Any Bar Lap Required for the Skewed End Section shall be considered subsidiary to the Item "Reinforcing Steel - Roadway (Gr. 60)."

INLET WINGWALL TABLE

OVER ALL WIDTH	CLEAR HEIGHT	FOOTING THK.	WING WALL THK.	BOX SKEW (DEG.)	SLOPE	HDWL LENGTH	HEEL	WALL HEIGHT		WING WALL ANGLE (DEGREE)		FOOTING WIDTH AT WALL END	WIDTH OF WING FOOTINGS AT HDWL		FOOTING DIMENSION PARALLEL WITH HDWL		LENGTH OF WING WALLS		LENGTH OF FOOTING HEEL		CLASS "S" CONCRETE (Includes apron)	REINFORCING STEEL (includes apron and lips if required)
								AT HDWL	AT WING END	WING A	WING B		WING A	WING B	WING A	WING B	WING A	WING B	WING A	WING B		
OW	H	WB	CW	SK	SL	K	HL	WH1	WH2	AP1	AF2	WE	WF1	WF2	G1	G2	W1	W2	W3	W4	INLET	INLET
11'-8"	4'-0"	0'-9"	0'-8"	15	3:1	11'-0 1/2"	1'-0"	4'-10"	1'-4"	15	45	2'-2"	2'-4 3/4"	2'-6 7/8"	0'-5 7/8"	0'-3 1/4"	10'-6"	14'-6"	12'-4 5/8"	16'-4 5/8"	4.91	464

MID-SECTION
 BAR LAP TABLE

# of Long Laps Req'd.	SL = Section Length
0	< 40.0 ft
1	> 40.0 ft - 78.0 ft
2	> 78.0 ft - 116.0 ft
3	> 116.0 ft - 154.0 ft
4	> 154.0 ft - 192.0 ft
5	> 192.0 ft - 230.0 ft
6	> 230.0 ft - 268.0 ft
7	> 268.0 ft - 306.0 ft
8	> 306.0 ft - 344.0 ft

Min. Bar Lap Length	Bar Dia.
#4	1'-9"
#5	2'-2"
#6	2'-7"
#7	3'-6"
#8	4'-7"

Bar Dia. Table	Bar Dia.
#4	3"
#5	3 3/4"
#6	4 1/2"
#7	5 1/4"
#8	6"



TABULAR DATA BY: A.M.S. DATE: 6/23/15
 CHECKED BY: E.J.S. DATE: 6/23/15

This drawing to be used in conjunction with SHEET 1 OF 4, "GENERAL DETAILS OF R.C. BOX CULVERT", "GENERAL NOTES & LONGITUDINAL SECTION LENGTH SCHEDULE", SHEET 3 OF 4, "GENERAL DETAILS OF R.C. BOX CULVERT", "DETAILS OF MULTI-BARREL R.C. BOX CULVERT", SHEET 4 OF 4, "GENERAL DETAILS OF R.C. BOX CULVERT", "DETAILS OF WING WALLS", and STANDARD DRAWING RCB-2.
 For additional information and outlet sections, see Sheet 2 of 2.

OUTLET SLOPE SECTIONS)

Table for Outlet Slope Sections with columns for R.C. Box Section, Design Fill Depth, Clear Span, Top Slab Thk., Bottom Slab Thk., Side Wall Thk., Interior Wall Thk., Overall Width, Overall Height, Section Length, Top Slab Reinforcing Steel, Bottom Slab Reinforcing Steel, Side Wall Reinforcing Steel, Interior Wall Reinforcing Steel, Top Slab Distribution Reinf. Steel, Bottom Slab Distribution Reinf. Steel, Side Wall Distribution Reinf. Steel, Interior Wall Distribution Reinf. Steel.

Summary table for Outlet Slope Sections with columns: CLASS "S" CONCRETE, REINFORCING STEEL (GR. 60), @OVL. REINF. PER LONG LAP LOCATION, ADDITIONAL CONCRETE FOR HDWL, TOTAL ADDITIONAL REINF. FOR HDWL.

2 Bar Lap - Add one long lap for each Slope Section, and one additional long lap for Slope Sections greater than 40'-0" in length.

OUTLET SKEWED END SECTION

Table for Outlet Skewed End Section with columns for Skew (Degree), Slope, Fill Depth, Clear Span, Clear Height, Section Length, Top Slab Thk., HDWL Thk., Bottom Slab Thk., Side Wall Thk., Interior Wall Thk., Overall Width, Overall Height, Top Slab Reinforcing Steel, Bottom Slab Reinforcing Steel, Side Wall Reinforcing Steel, Interior Wall Reinforcing Steel, Top Slab Distribution Reinforcing Steel, Bottom Slab Distribution Reinforcing Steel, Side Wall Distribution Reinforcing Steel, Interior Wall Distribution Reinforcing Steel.

Summary table for Outlet Skewed End Section with columns: CLASS "S" CONCRETE (includes HDWL), REINFORCING STEEL (GR. 60) (includes HDWL), CU. YDS., LBS.

OUTLET WINGWALL TABLE


Main table for Outlet Wingwall Table with columns for Wing A and Wing B, including dimensions like Over All Width, Clear Height, Footing Thk., Wing Wall Thk., Box Skew, Slope, HDWL Length, Heel, Wall Height, Wing Wall Angle, Footing Width at Wall End, Width of Wing Footings at HDWL, Footing Dimension Parallel with HDWL, Length of Wingwalls, Length of Footing Heel, Class "S" Concrete, and Reinforcing Steel.

Min. Bar Lap Length table with columns for Bar Size (#4 to #8) and Lap Length (1'-9" to 4'-7").

Bar Fin Dia. Table with columns for Bar Size (#4 to #8) and Bar Fin Diameter (3" to 6").

1 Any Bar Lap Required for the Skewed End Section shall be considered subsidiary to the Item "Reinforcing Steel - Roadway (Gr. 60)."

Project information table with columns: DATE REVISED, DATE FILMED, DATE REVISION, DATE FILMED, FED. ROAD DIST. NO., STATE, FED. AD PROJ. NO., SHEET NO., TOTAL SHEETS.

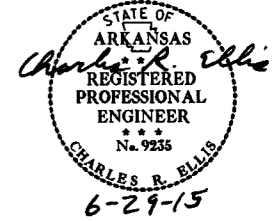

TABULAR DATA BY: A.M.S. DATE: 6/23/15 CHECKED BY: EOR DATE: 6/23/15

MID-SECTION

Table with columns for R.C. BOX SECTION, DESIGN FILL DEPTH, CLEAR SPAN, CLEAR HEIGHT, TOP SLAB THK., BOTTOM SLAB THK., SIDE WALL THK., INTERIOR WALL THK., OVER ALL WIDTH, OVER ALL HEIGHT, SECTION LENGTH, TOP SLAB REINFORCING STEEL, BOTTOM SLAB REINFORCING STEEL, SIDE WALL REINFORCING STEEL, INTERIOR WALL REINFORCING STEEL, TOP SLAB DISTRIBUTION REINFORCING STEEL, BOTTOM SLAB DISTRIBUTION REINFORCING STEEL, SIDE WALL DISTRIBUTION REINFORCING STEEL, INTERIOR WALL DISTRIBUTION REINFORCING STEEL.

Table with columns: CLASS 'S' CONCRETE, REINFORCING STEEL (GR. 60), ADTL. REINF. PER LONG. LAP PER LONG. LAP LOCATION (S), CU. YDS., LBS PER LIN. FT., LBS.

INLET SLOPE SECTIONS(S)

Table with columns for R.C. BOX SECTION, DESIGN FILL DEPTH, CLEAR SPAN, CLEAR HEIGHT, TOP SLAB THK., BOTTOM SLAB THK., SIDE WALL THK., INTERIOR WALL THK., OVER ALL WIDTH, OVER ALL HEIGHT, SECTION LENGTH, BOTTOM SLAB REINFORCING STEEL, SIDE WALL REINFORCING STEEL, INTERIOR WALL REINFORCING STEEL, TOP SLAB DISTRIBUTION REINFORCING STEEL, BOTTOM SLAB DISTRIBUTION REINFORCING STEEL, SIDE WALL DISTRIBUTION REINFORCING STEEL, INTERIOR WALL DISTRIBUTION REINFORCING STEEL.

Table with columns: CLASS 'S' CONCRETE, REINFORCING STEEL (GR. 60), ADTL. REINF. PER LONG. LAP PER LONG. LAP LOCATION, ADDITIONAL CONCRETE FOR HDWL, TOTAL ADTL. REINF. FOR HDWL, CU. YDS., LBS.

Bar Lap - Add one long.lap for each Slope Section, and one additional long. lap for Slope Sections greater than 40'-0" in length.

Table with columns: Design Fill Depth, Range of Actual Fill Depth.

Data shown for Mid-Section, Slope Sections, and Skewed End Section is based on the design fill depth shown in the table, see PLAN AND PROFILE SHEETS for actual fill depth.

INLET SKEWED END SECTION

Table with columns for SK, SLOPE, DESIGN FILL DEPTH, CLEAR SPAN, CLEAR HEIGHT, SECTION LENGTH, TOP SLAB THK., HDWL THK., BOTTOM SLAB THK., SIDE WALL THK., INTERIOR WALL THK., OVER ALL WIDTH, OVER ALL HEIGHT, TOP SLAB REINFORCING STEEL, BOTTOM SLAB REINFORCING STEEL, SIDE WALL REINFORCING STEEL, INTERIOR WALL REINFORCING STEEL, TOP SLAB DISTRIBUTION REINFORCING STEEL, BOTTOM SLAB DISTRIBUTION REINFORCING STEEL, SIDE WALL DISTRIBUTION REINFORCING STEEL, INTERIOR WALL DISTRIBUTION REINFORCING STEEL.

Table with columns: CLASS 'S' CONCRETE (includes HDWL), REINFORCING STEEL (GR. 60) (includes HDWL), CU. YDS., LBS.

Any Bar Lap Required for the Skewed End Section shall be considered subsidiary to the item "Reinforcing Steel - Roadway (Gr. 60)."

INLET WINGWALL TABLE

Large table with columns for OVER ALL WIDTH, CLEAR HEIGHT, FOOTING THK., WING WALL THK., BOX SKEW (DEG.), SLOPE, HDWL LENGTH, HEEL, WALL HEIGHT, WINGWALL ANGLE (DEGREE), FOOTING WIDTH AT WALL END, WIDTH OF WING FOOTINGS AT HDWL, FOOTING DIMENSION PARALLEL WITH HDWL, LENGTH OF WINGWALLS, LENGTH OF FOOTING HEEL, CLASS 'S' CONCRETE, REINFORCING STEEL.

MID-SECTION BAR LAP TABLE

Table with columns: # of Long. Laps Req'd, Section Length, REINF. STEEL QTY. PER WING (LBS).


Table with columns: Min. Bar Lap Length, Bar #, Length.

Table with columns: Bar Pin Dia. Table, Bar #, Pin Dia.

This drawing to be used in conjunction with SHEET 1 OF 4, "GENERAL DETAILS OF R.C. BOX CULVERT", "GENERAL NOTES & LONGITUDINAL SECTION LENGTH SCHEDULE", SHEET 3 OF 4, "GENERAL DETAILS OF R.C. BOX CULVERT", "DETAILS OF MULTI-BARREL R.C. BOX CULVERT", SHEET 4 OF 4, "GENERAL DETAILS OF R.C. BOX CULVERT", "DETAILS OF WINGWALLS", and STANDARD DRAWING RCB-2.

For additional information and outlet sections, see Sheet 2 of 2.

Table with columns: DATE REVISED, DATE FILMED, DATE REVISED, DATE FILMED, FED. ROAD DIST. NO., STATE, FED. AID PROJ. NO., SHEET NO., TOTAL SHEETS.

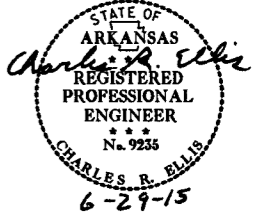

TABULAR DATA BY: A.M.S. DATE: 6/23/15, CHECKED BY: EOR DATE: 6/23/15



OUTLET SLOPE SECTION(S)

R.C. BOX SECTION	DESIGN FILL DEPTH (FT.)	CLEAR SPAN (FT.)	CLEAR HEIGHT (FT.)	TOP SLAB THK.	BOTTOM SLAB THK.	SIDE WALL THK.	INTERIOR WALL THK.	OVER ALL WIDTH	OVER ALL HEIGHT	SECTION LENGTH (FT.)	REINFORCING STEEL																			
											LENGTH = OW - 4' + BENDS				LENGTH = OW - 4' + BENDS				SIDE WALL REINFORCING STEEL "b"		INTERIOR WALL REINFORCING STEEL "f1"		TOP SLAB DISTRIBUTION REINFORCING STEEL "g"		BOTTOM SLAB DISTRIBUTION REINFORCING STEEL "e"		SIDE WALL DISTRIBUTION REINFORCING STEEL "d1"		INTERIOR WALL DISTRIBUTION REINFORCING STEEL "d2"	
											a	Bent b	c	SPACING	d	Bent b1	f	SPACING	NO. REQ'D	LENGTH	NO. REQ'D	LENGTH	NO. REQ'D	LENGTH	NO. REQ'D	LENGTH	NO. REQ'D	LENGTH	NO. REQ'D	LENGTH
HW											ADDITIONAL REINF. FOR HDWL				"h" BARS															
											LBS.	SIZE	Y	LENGTH	NO. REQ'D															

CLASS "S" CONCRETE	REINFORCING STEEL (GR. 60)	ADTL. REINF. PER LONG LAP LOCATION	ADDITIONAL CONCRETE FOR HDWL	TOTAL ADTL. REINF. FOR HDWL
CU. YDS. PER LIN. FT.	LBS. PER LIN. FT.	LBS.	CU. YDS.	LBS.

② Bar Lap - Add one long lap for each Slope Section, and one additional long lap for Slope Sections greater than 40'-0" in length.

OUTLET SKEWED END SECTION

SKEW (DEGREE)	SLOPE	DESIGN FILL DEPTH (FT.)	CLEAR SPAN (FT.)	CLEAR HEIGHT (FT.)	SECTION LENGTH	TOP SLAB THK.	HDWL THK.	BOTTOM SLAB THK.	SIDE WALL THK.	INTERIOR WALL THK.	OVER ALL WIDTH	OVER ALL HEIGHT	TOP SLAB REINFORCING STEEL				BOTTOM SLAB REINFORCING STEEL				SIDE WALL REINFORCING STEEL		INTERIOR WALL REINFORCING STEEL		TOP SLAB DISTRIBUTION REINFORCING STEEL		BOTTOM SLAB DISTRIBUTION REINFORCING STEEL		SIDE WALL DISTRIBUTION REINFORCING STEEL		INTERIOR WALL DISTRIBUTION REINFORCING STEEL															
													a	b	c	NO. REQ'D	d	e	f	NO. REQ'D	NO. REQ'D	LENGTH	NO. REQ'D	LENGTH	g	NO. REQ'D	LENGTH	NO. REQ'D	h	NO. REQ'D	i	NO. REQ'D	LENGTH	NO. REQ'D	j	NO. REQ'D	LENGTH	NO. REQ'D	k	NO. REQ'D	LENGTH	NO. REQ'D				
15	3:1	5	10	7	6'-5"	10	3	10	8.5	8	32'-9"	8'-8"	5	5	17	8	8	11	4	5	17	4	5.5	16	5	8.5	19	8'-4"	4	12	28	8'-4"	4	11	71	4	11	71	4	12	7	LONG	14	LONG		

CLASS "S" CONCRETE (includes HDWL)	REINFORCING STEEL (GR. 60) (includes HDWL)
CU. YDS.	LBS.
18.15	3372

OUTLET WINGWALL TABLE

OVER ALL WIDTH	CLEAR HEIGHT	FOOTING THK.	WING WALL THK.	BOX SKEW (DEG.)	SLOPE	HDWL LENGTH	HEEL	WALL HEIGHT		WING WALL ANGLE (DEGREE)		FOOTING WIDTH AT WALL END	WIDTH OF WING FOOTINGS AT HDWL		FOOTING DIMENSION PARALLEL WITH HDWL		LENGTH OF WINGWALLS		LENGTH OF FOOTING HEEL		CLASS "S" CONCRETE (Includes apron)	REINFORCING STEEL (Includes apron and laps if required)
								AT HDWL	AT WING END	WING A	WING B		WING A	WING B	WING A	WING B	WING A	WING B				
OW	H	WB	CW	SK	SL	K	HL	WH1	WH2	AF1	AF2	WE	WF1	WF2	G1	G2	W1	W2	W3	W4	CU. YD	LBS.
32'-9"	7'-0"	0'-9"	0'-8"	15	3:1	32'-5 1/4"	2'-0"	7'-10"	2'-4"	15	45	3'-2"	3'-7 3/4"	4'-1"	0'-8 7/8"	1'-0"	17'-0"	23'-0"	20'-2 3/8"	26'-2 3/8"	13.37	1057

Min. Bar Lap Length

#4	1'-9"
#5	2'-2"
#6	2'-7"
#7	3'-6"
#8	4'-7"


Bar Pin Dia. Table

#4	3"
#5	3 3/4"
#6	4 1/2"
#7	5 1/4"
#8	6"

① Any Bar Lap Required for the Skewed End Section shall be considered subsidiary to the item "Reinforcing Steel - Roadway (Gr. 60)."

DATE REVISED	DATE FILMED	DATE REVISED	DATE FILMED	FED. ROAD DIST. NO.	STATE	FED. AID PROJ. NO.	SHEET NO.	TOTAL SHEETS
				6	ARK.			
				JOB NO.	090346		9	50

SPECIAL DETAILS

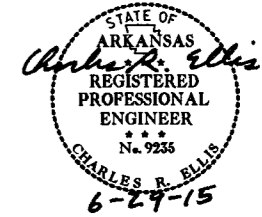

TABULAR DATA BY: A.M.S. DATE: 6/23/15
 CHECKED BY: FOR DATE: 6/23/15





DATE REVISED	DATE FILMED	DATE REVISED	DATE FILMED	FED. ROAD DIST. NO.	STATE	FED. AID PROJ. NO.	SHEET NO.	TOTAL SHEETS
				6	ARK.		10	56
				JOB NO.	090346		SPECIAL DETAILS	

2:1 Slope	20'-0"	10'-0"	10'-0"	10'-0"	10'-0"	10'-0"	10'-0"
3:1 Slope	30'-0"	15'-0"	15'-0"	15'-0"	15'-0"	15'-0"	15'-0"
4:1 Slope	40'-0"	20'-0"	20'-0"	20'-0"	20'-0"	20'-0"	20'-0"

Note: For fill depths 10' and under, use Mid-Section full length of box culvert.

* LL = Skewed End Section Length - See "Skewed End Section Details" Length LL varies with skew angle, overall box width and fill depth and may eliminate the need for some slope section lengths as shown.

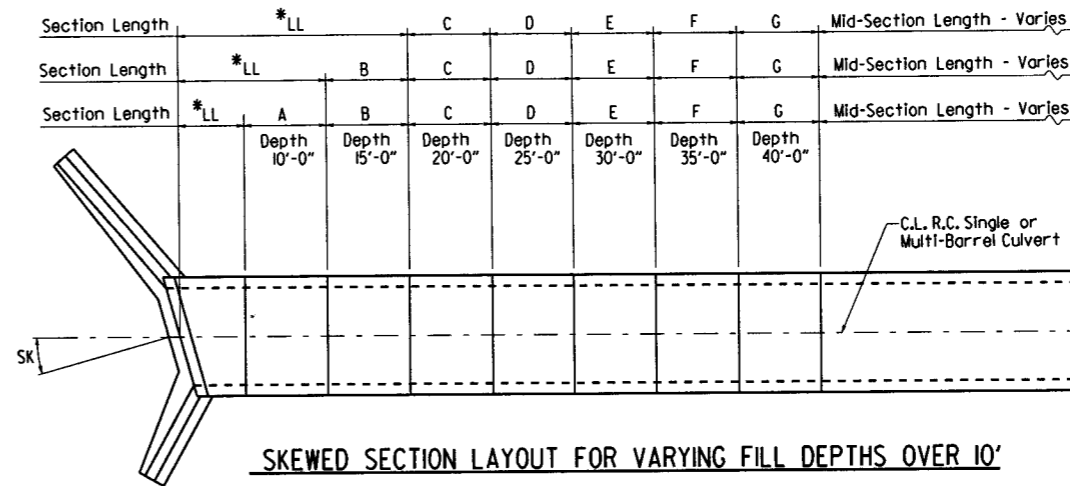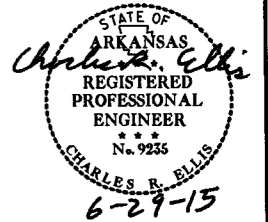

Slope Section Length @ 2:1 Slope	A=12'-0"	B=6'-0"	C=6'-0"	D=6'-0"	E=6'-0"	F=6'-0"	G=6'-0"	Mid-Section Length - Varies
Slope Section Length @ 3:1 Slope	A=22'-0"	B=11'-0"	C=11'-0"	D=11'-0"	E=11'-0"	F=11'-0"	G=11'-0"	Mid-Section Length - Varies
Slope Section Length @ 4:1 Slope	A=32'-0"	B=16'-0"	C=16'-0"	D=16'-0"	E=16'-0"	F=16'-0"	G=16'-0"	Mid-Section Length - Varies

LONGITUDINAL SECTION LENGTH SCHEDULE FOR VARYING FILL DEPTHS OVER 10'

Lengths for Non-Skewed Boxes

GENERAL NOTES:

CONSTRUCTION SPECIFICATIONS: Arkansas State Highway and Transportation Department Standard Specifications for Highway Construction (2014 edition) with applicable Supplemental Specifications and Special Provisions. Section and Subsection refer to the Standard Construction Specifications unless otherwise noted in the Plans.

DESIGN SPECIFICATIONS: AASHTO LRFD Bridge Design Specifications, Fifth Edition (2010) with 2010 Interim revisions.

LIVE LOADING: HL-93

All concrete shall be Class 5 with a minimum 28-day compressive strength of 3,500 psi and shall be poured in the dry. All exposed corners to have 1/4" chamfers.

Reinforcing Steel shall be Grade 60 (yield strength = 60,000 psi) conforming to AASHTO M31 or M322, Type A, with mill test reports.

Reinforcing Steel Tolerances: The tolerances for reinforcing steel shall meet those listed in 'Manual of Standard Practice' published by Concrete Reinforcing Steel Institute (CRSI) except that the tolerance for truss bars such as Figure 3 on page 7-4 of the CRSI Manual shall be minus zero to plus 1/2 inch.

Excavation and backfilling shall be in accordance with the requirements of Section 801.

Membrane Waterproofing shall conform to the requirements of Section 815. Membrane Waterproofing shall be Type C and as directed by the Engineer applied to all construction joints in the top slab and the sidewalls of R.C. Box culverts and to the construction joint between wingwalls and R.C. Box culvert walls.

Weep Holes in box culvert walls shall have a maximum horizontal spacing of 10'-0" and shall be spaced to clear all reinforcing steel. The drain opening shall be 4" diameter and shall be placed 12" above the top of the bottom slab.


Weep Holes in wingwalls shall have a maximum horizontal spacing of 10'-0" and shall be spaced to clear all reinforcing steel. There shall be a minimum of two (2) weep holes in each wingwall. The drain opening shall be 4" diameter and shall be placed 12" above the top of the wingwall footing.

The barrel components of the culvert may be constructed using continuous pours. For longer culvert construction, the Contractor may use multiple pours with transverse construction joints spaced a minimum of 50 feet apart unless superseded by stage construction or site constraints as approved by the Engineer. Construction joints between footings and walls shall be made only where shown in the Plans. Joints shall be normal to the centerline of barrel and shall be keyed. Longitudinal reinforcing shall be continuous through joints unless shown otherwise. All longitudinal construction joints shall be submitted to the Engineer for approval.

Membrane Waterproofing, Weep Holes, Geotextile Filter Fabric, and Drainage Fill Material will not be paid for directly but shall be considered subsidiary to Class 5 Concrete.


When the top slab of the box culvert serves as finished roadway surface, curing and finishing shall be in accordance with subsections 802.17 and 802.20 for bridge roadway surface and a trowel finish shall be applied in accordance with subsection 802.19 for Class 5 Tined Bridge Roadway Surface Finish. Curing and finishing shall not be paid for directly, but shall be considered incidental to the item "Class 5 Concrete-Roadway". Class 1 Protective Surface Treatment shall be applied to the roadway surface and this work shall be paid for under the unit price bid for "Class 1 Protective Surface Treatment".

When precast reinforced concrete box culverts are substituted for cast in place box culverts, they shall be manufactured according to ASTM C 1577 and meet the requirements of Section 607. When the top slab of the box culvert serves as the finished roadway surface, a precast reinforced concrete box culvert substitution is not allowed.

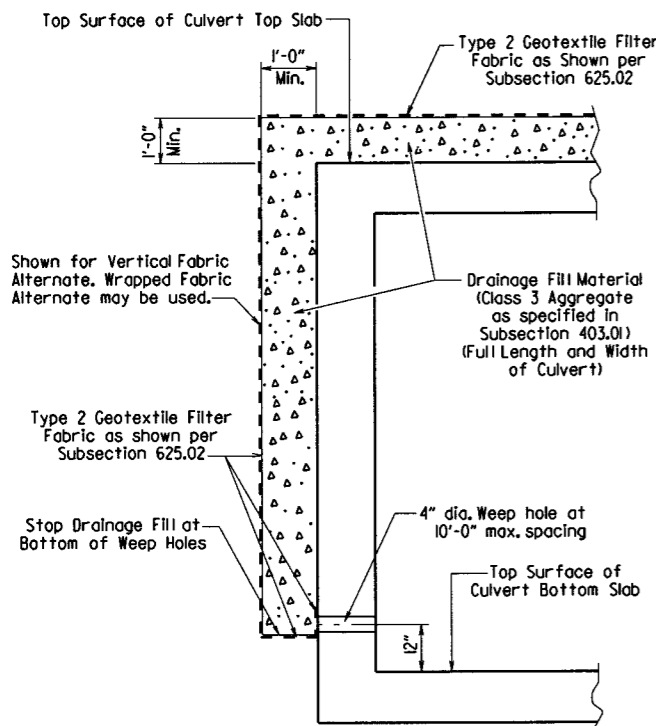

CULVERT DRAINAGE DETAIL FOR ROCK FILL

This detail shall be used when rock fill is specified for embankment construction.

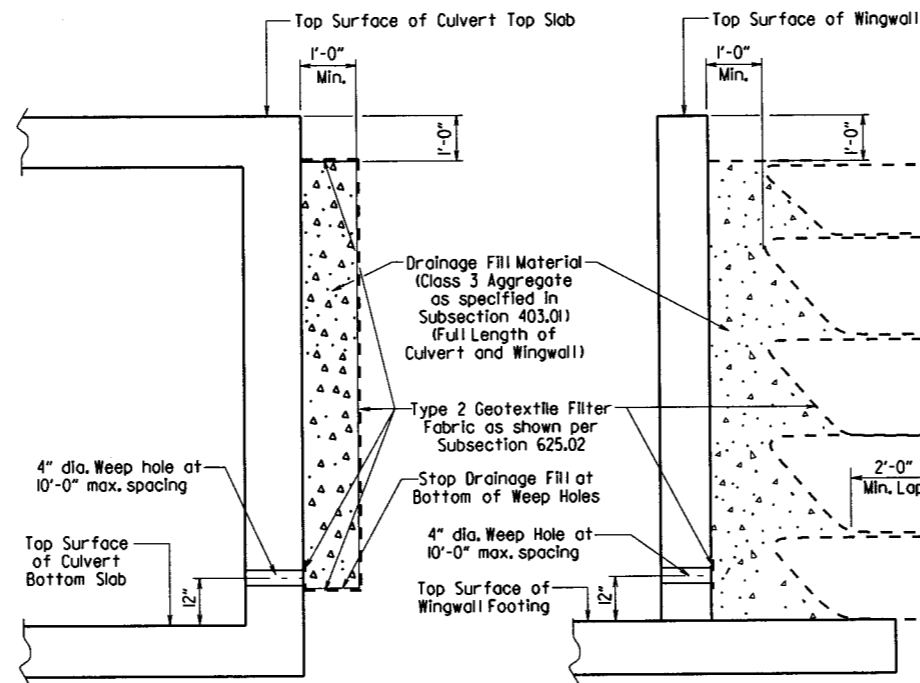

VERTICAL FABRIC ALTERNATE

(Shown for Culvert, Similar for Wingwall)

WRAPPED FABRIC ALTERNATE

(Shown for Wingwall, Similar for Culvert)

For Details of Excavation and Pay Limits, see Standard Drawing RCB-2.

WINGWALL & CULVERT DRAINAGE DETAIL


SHEET 1 OF 4
GENERAL DETAILS OF R.C. BOX CULVERT
GENERAL NOTES &
LONGITUDINAL SECTION LENGTH SCHEDULE

SPECIAL DETAILS




DATE REVISED	DATE FILMED	DATE REVISED	DATE FILMED	FED. ROAD DIST. NO.	STATE	FED. AID PROJ. NO.	SHEET NO.	TOTAL SHEETS
				6	ARK.			
				JOB NO.	090346		11	56


1 SPECIAL DETAILS

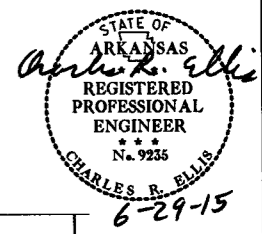

Note: When top slab of culvert serves as finished roadway surface, see General Notes on Sheet 1 of 4.

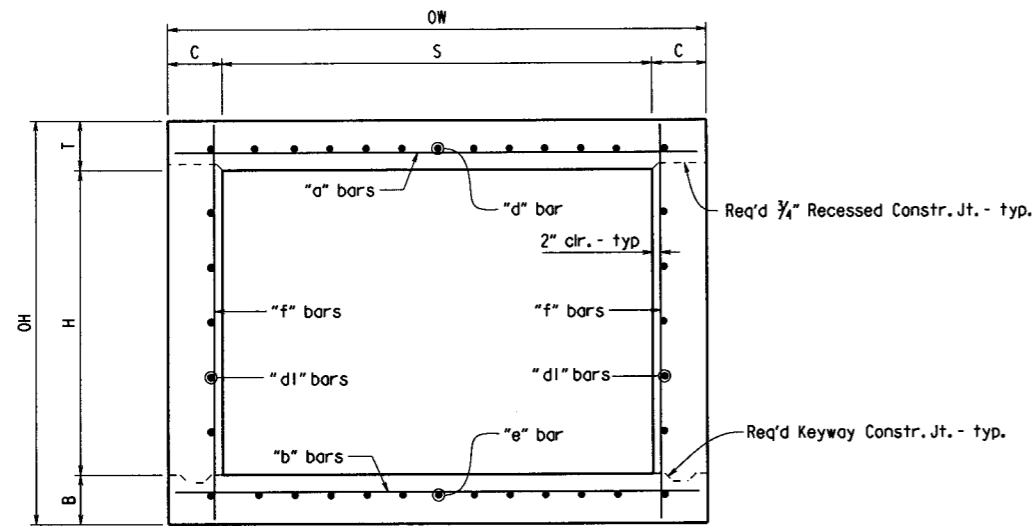


TYPICAL SECTION M-M

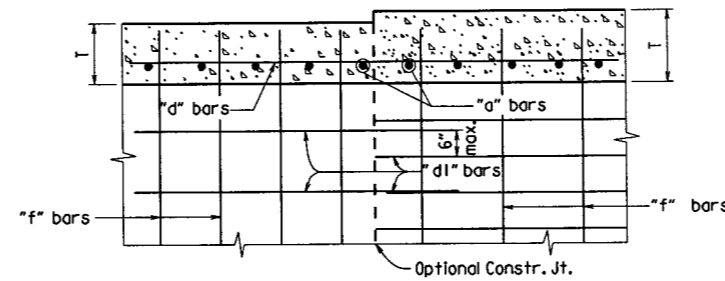


LONGITUDINAL LAP DETAIL AT CHANGE IN SECTIONS

TOP SLAB SHOWN, BOTTOM SLAB SIMILAR

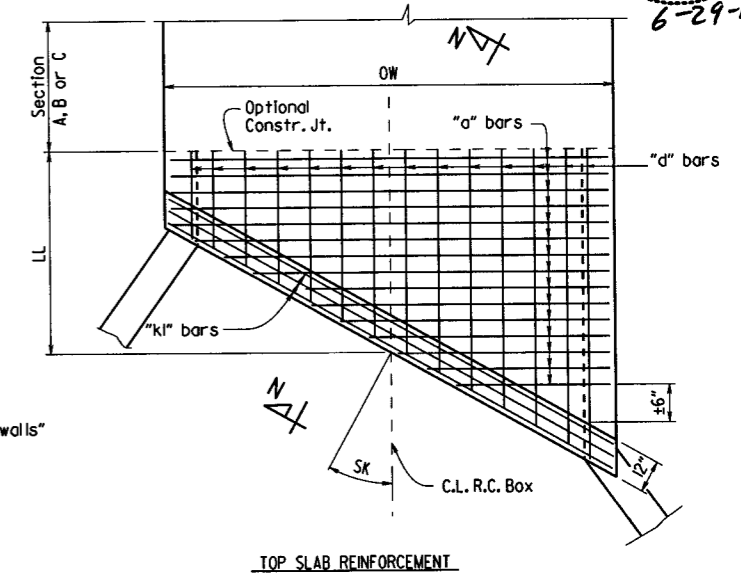


TOP SLAB REINFORCEMENT

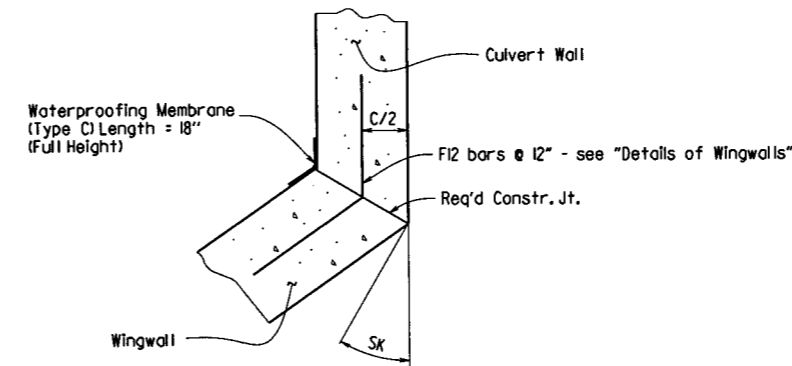


WINGWALL ATTACHMENT

See "Details of Wingwalls" for additional information and wingwall details.

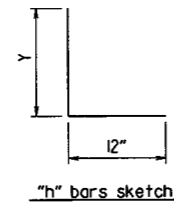


"h" bars sketch

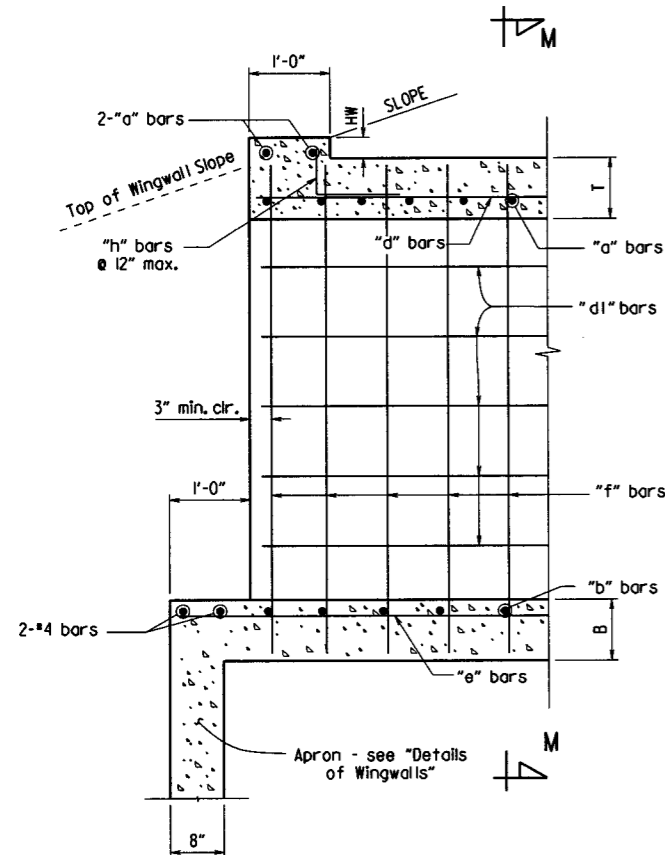


PART LONGITUDINAL SECTION

(Non-Skewed Ends)

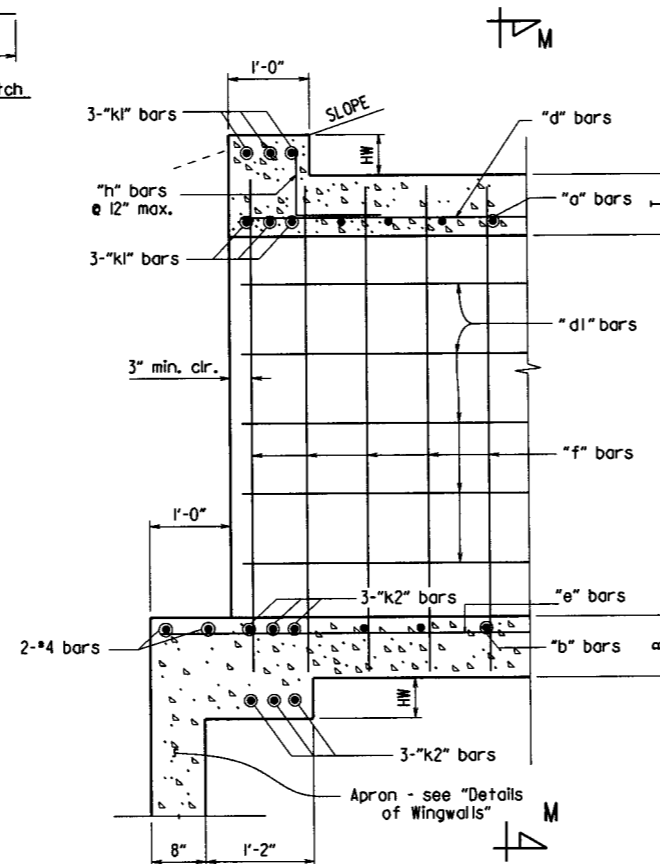


PART LONGITUDINAL SECTION N-N

(Skewed Ends)

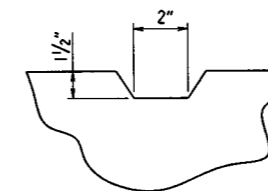

TYPICAL KEYWAY DETAIL

(All Construction Joints)

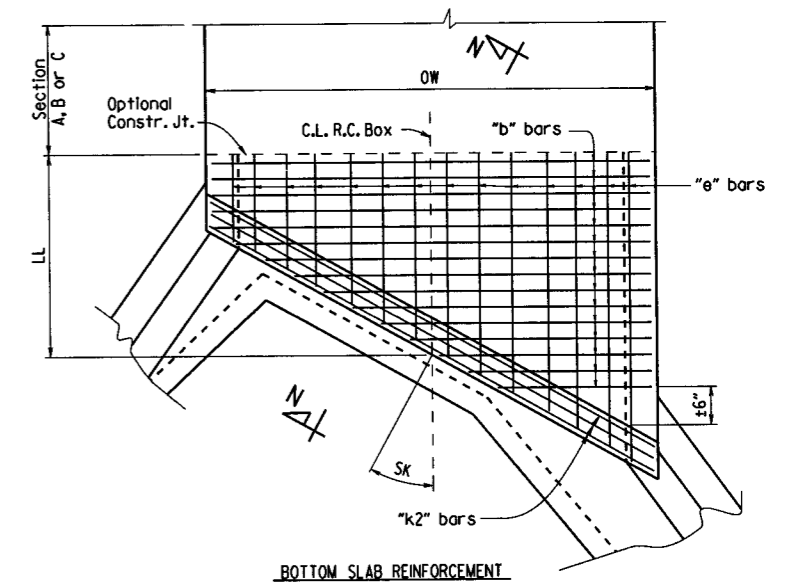

BOTTOM SLAB REINFORCEMENT

SKewed END SECTION DETAILS

SHEET 2 OF 4
GENERAL DETAILS OF R.C. BOX CULVERT
DETAILS OF SINGLE BARREL
R.C. BOX CULVERT

SPECIAL DETAILS




b090346_culvert.dgn

DATE REVISED	DATE FILMED	REVISED	DATE FILMED	FED. ROAD DIST. NO.	STATE	FED. AID PROJ. NO.	SHEET NO.	TOTAL SHEETS
				6	ARK.			
				JOB NO.	090346	12	56	

*2" clr. for fill depth (D) greater than 2 ft.
 2 1/2" clr. for fill depth (D) equal to or less than 2 ft.


Note: When top slab of culvert serves as finished roadway surface, see General Notes on Sheet 1 of 4.

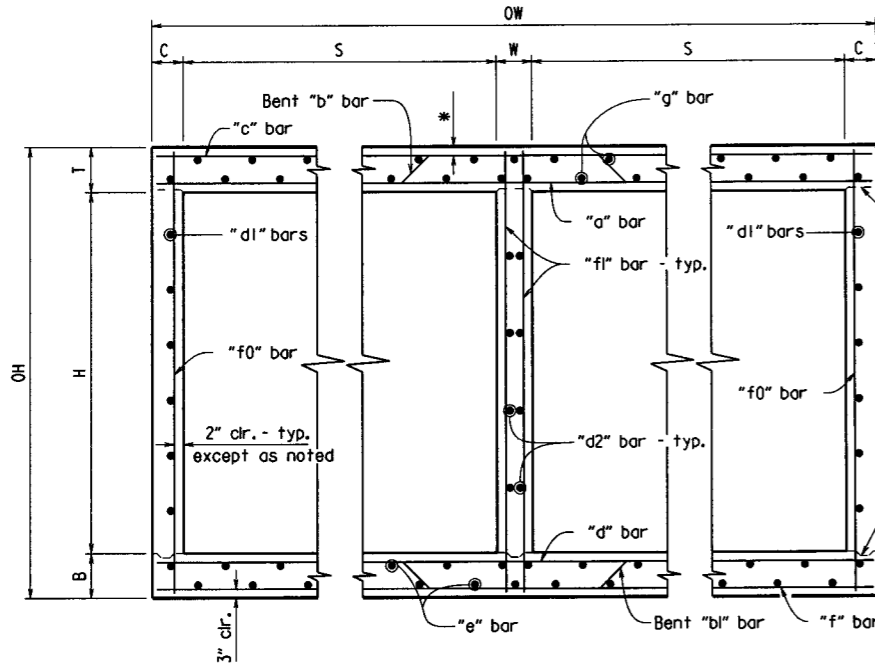


TYPICAL SECTION M-M

Top Slab
 Straight "c" bars shall alternate with Bent "b" bars in top.
 Straight "a" bars shall alternate with Bent "b" bars in bottom.


Bottom Slab
 Straight "d" bars shall alternate with Bent "bl" bars in top.
 Straight "f" bars shall alternate with Bent "bl" bars in bottom.

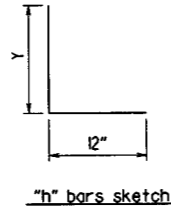


"h" bars sketch

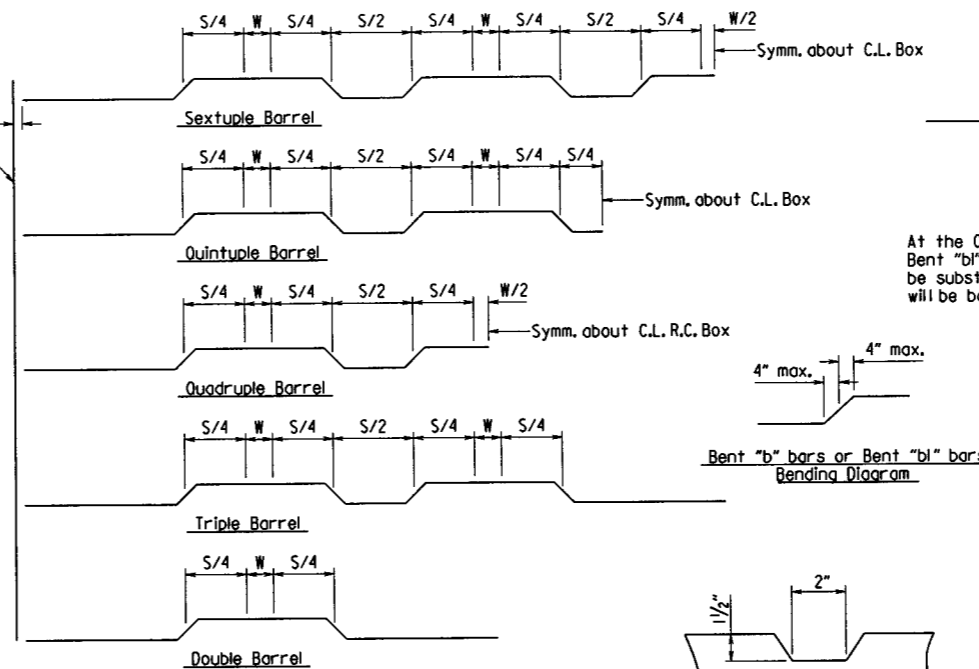



Bent "b" bars or Bent "bl" bars sketch

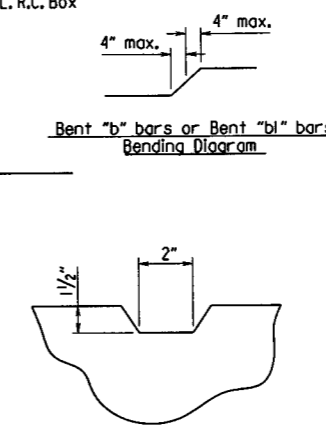


TYPICAL KEYWAY DETAIL
 (All Construction Joints)

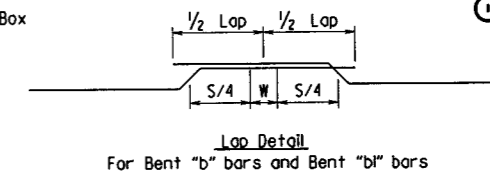

At the Contractor's option in lieu of providing Bent "b" or Bent "bl" bars, one bar top and bottom of equivalent size may be substituted for each bent bar. Payment for the reinforcing will be based on the weight of the "b" or "bl" bar.

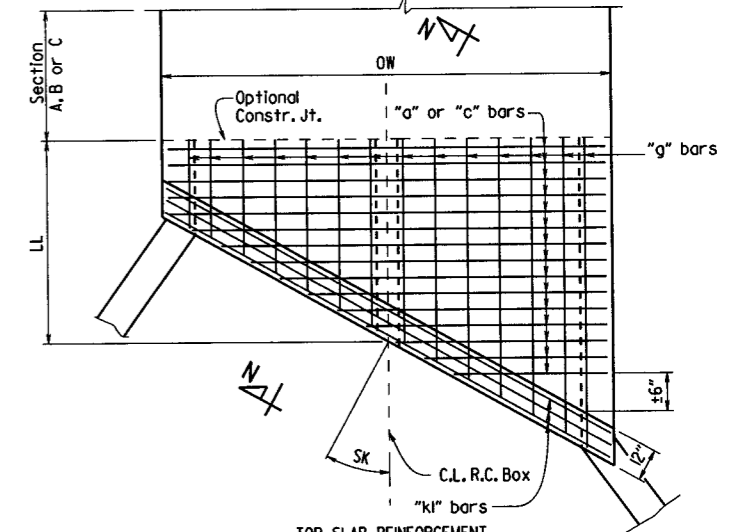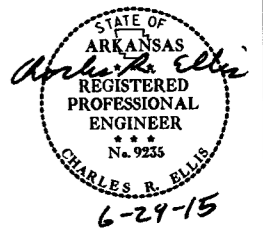

TOP SLAB REINFORCEMENT
 Straight "c" bars in top.
 Straight "a" bars in bottom.

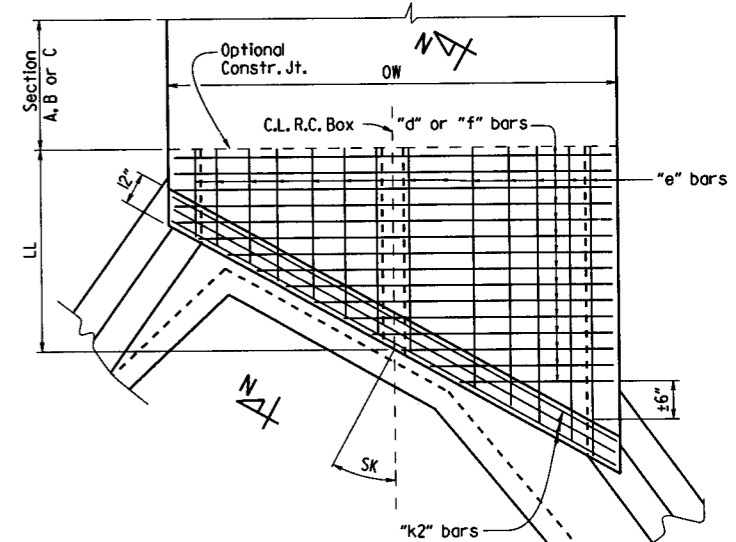


BOTTOM SLAB REINFORCEMENT
 Straight "d" bars in top.
 Straight "f" bars in bottom.

SKewed END SECTION DETAILS


SHEET 3 OF 4
GENERAL DETAILS OF R.C. BOX CULVERT

DETAILS OF MULTI-BARREL R.C. BOX CULVERT


SPECIAL DETAILS

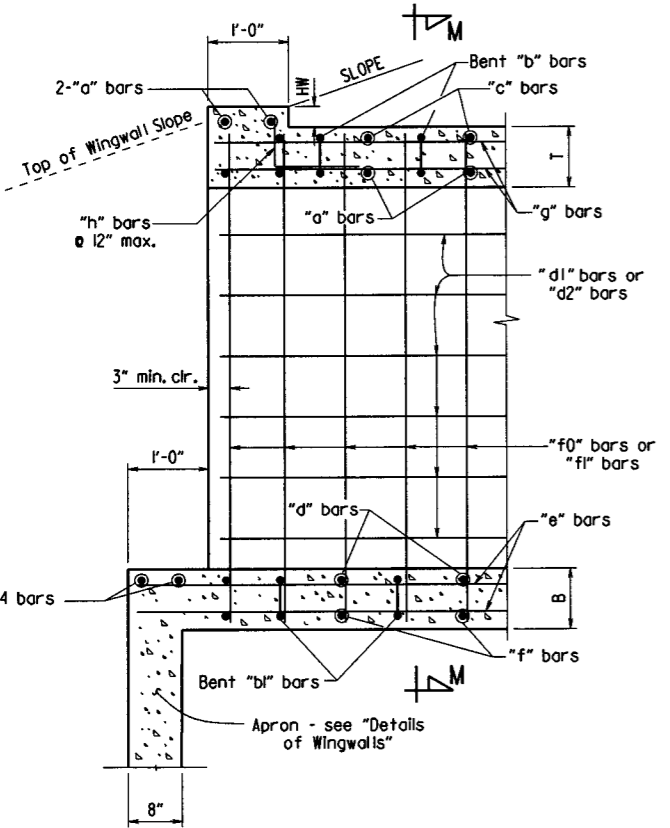


PART LONGITUDINAL SECTION
 (Non-Skewed Ends)

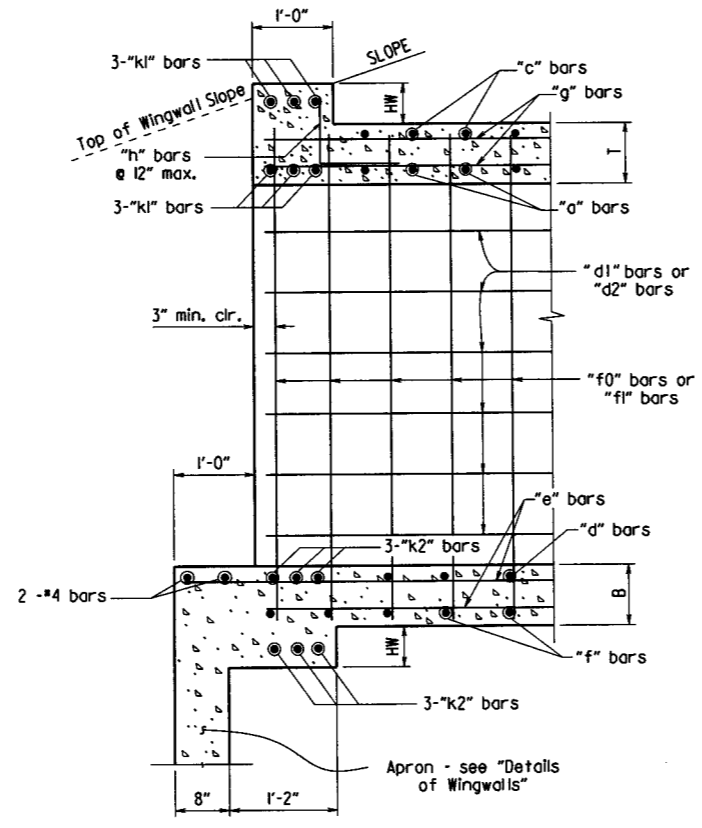

PART LONGITUDINAL SECTION N-N
 (Skewed Ends)

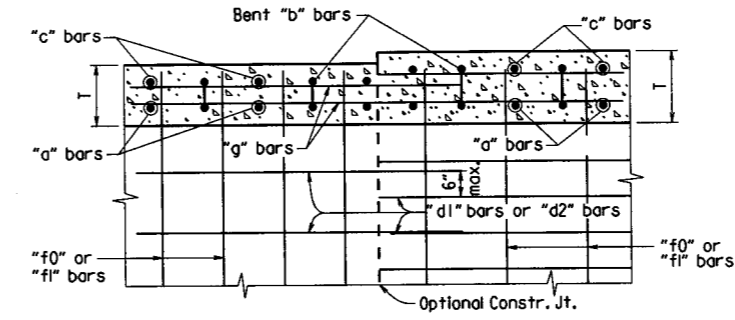

Longitudinal Bar Spacing at individual sections shall be maintained, which may result in noncontact bar laps.
LONGITUDINAL LAP DETAIL AT CHANGE IN SECTIONS
 TOP SLAB SHOWN, BOTTOM SLAB SIMILAR

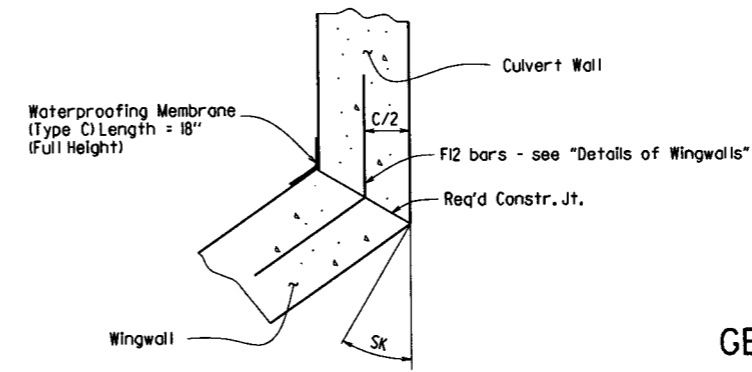


WINGWALL ATTACHMENT
 See "Details of Wingwalls" for additional information and wingwall details.

b090346_culvert.dgn

DATE REVISED	DATE FILMED	DATE REVISED	DATE FILMED	FED. ROAD DIST. NO.	STATE	FED. AID PROJ. NO.	SHEET NO.	TOTAL SHEETS
				6	ARK.			
				JOB NO.	090346	13	56	


SPECIAL DETAILS

STATE OF ARKANSAS
Charles R. Ellis
 REGISTERED PROFESSIONAL ENGINEER
 No. 9235
 6-29-15

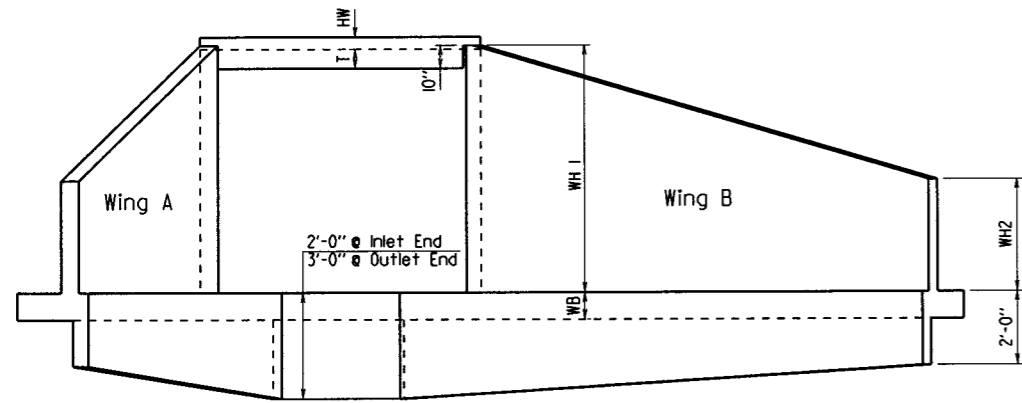

END ELEVATION


Flared Wingwalls Shown

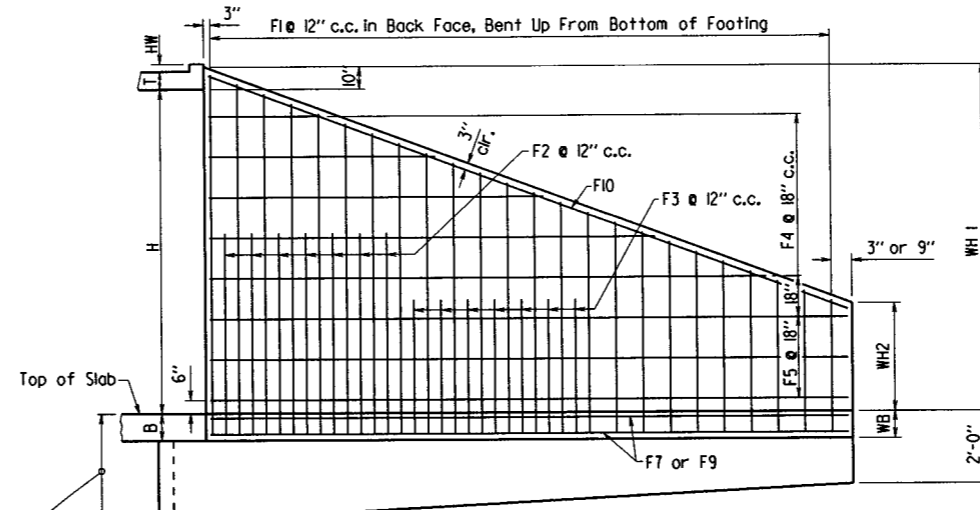

WINGWALL ELEVATION


Showing Back Face Reinforcement

Note: See "Wingwall Section P-P" for additional details and reinforcing.

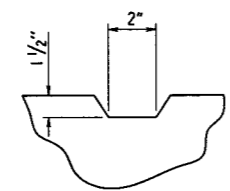


TYPICAL KEYWAY DETAIL

All Construction Joints

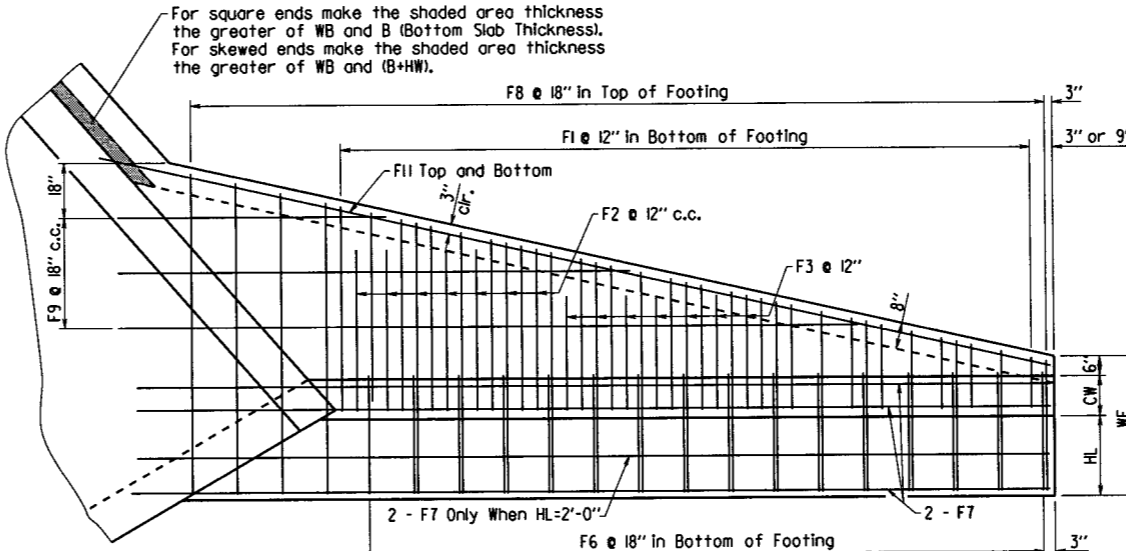


PLAN - FLARED WINGWALLS

Showing Footing Reinforcement

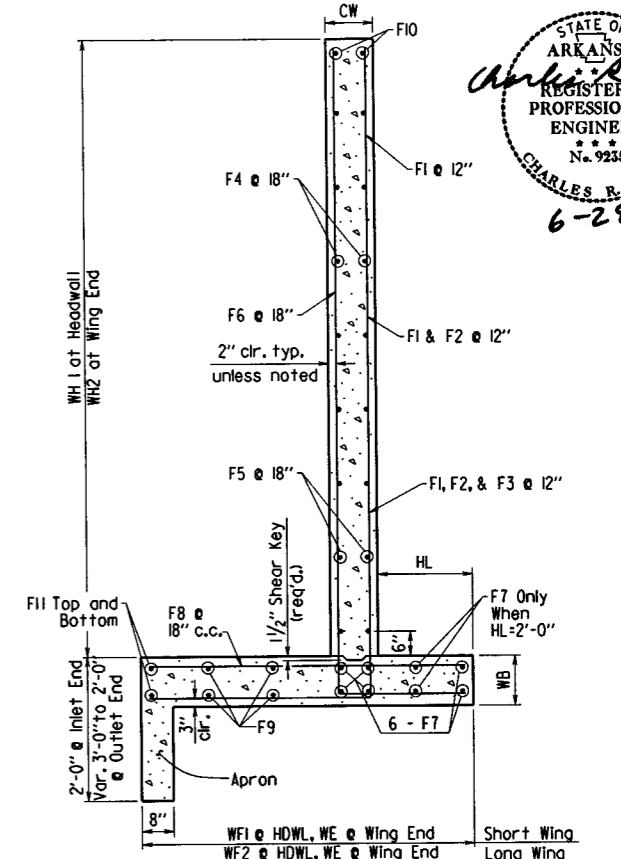


WINGWALL SECTION P-P

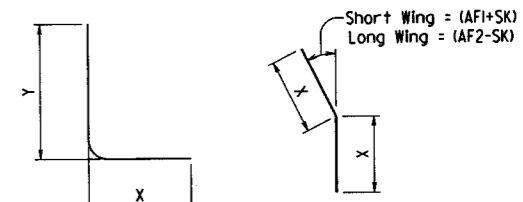


F1, F2, F3, & F6 BARS

***F12 BAR**

*F12 is a straight bar for parallel wingwalls

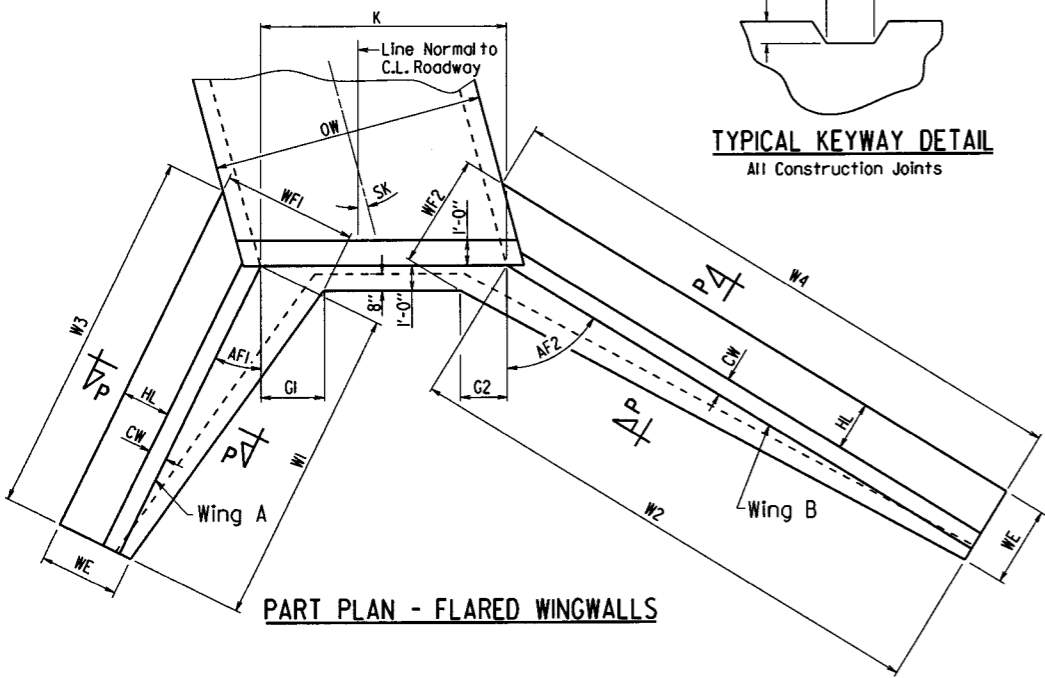


PART PLAN - FLARED WINGWALLS

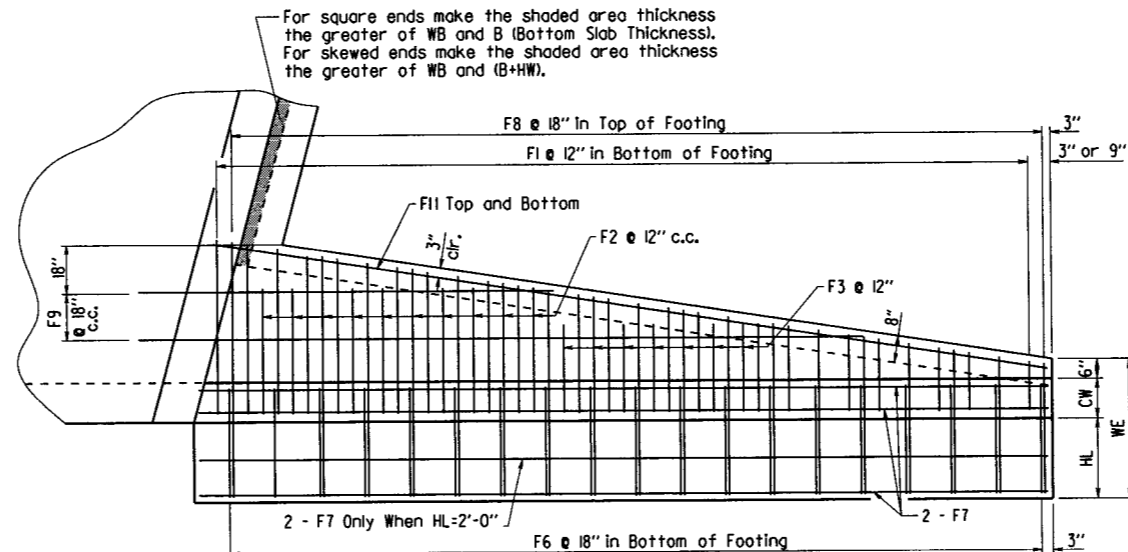

PLAN - PARALLEL WINGWALLS

Showing Footing Reinforcement

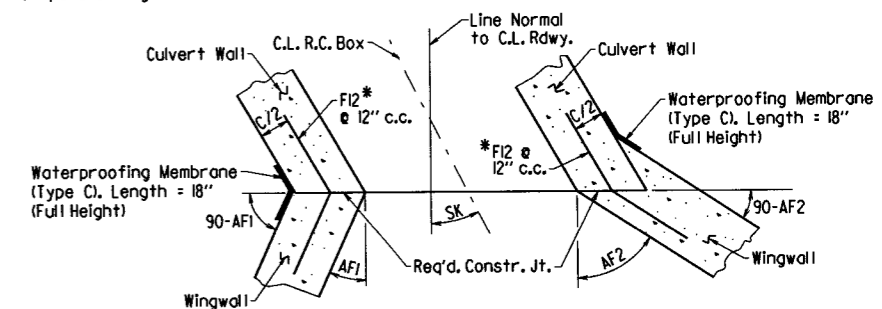

CONSTRUCTION JOINTS

Flared Wingwalls Shown


SHEET 4 OF 4
 GENERAL DETAILS OF R.C. BOX CULVERT
 DETAILS OF WINGWALLS
 SPECIAL DETAILS



b090346_culvert.dgn

DATE REVISED	DATE FILMED	DATE REVISED	DATE FILMED	FED. DIST. NO.	STATE	FED. PROJ. NO.	SHEET NO.	TOTAL SHEETS
				6	ARK.		14	56
				JOB NO. 090346				

2 TEMPORARY EROSION CONTROL DETAILS

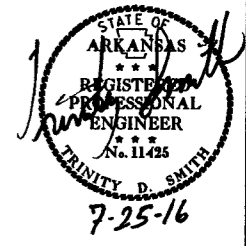


REVISIONS

DATE OF REVISION	REVISION

LEGEND


- (E-6) = ROCK DITCH CHECKS
- (E-11) = SILT FENCE

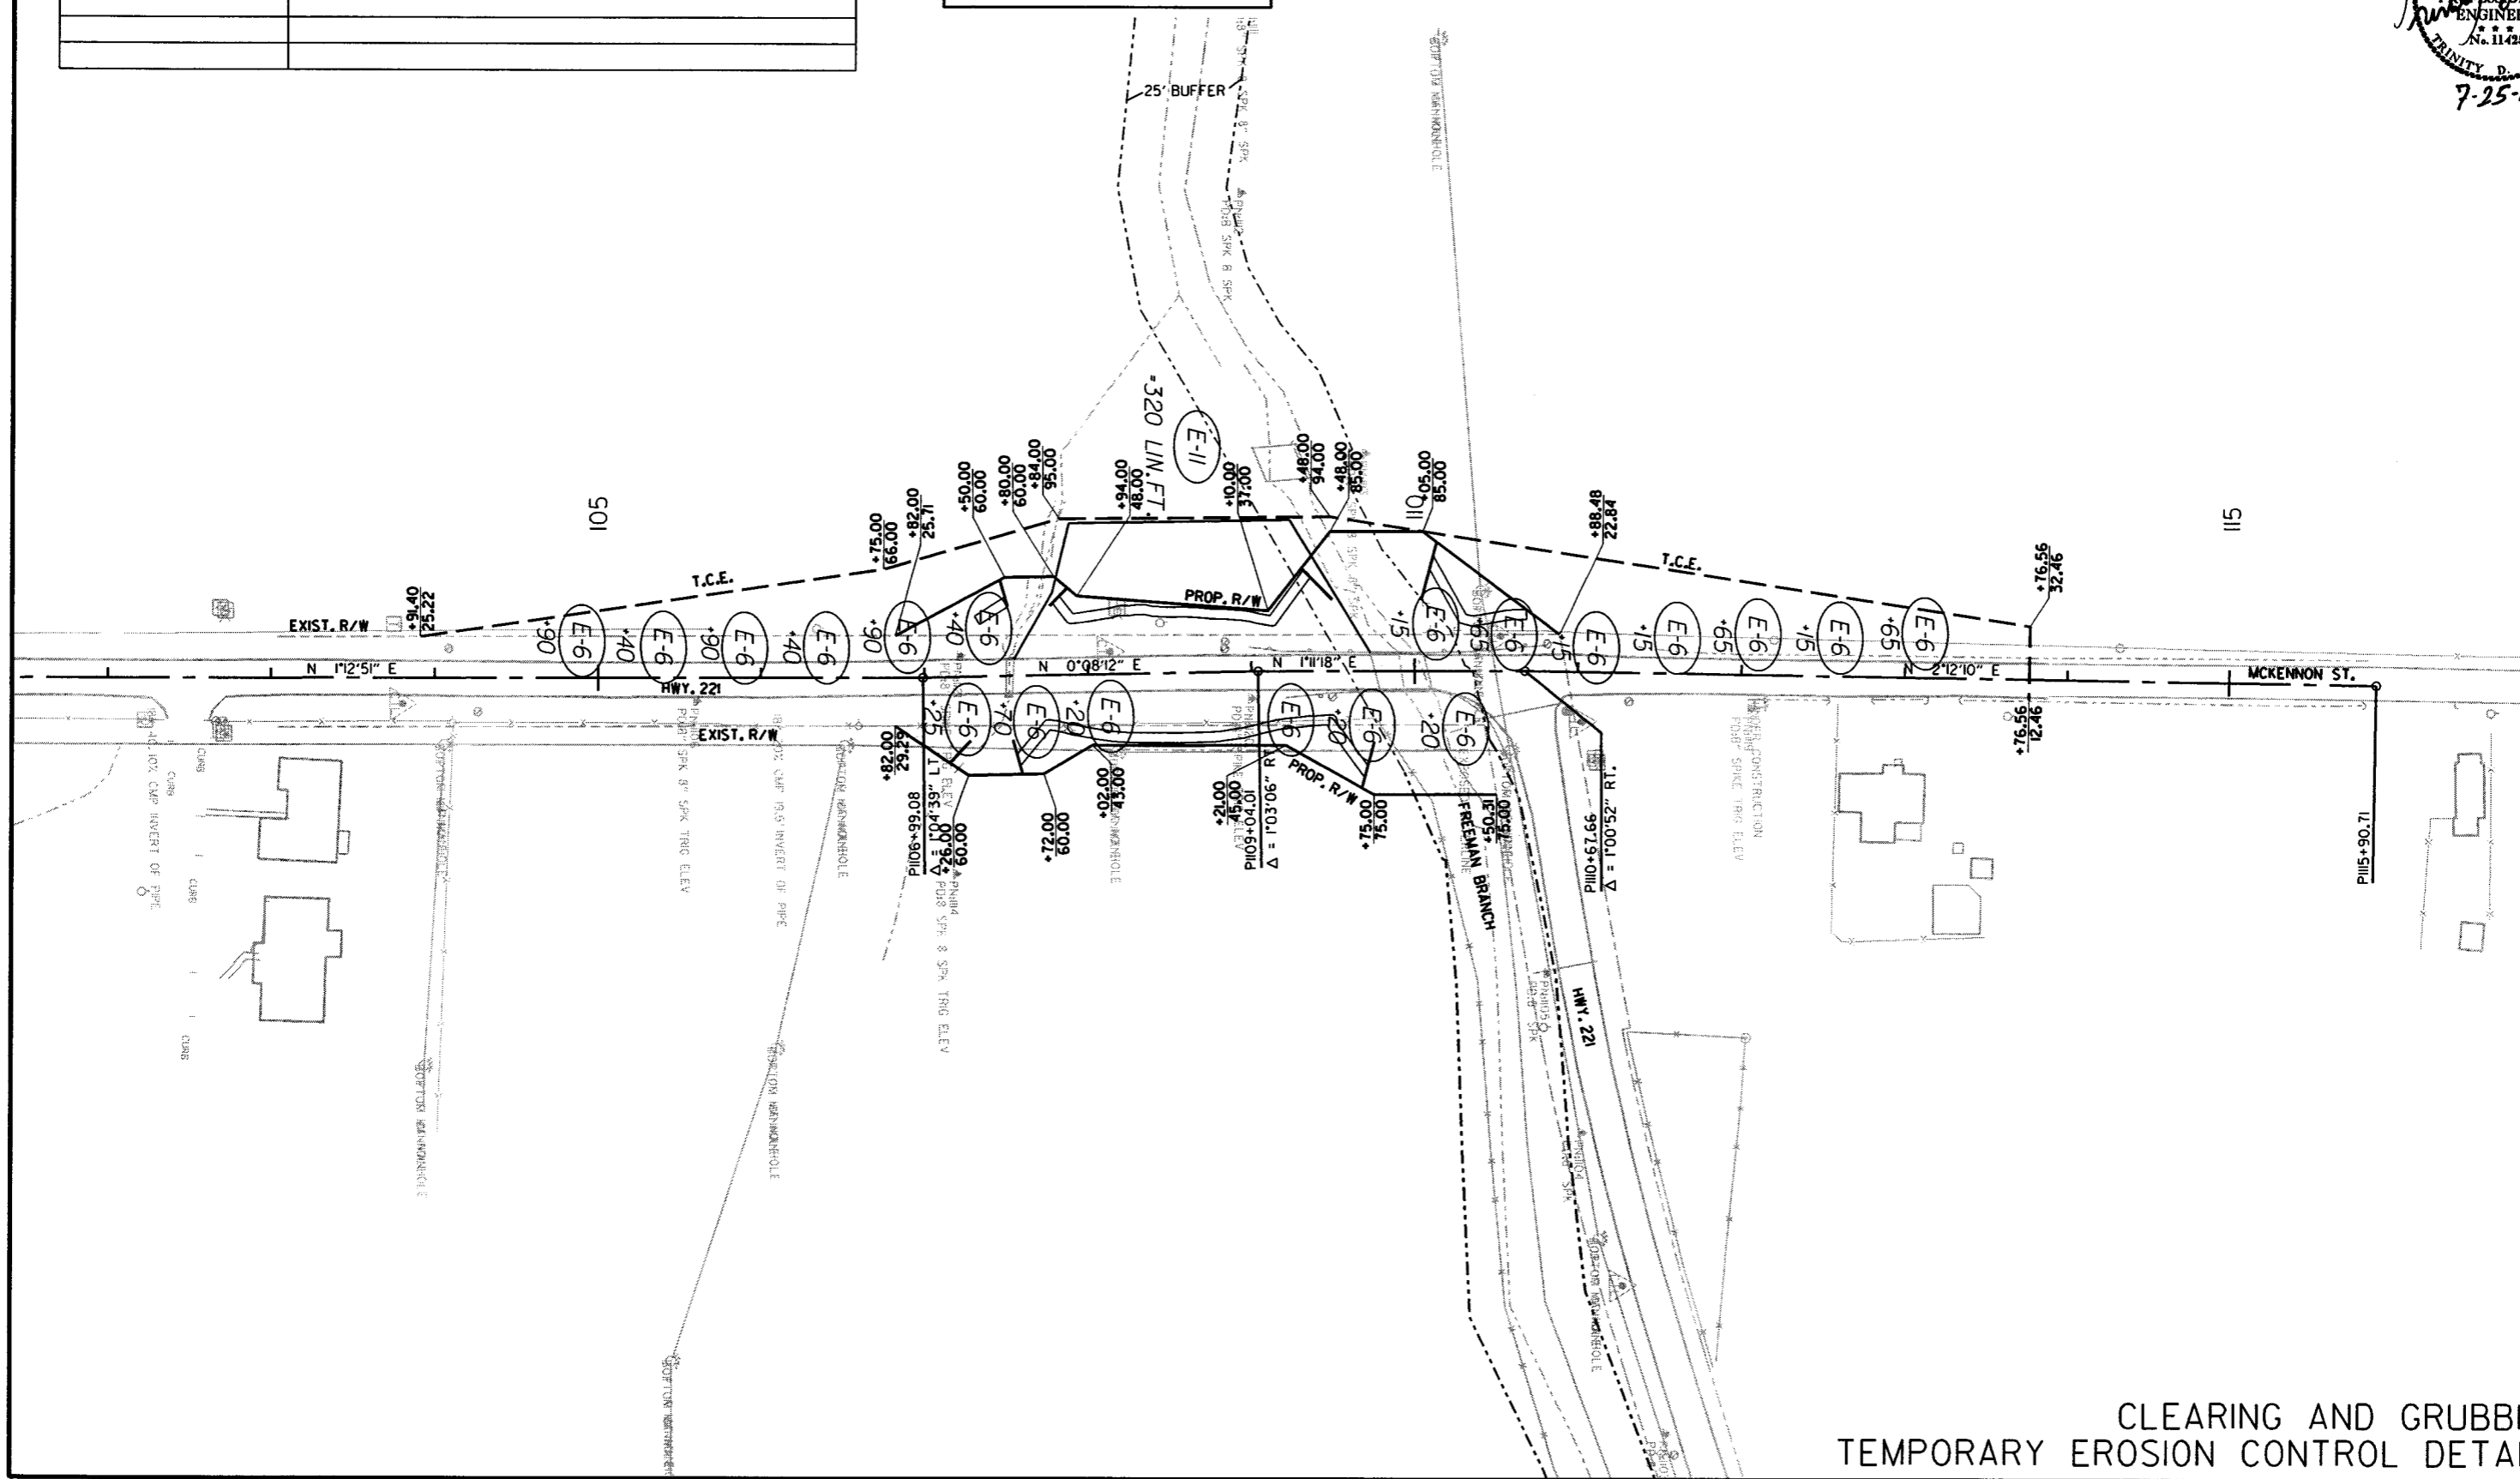

CLEARING AND GRUBBING
TEMPORARY EROSION CONTROL DETAILS

DATE REVISED	DATE FILMED	DATE REVISED	DATE FILMED	FED. RD. DIST. NO.	STATE	FED. AID PROJ. NO.	SHEET NO.	TOTAL SHEETS
				6	ARK.			
JOB NO. 090346							15	56

2 TEMPORARY EROSION CONTROL DETAILS

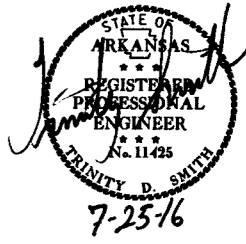


REVISIONS

DATE OF REVISION	REVISION

LEGEND

(E-6) = ROCK DITCH CHECKS

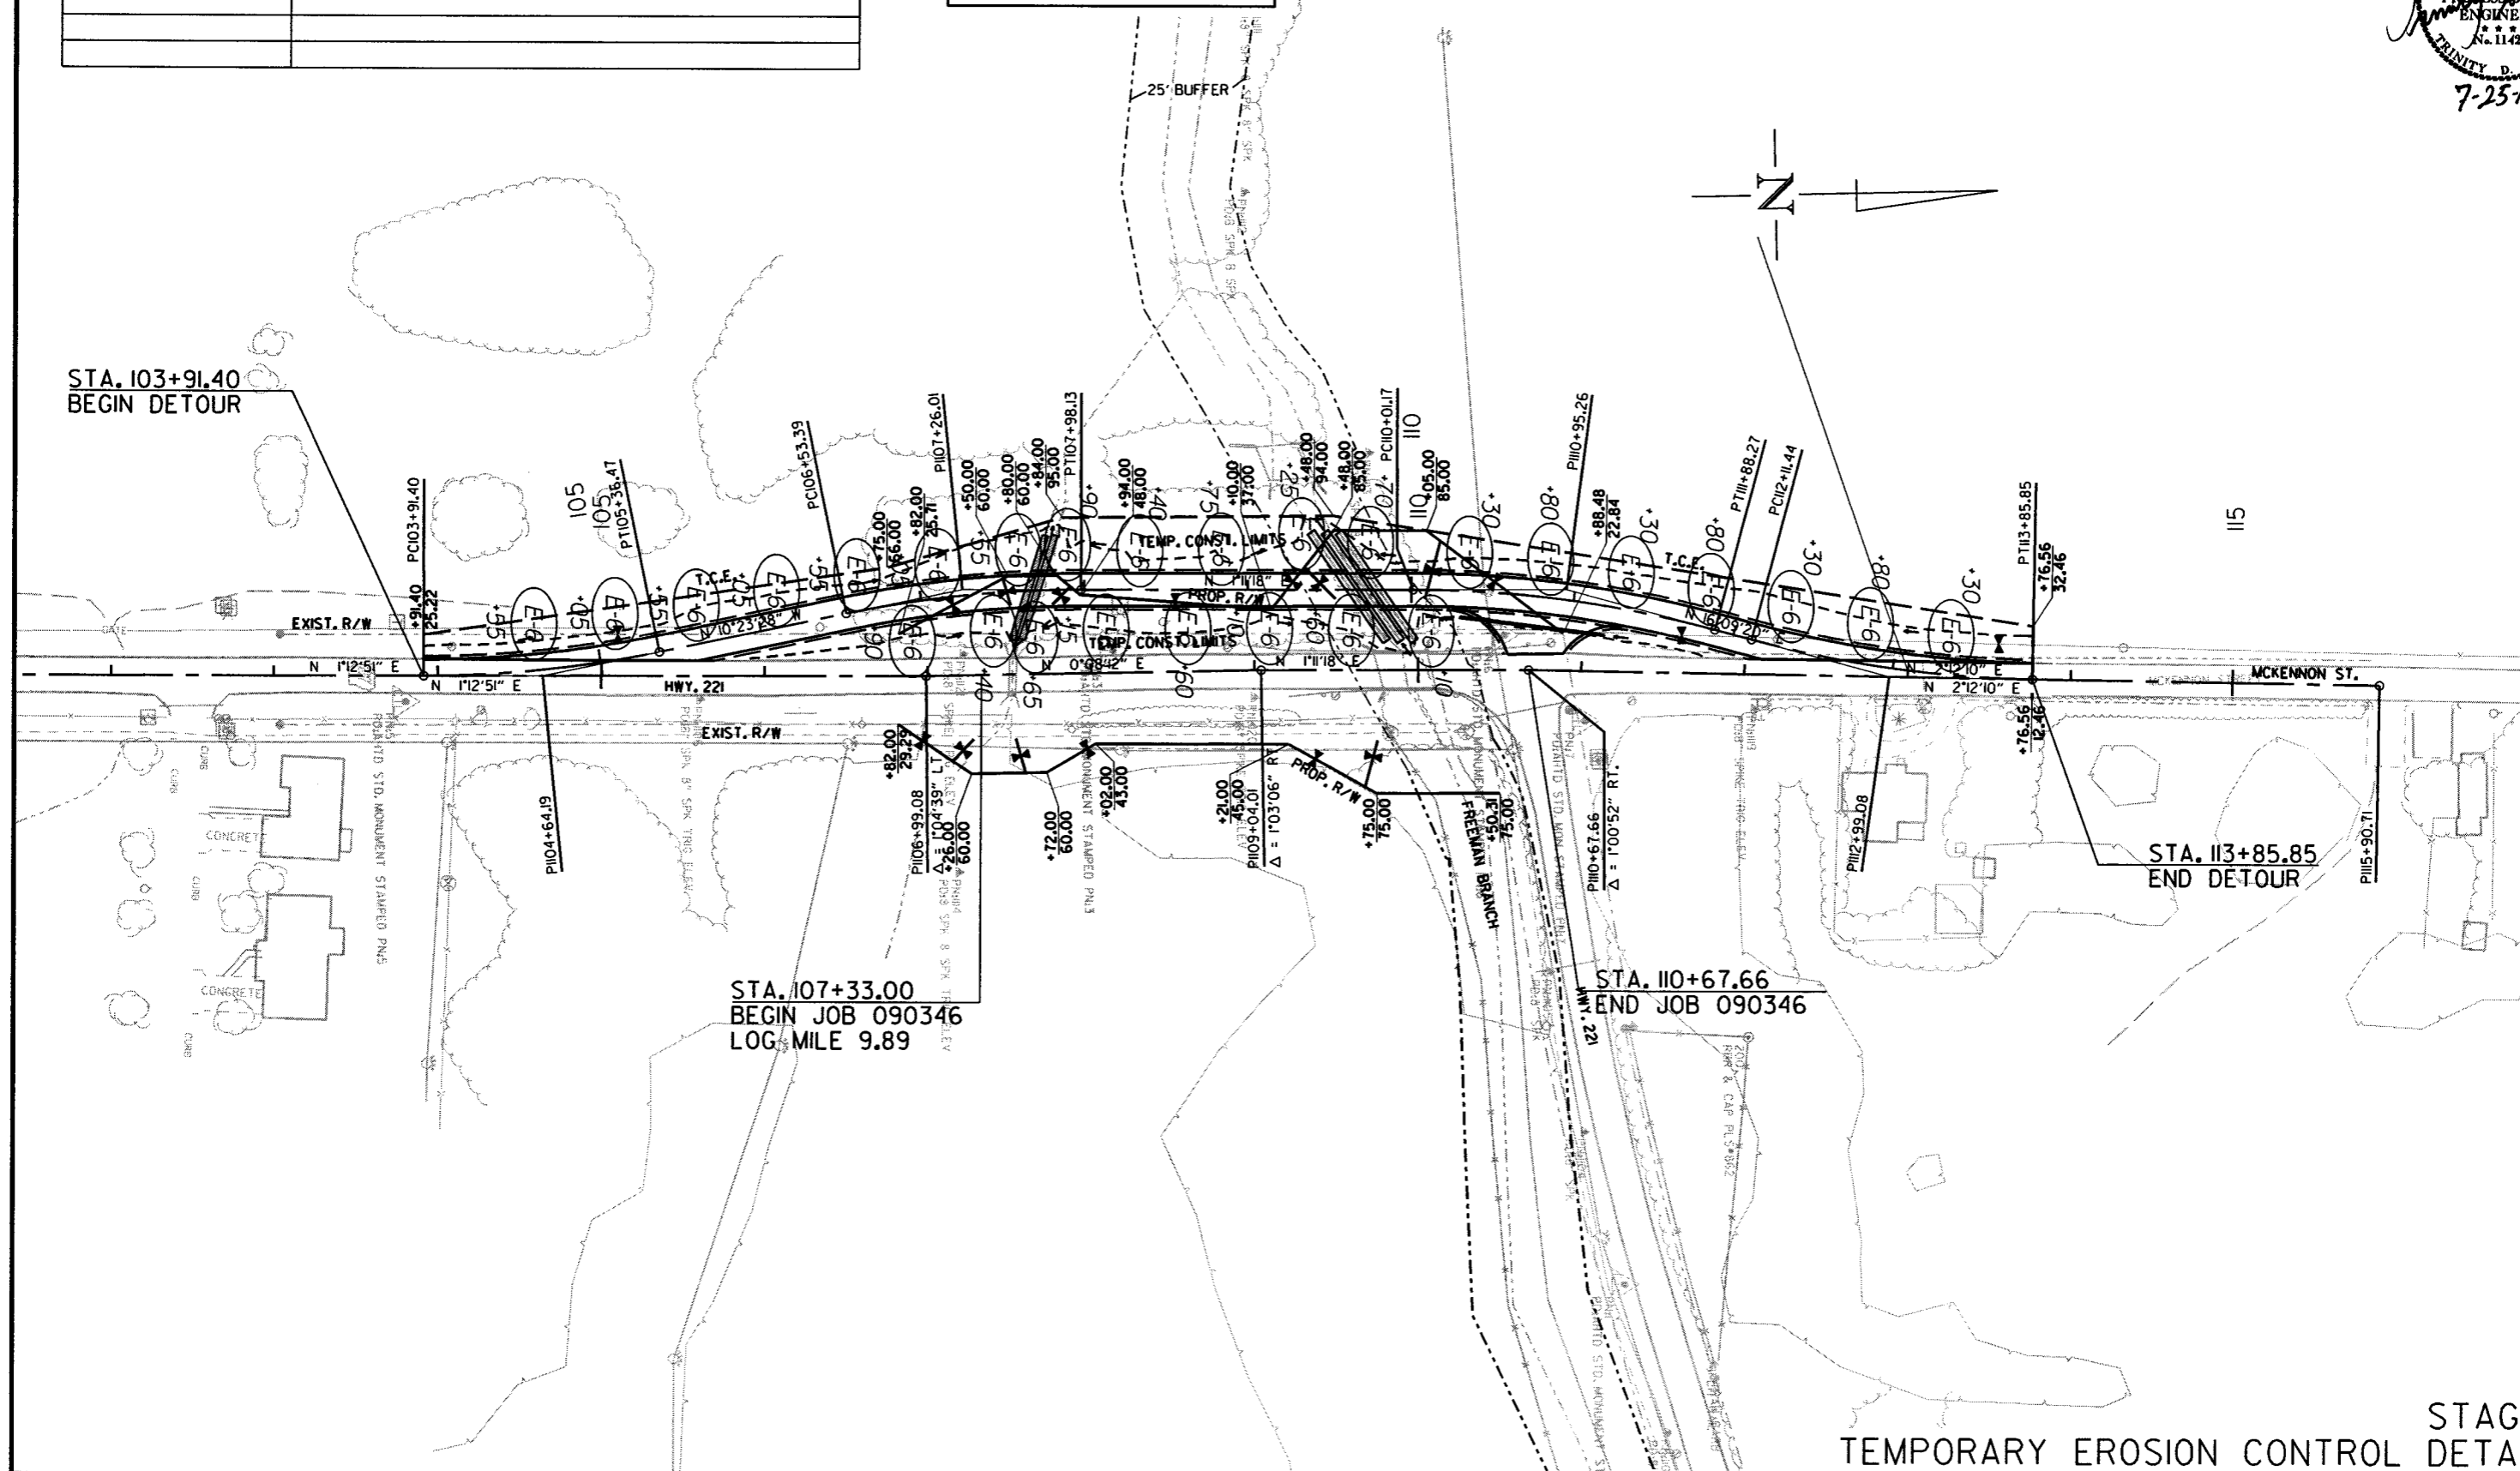

STA. 103+91.40
BEGIN DETOUR

STA. 107+33.00
BEGIN JOB 090346
LOG MILE 9.89

STA. 110+67.66
END JOB 090346

STA. 113+85.85
END DETOUR


STAGE I
TEMPORARY EROSION CONTROL DETAILS

7/21/2016

R090346.DGN

DATE REVISED	DATE FILMED	DATE REVISED	DATE FILMED	FED. RD. DIST. NO.	STATE	FED. AID PROJ. NO.	SHEET NO.	TOTAL SHEETS
				6	ARK.			
				JOB NO.	090346		16	56

② TEMPORARY EROSION CONTROL DETAILS


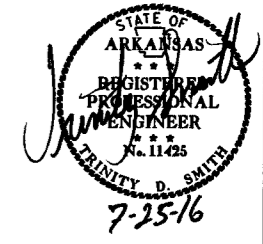


REVISIONS

DATE OF REVISION	REVISION

LEGEND

(E-6) = ROCK DITCH CHECKS

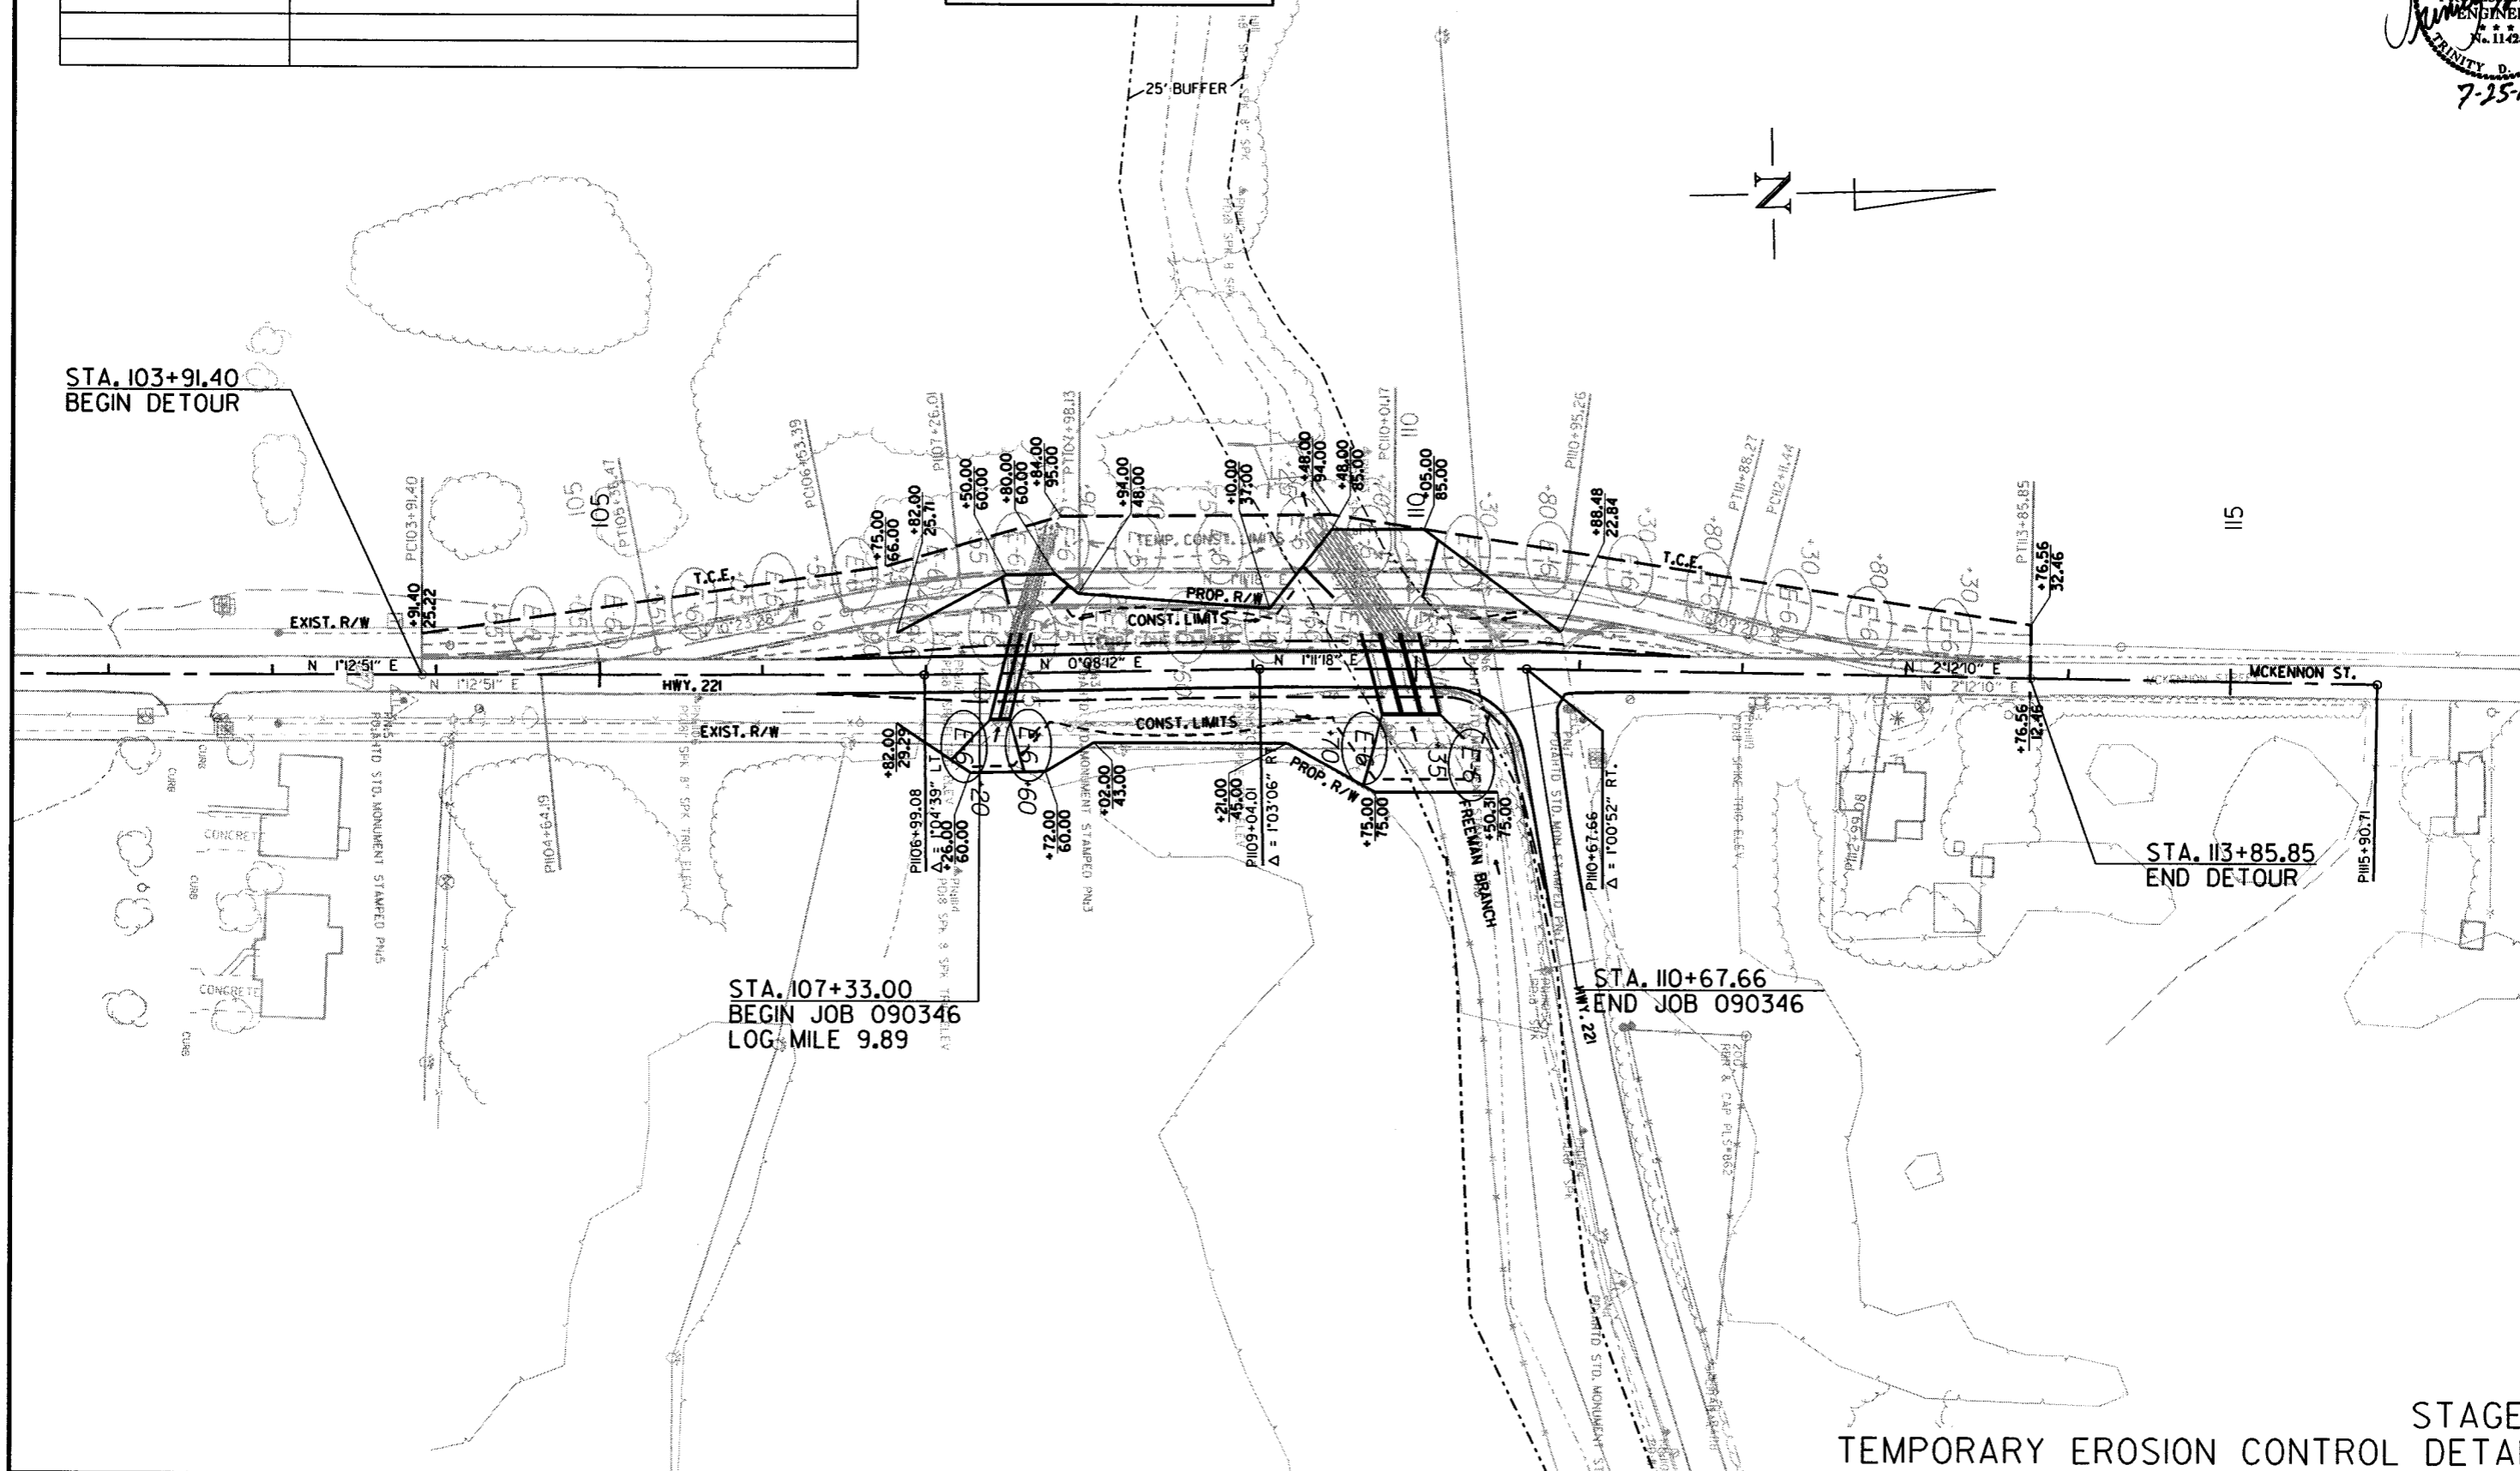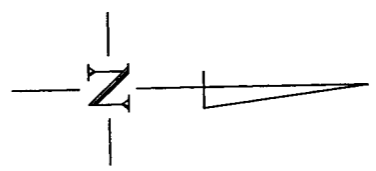

STA. 107+33.00
BEGIN JOB 090346
LOG MILE 9.89

STA. 110+67.66
END JOB 090346

STA. 113+85.85
END DETOUR


STAGE 2
TEMPORARY EROSION CONTROL DETAILS

7/21/2016

R090346.DCN

DATE REVISED	DATE FILMED	DATE REVISED	DATE FILMED	FED. RD. DIST. NO.	STATE	FED. AID PROJ. NO.	SHEET NO.	TOTAL SHEETS
				6	ARK.		17	56
				JOB NO. 090346				

② TEMPORARY EROSION CONTROL DETAILS


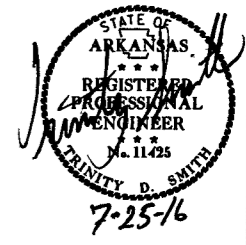


REVISIONS

DATE OF REVISION	REVISION

LEGEND

(E-6) = ROCK DITCH CHECKS

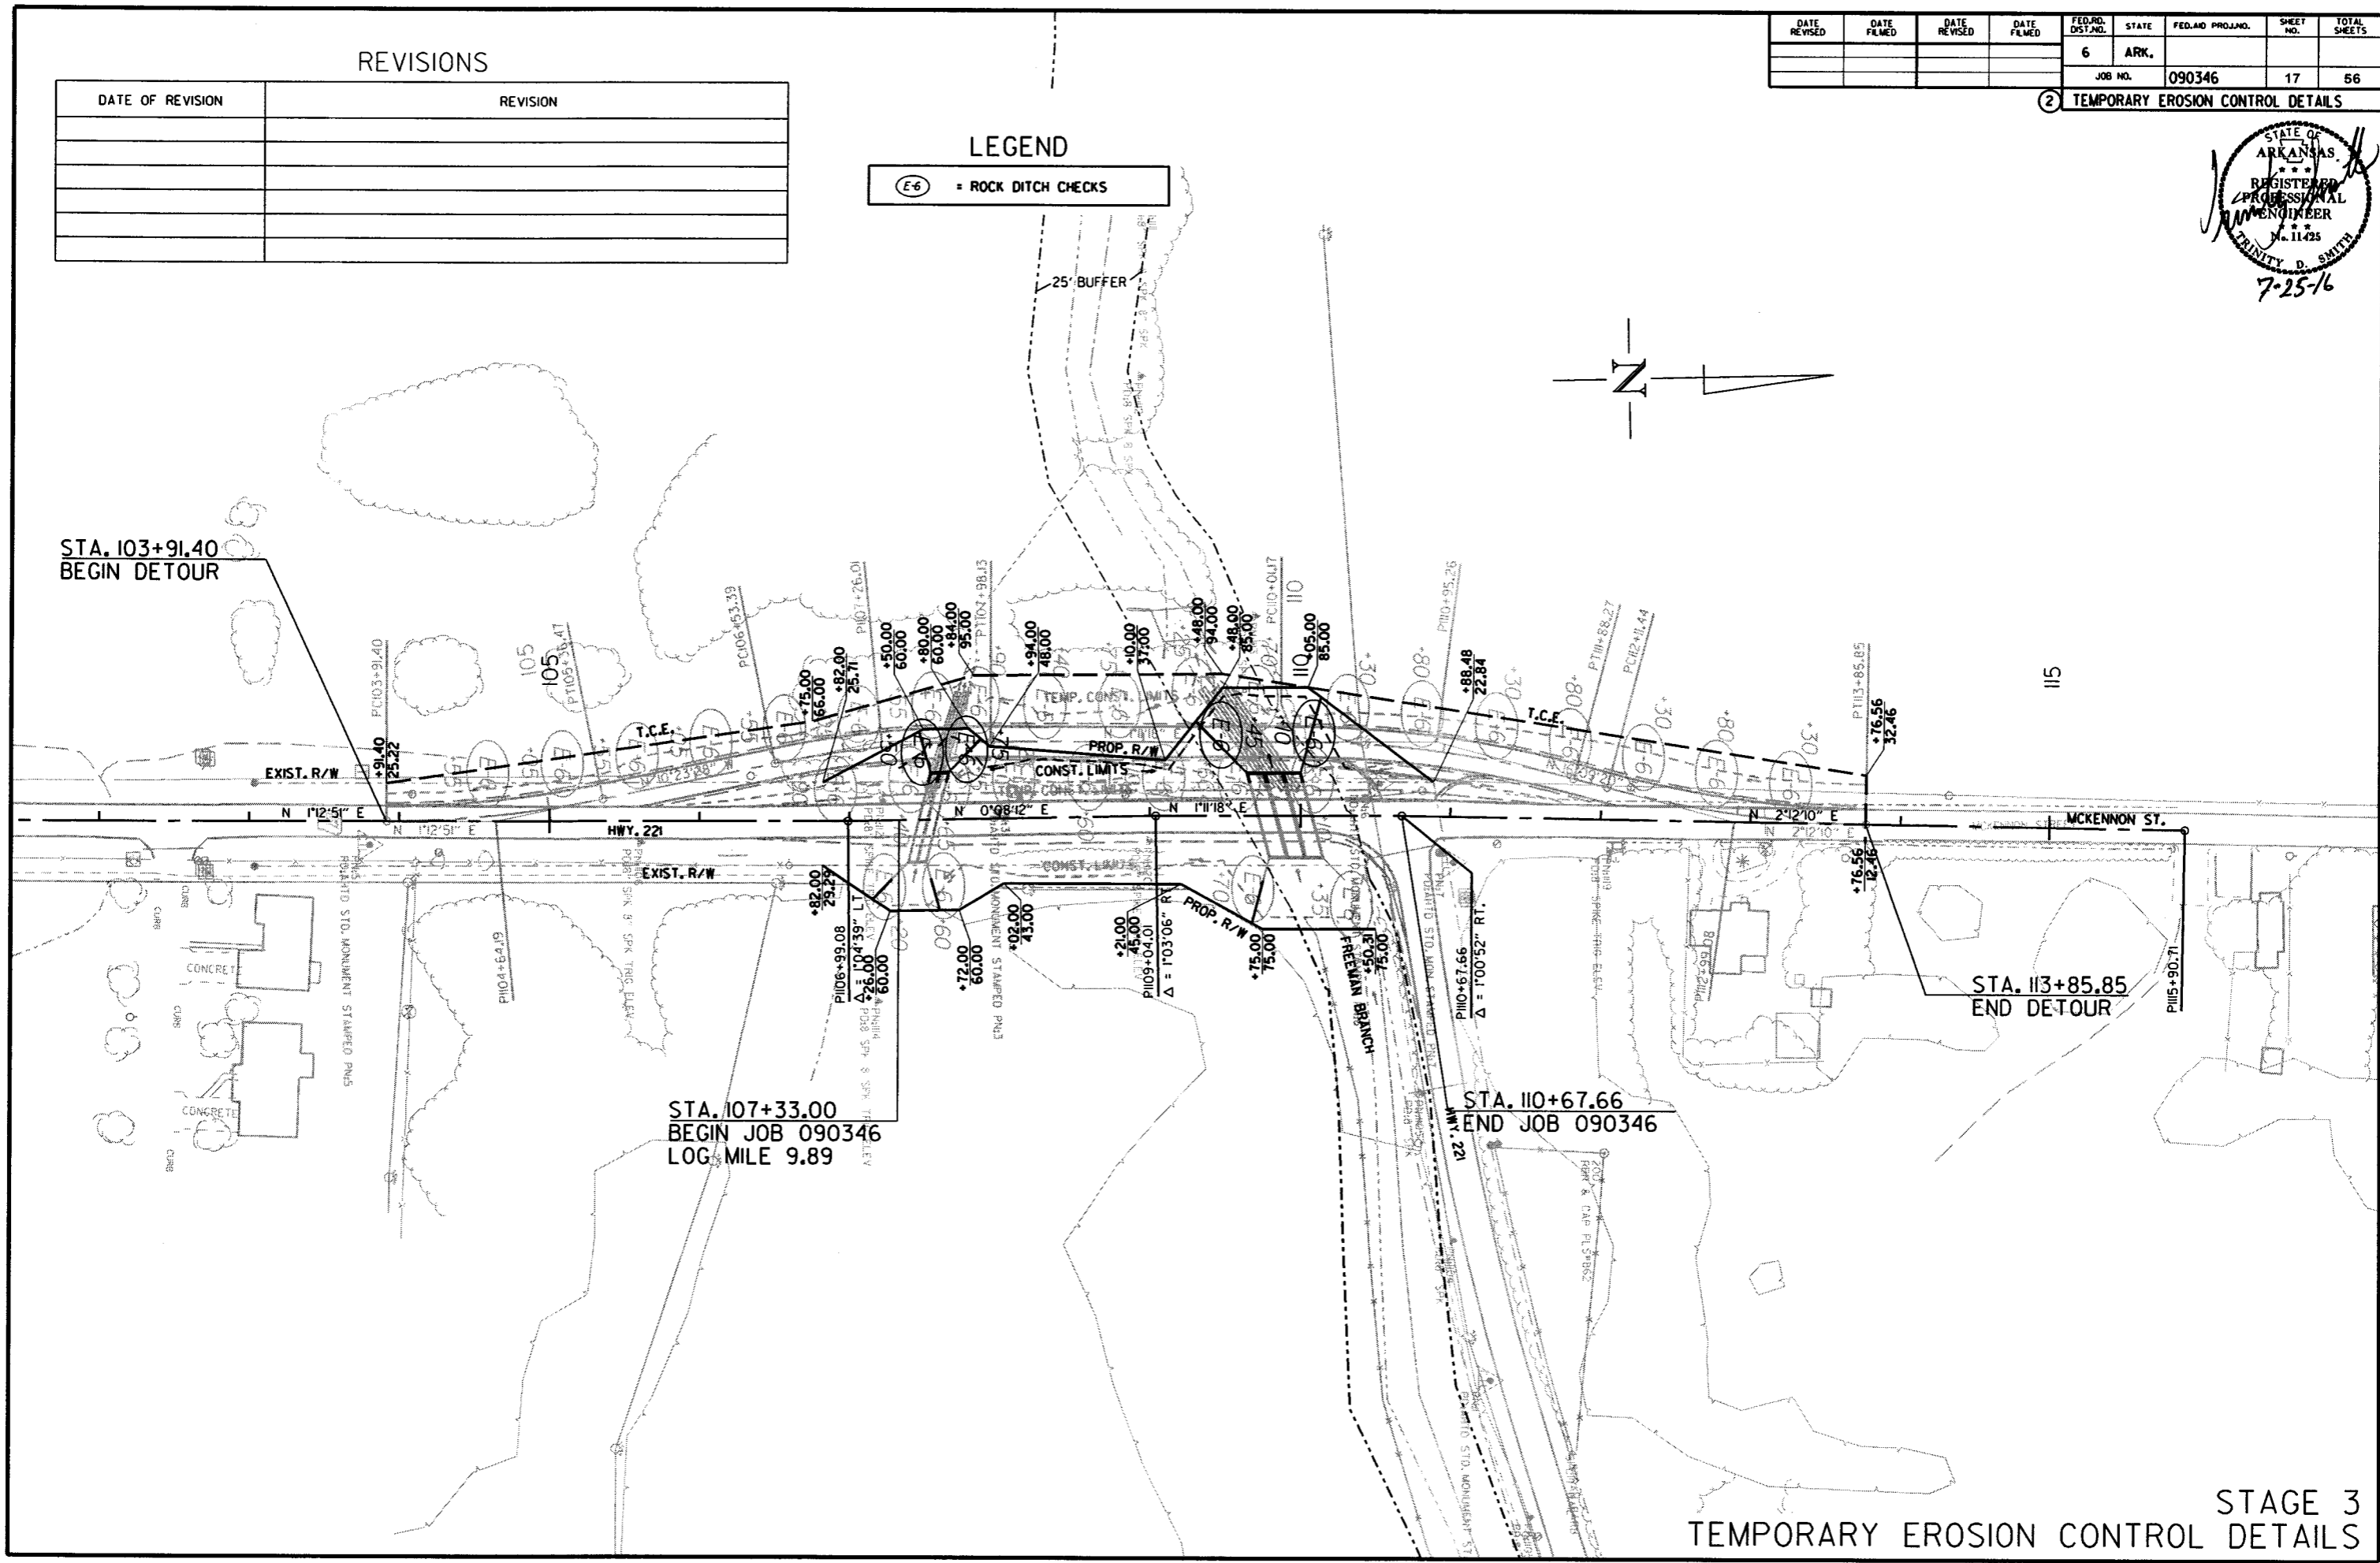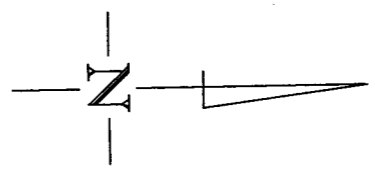

STA. 103+91.40
BEGIN DETOUR

STA. 107+33.00
BEGIN JOB 090346
LOG MILE 9.89

STA. 110+67.66
END JOB 090346

STA. 113+85.85
END DETOUR



7/21/2016

R090346.DCN





STAGE 3
TEMPORARY EROSION CONTROL DETAILS

DATE REVISED	DATE FILMED	DATE REVISED	DATE FILMED	FED. PROJ. NO.	STATE	FED. PROJ. NO.	SHEET NO.	TOTAL SHEETS
				6	ARK.			
				JOB NO.	090346		18	56

② MAINTENANCE OF TRAFFIC DETAILS

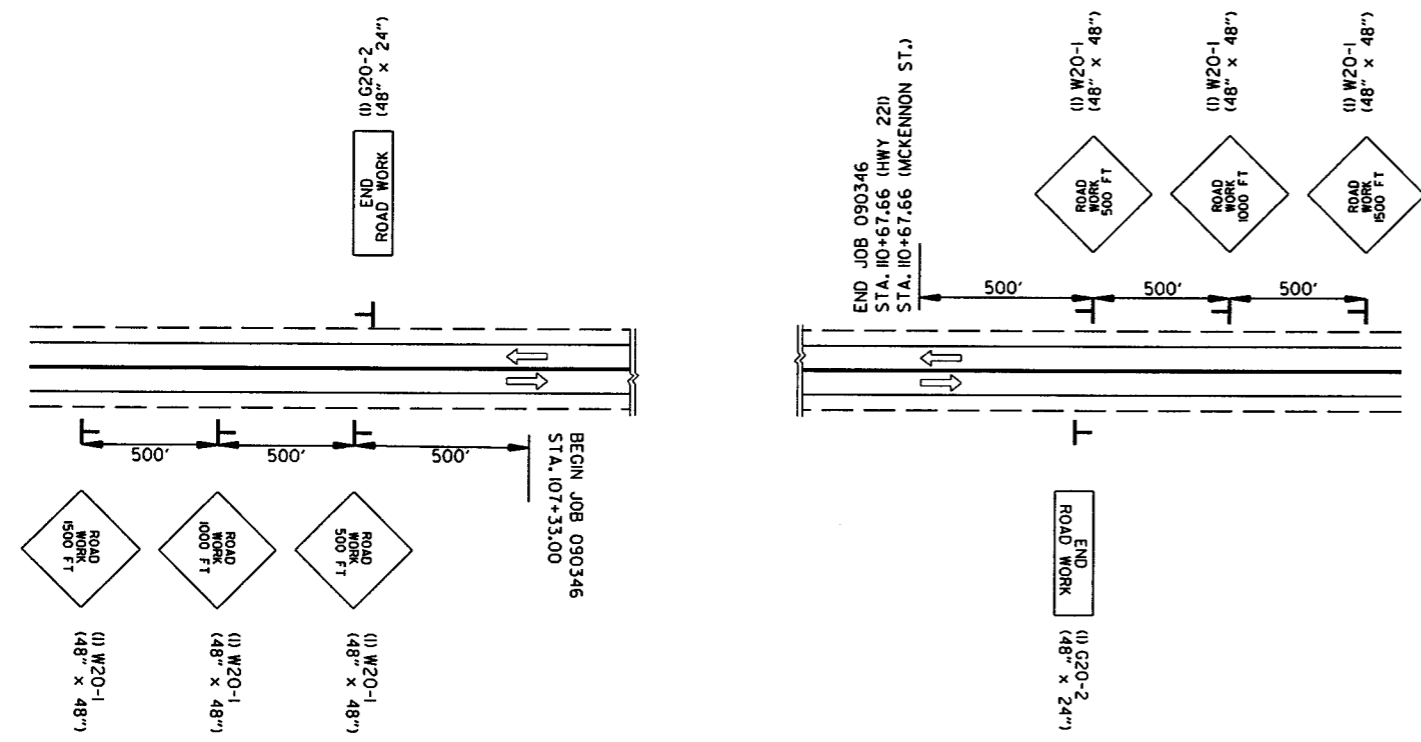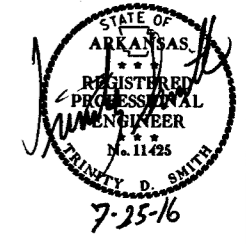

ADVANCE WARNING (ALL STAGES)

   -  (2) R2-1 (24" X 30")
ALL STAGES
 STA. 106+33.00 RT.
 STA. 113+67.66 LT.
-  (2) RSP-1 (48" X 30")
ALL STAGES
 TO BE USED IF AND WHERE DIRECTED BY THE ENGINEER
-  (2) R4-1 (24" X 30")
ALL STAGES
 TO BE USED IF AND WHERE DIRECTED BY THE ENGINEER
-  (2) W8-1 (30" X 30")
STAGE 1 AND 2
 TO BE USED IF AND WHERE DIRECTED BY THE ENGINEER

STAGE 1 CONSTRUCTION SEQUENCE

INSTALL ADVANCE WARNING SIGNS AND END ROAD WORK SIGNS AS SHOWN IN THE ADVANCE WARNING MAINTENANCE OF TRAFFIC DETAILS. INSTALL ROAD WORK AHEAD (W20-1) SIGN AS SHOWN IN THE STAGE 1 MAINTENANCE OF TRAFFIC DETAILS.

CONSTRUCT PROPOSED DETOUR AS SHOWN IN THE STAGE 1 MAINTENANCE OF TRAFFIC DETAILS.

USE VERTICAL PANELS AND TRAFFIC DRUMS SPACED 40' ON CENTER TO DELINEATE THE WORK ZONE.

INSTALL TYPE III BARRICADES WITH ROAD CLOSED (R11-2) SIGNS AS SHOWN IN THE STAGE 1 MAINTENANCE OF TRAFFIC PLANS AS PROPOSED ROADWAY EMBANKMENT IS CONSTRUCTED.

STAGE 2 CONSTRUCTION SEQUENCE

APPLY CONSTRUCTION PAVEMENT MARKINGS AS SHOWN IN THE STAGE 2 MAINTENANCE OF TRAFFIC DETAILS AND SHIFT TRAFFIC ONTO THE PROPOSED DETOUR CONSTRUCTED IN STAGE 1.

INSTALL TYPE III BARRICADES WITH ROAD CLOSED (R11-2) SIGNS AS SHOWN IN THE STAGE 2 MAINTENANCE OF TRAFFIC PLANS AS PROPOSED ROADWAY EMBANKMENT IS CONSTRUCTED.

USE TRAFFIC DRUMS SPACED 40' ON CENTER TO DELINEATE THE WORK ZONE.

REMOVE EXISTING CROSS DRAIN, BRIDGE, AND PAVEMENT AS SHOWN IN THE STAGE 2 MAINTENANCE OF TRAFFIC DETAILS.

CONSTRUCT PROPOSED ROADWAY AND PORTIONS OF PROPOSED R.C. BOX CULVERTS AS SHOWN IN THE STAGE 2 MAINTENANCE OF TRAFFIC DETAILS.

STAGE 3 CONSTRUCTION SEQUENCE

APPLY CONSTRUCTION PAVEMENT MARKINGS AS SHOWN IN THE STAGE 3 MAINTENANCE OF TRAFFIC DETAILS AND SHIFT TRAFFIC ONTO THE PROPOSED ROADWAY CONSTRUCTED IN STAGE 2.

INSTALL TYPE III BARRICADES WITH ROAD CLOSED (R11-2) SIGNS AS SHOWN IN THE STAGE 3 MAINTENANCE OF TRAFFIC PLANS AS PROPOSED ROADWAY EMBANKMENT IS CONSTRUCTED.

USE VERTICAL PANELS AND TRAFFIC DRUMS SPACED 40' ON CENTER TO DELINEATE THE WORK ZONE.

REMOVE PROPOSED DETOUR.

CONSTRUCT FINAL PORTIONS OF PROPOSED R.C. BOX CULVERTS AND EMBANKMENTS AS SHOWN IN THE STAGE 3 MAINTENANCE OF TRAFFIC DETAILS.

INSTALL PERMANENT PAVEMENT MARKINGS AS SHOWN IN THE PERMANENT PAVEMENT MARKINGS DETAILS.

7/21/2016




R090346.DGN

STAGE I QUANTITIES

SIGNS = 256.5 SQ. FT.
 VERTICAL PANELS = 12 EACH
 TRAFFIC DRUMS = 10 EACH
 TYPE III BARRICADE = 64 LIN. FT.
 FURNISH AND INSTALL P.C.C.B. = 160 LIN. FT.
 T.I.A.B. = 1 EACH
 T.I.A.B. (REPAIR) = 1 EACH

DATE REVISED	DATE FILMED	DATE REVISED	DATE FILMED	FED. RD. DIST. NO.	STATE	FED. AID PROJ. NO.	SHEET NO.	TOTAL SHEETS
				6	ARK.		19	56

② MAINTENANCE OF TRAFFIC DETAILS

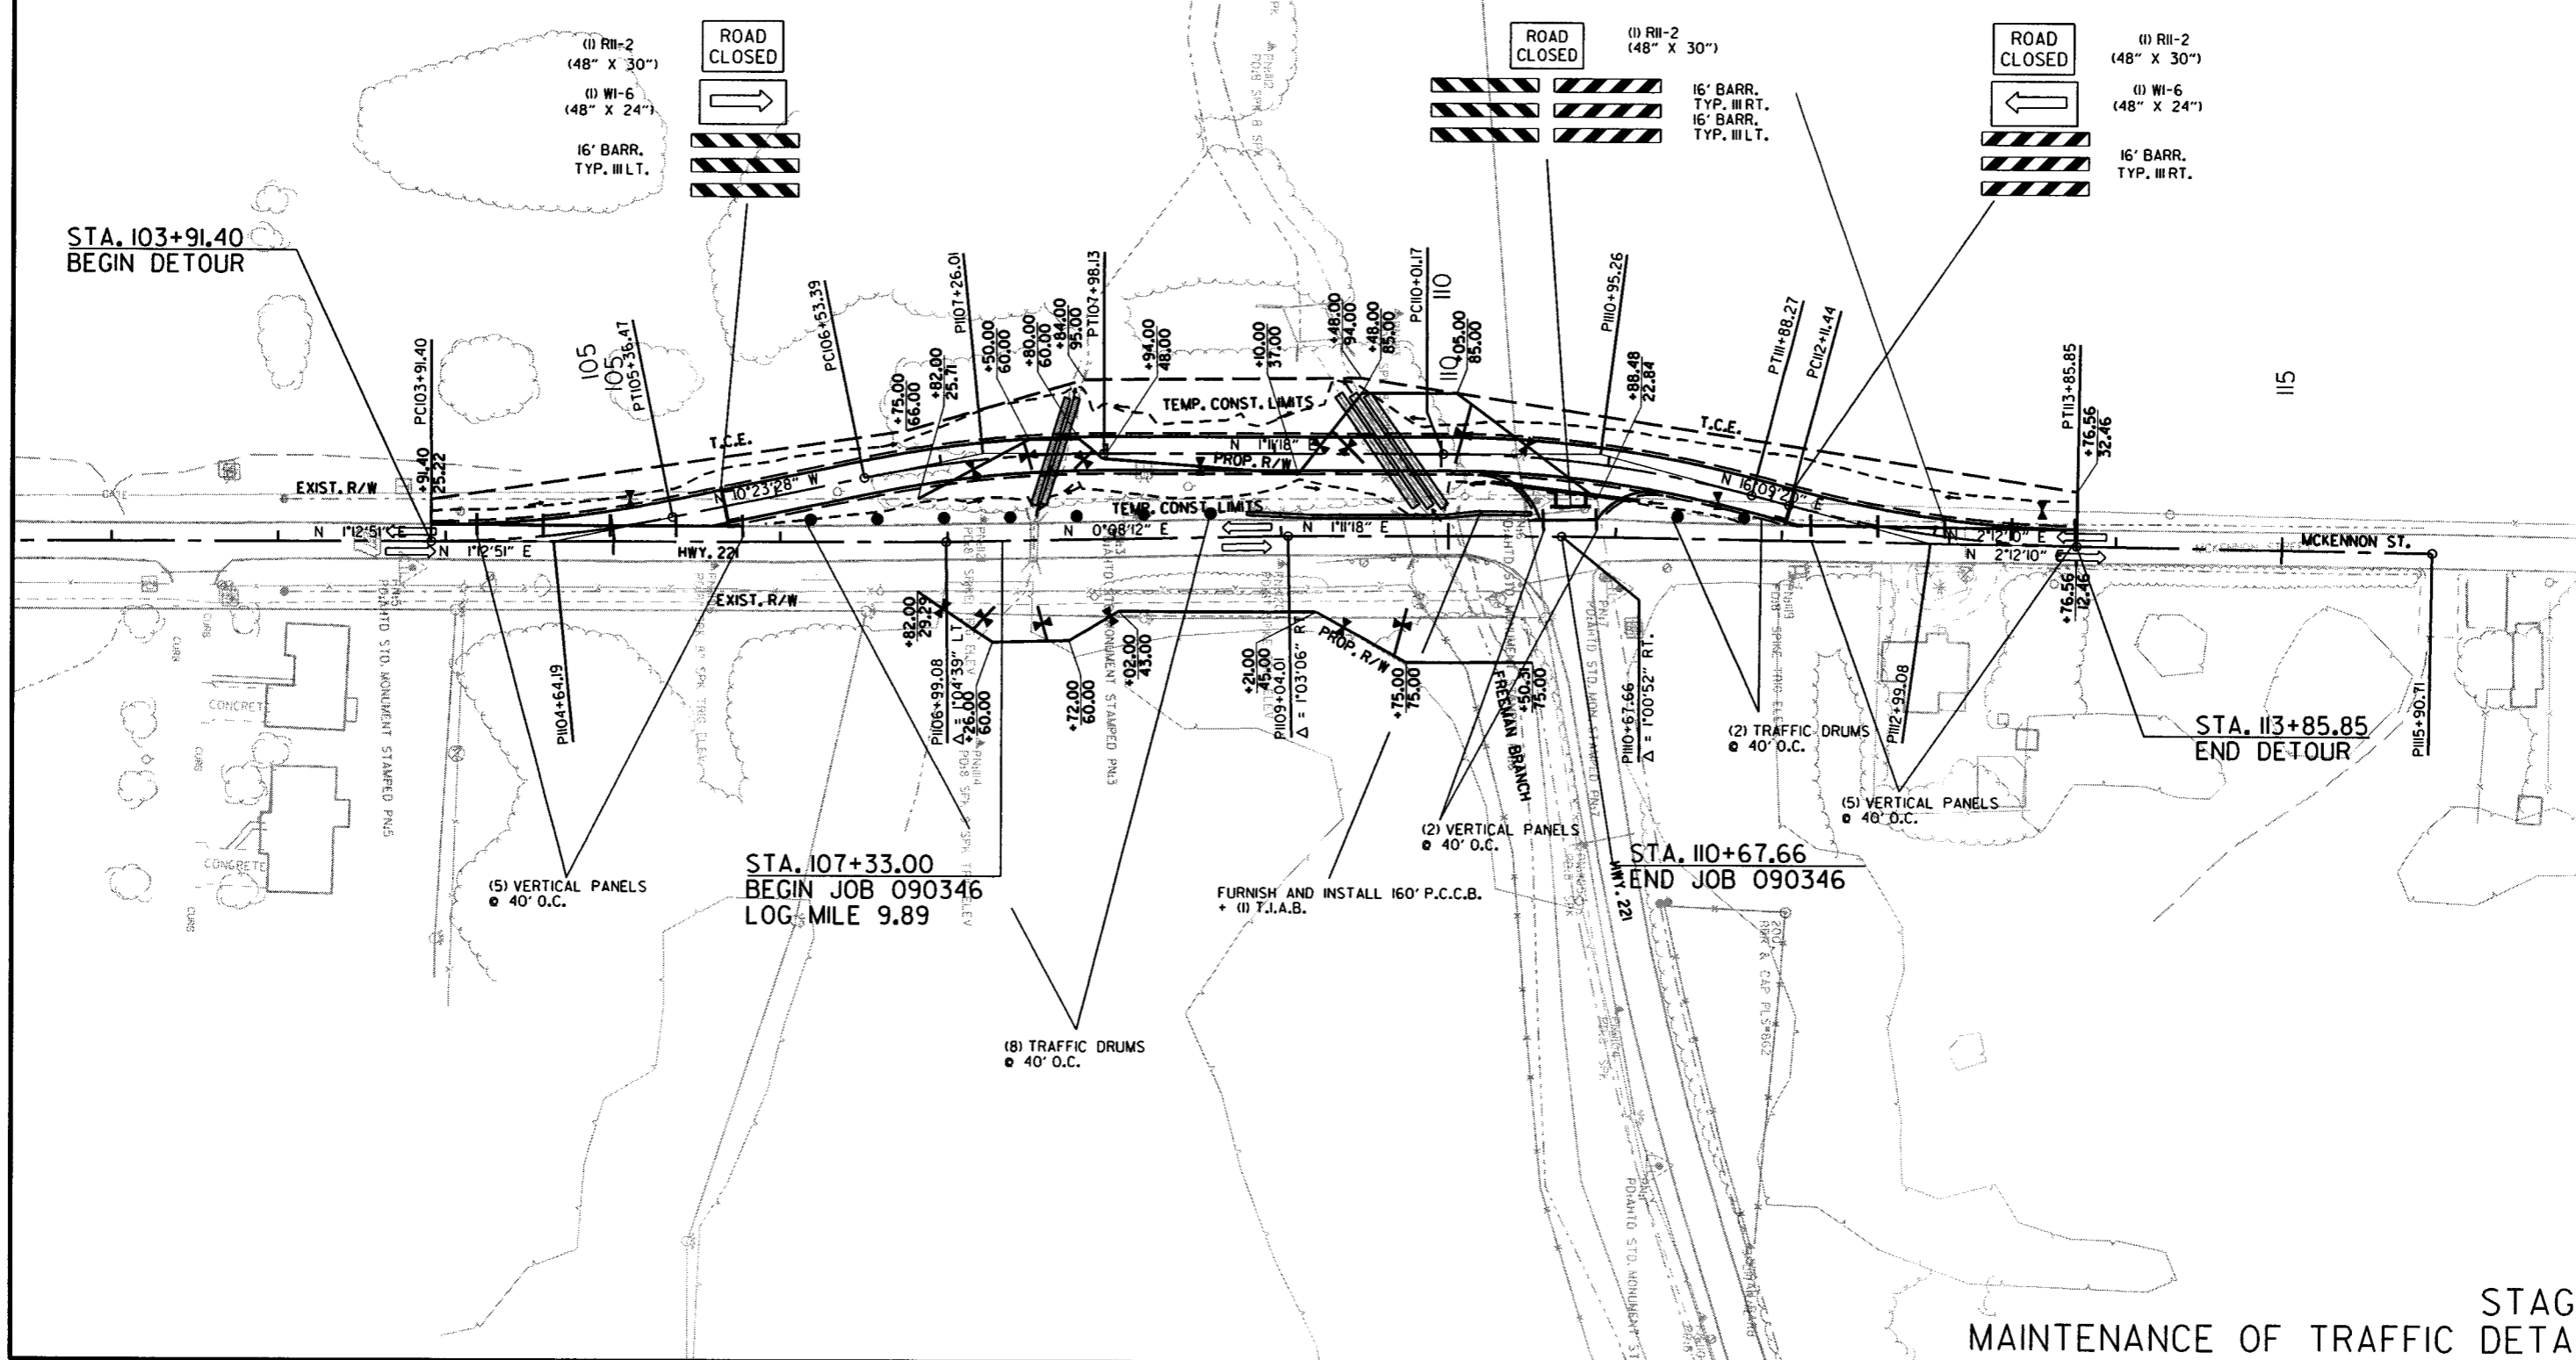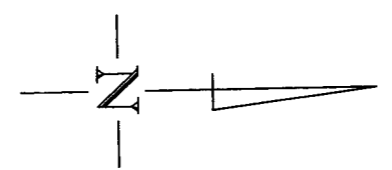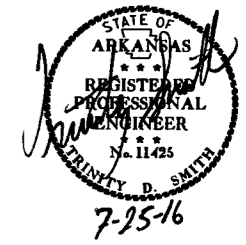

7/21/2016

R090346.DGN




STAGE I
 MAINTENANCE OF TRAFFIC DETAILS

STAGE 2 QUANTITIES

SIGNS = 266.5 SQ. FT.
 TRAFFIC DRUMS = 36 EACH
 TYPE III BARRICADE = 96 LIN. FT.
 CONSTRUCTION PAVEMENT MARKINGS = 4225 LIN. FT.

DATE REVISED	DATE FILMED	DATE REVISED	DATE FILMED	FED. RD. DIST. NO.	STATE	FED. AID PROJ. NO.	SHEET NO.	TOTAL SHEETS
				6	ARK.		20	56

② MAINTENANCE OF TRAFFIC DETAILS

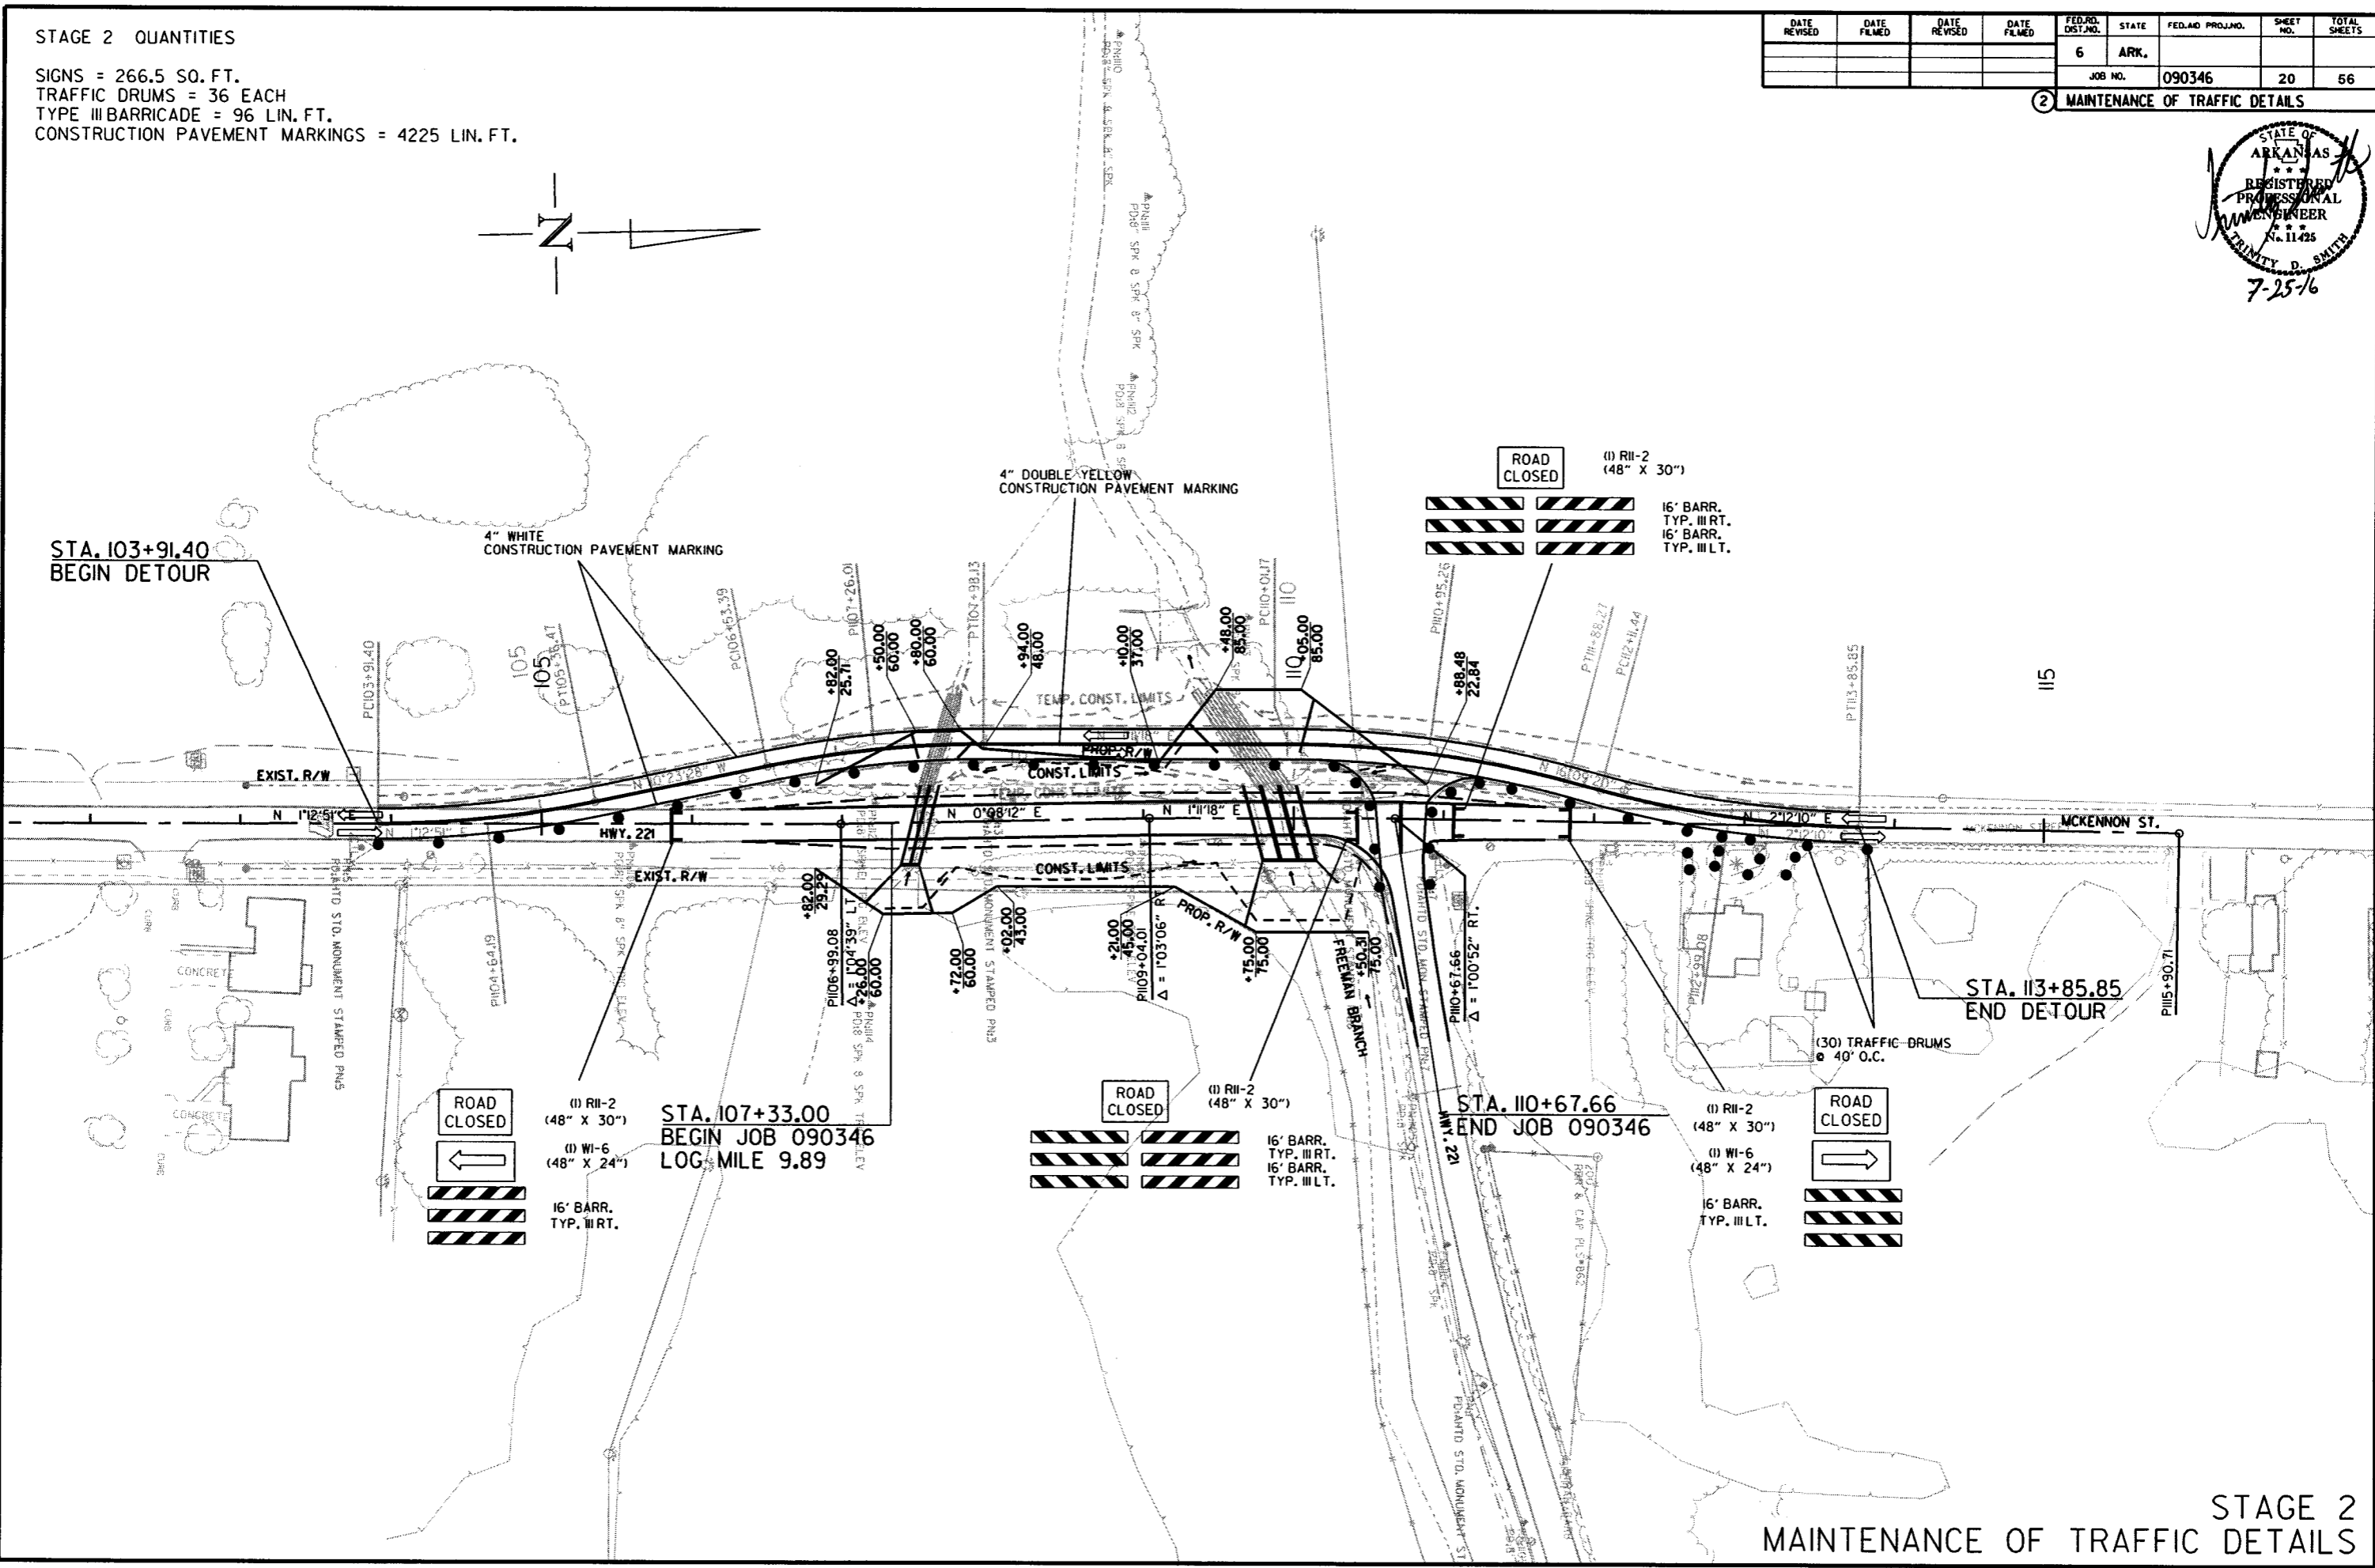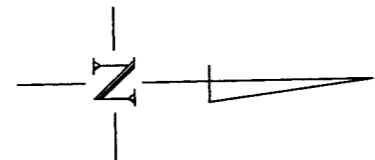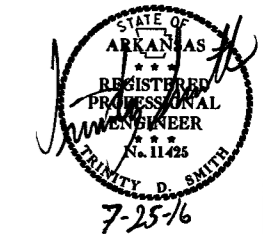

7/21/2016

R090346.DGN




STAGE 3 QUANTITIES

SIGNS = 256.5 SQ. FT.
 VERTICAL PANELS = 5 EACH
 TRAFFIC DRUMS = 10 EACH
 TYPE III BARRICADE = 64 LIN. FT.
 FURNISH AND INSTALL P.C.C.B. = 220 LIN. FT.
 RELOCATE P.C.C.B. = 160 LIN. FT.
 T.I.A.B. (RELOCATE) = 1 EACH
 CONSTRUCTION PAVEMENT MARKINGS = 4041 LIN. FT.

OBLITERATE DETOUR

DATE REVISED	DATE FILED	DATE REVISED	DATE FILED	FED. RD. DIST. NO.	STATE	FED. AID PROJ. NO.	SHEET NO.	TOTAL SHEETS
				6	ARK.			
JOB NO. 090346							21	56

MAINTENANCE OF TRAFFIC DETAILS

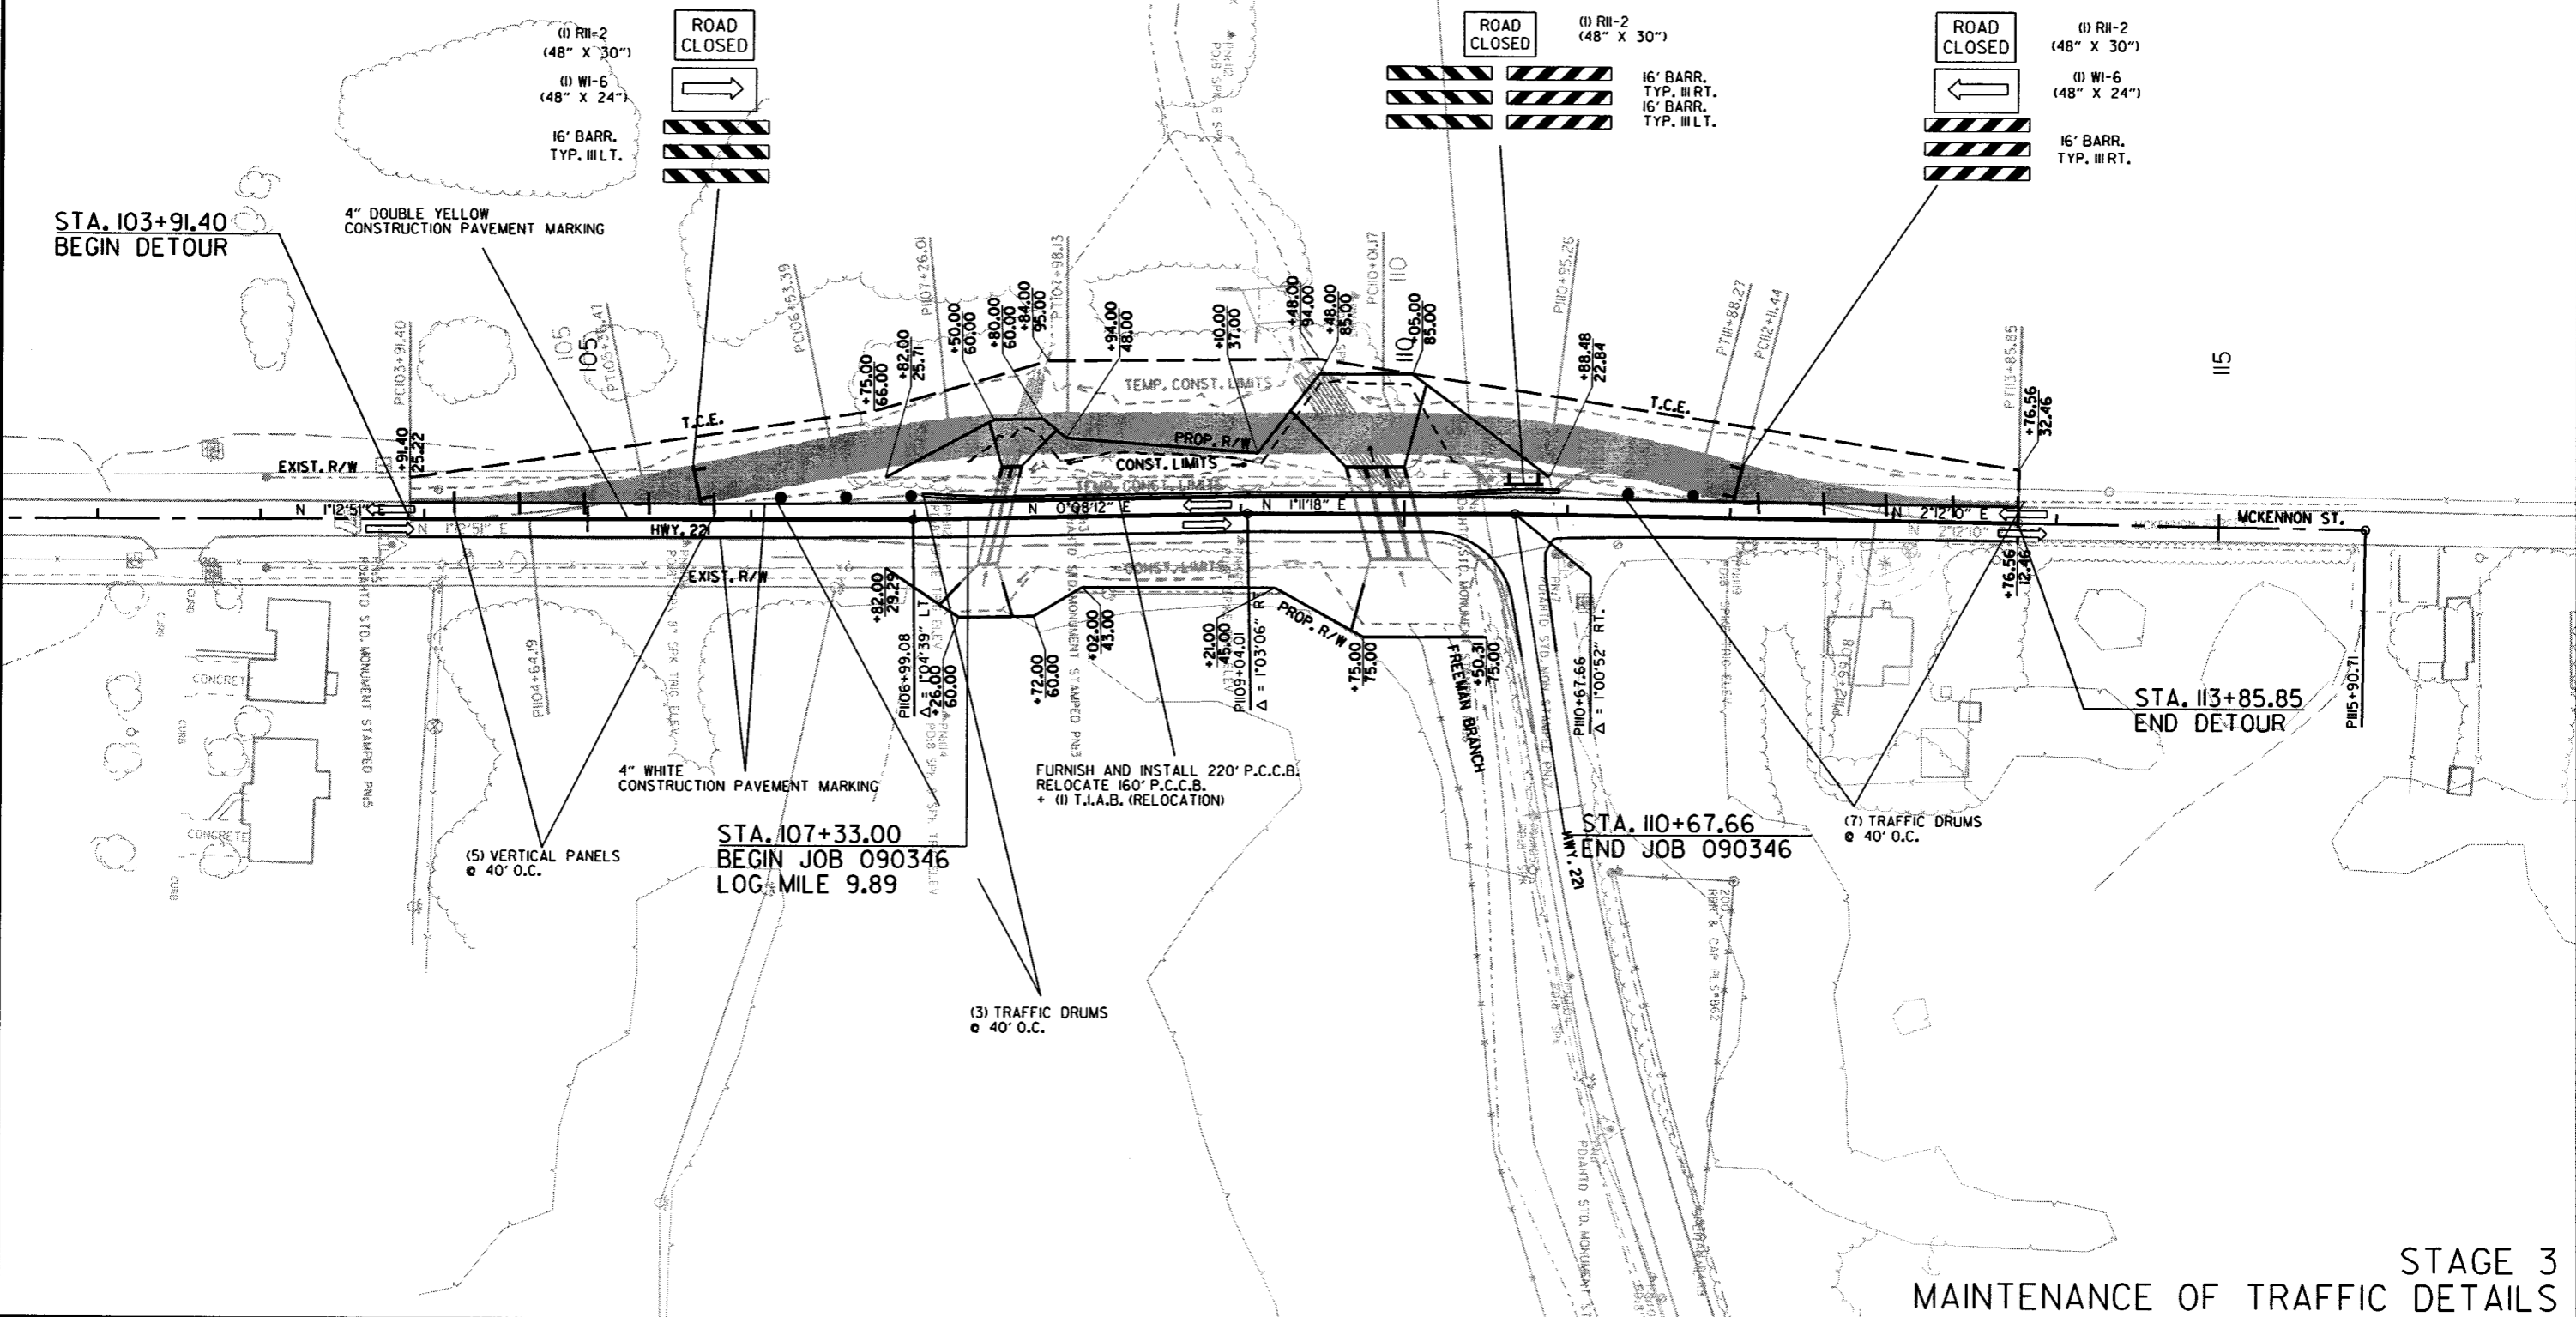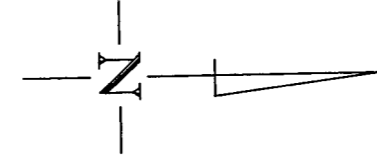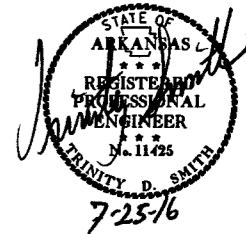

7/21/2016

R090346.DGN


PERMANENT PAVEMENT MARKINGS

REFLECTORIZED PAINT PAVEMENT MARKING WHITE (4") = 2219 LIN. FT.
 REFLECTORIZED PAINT PAVEMENT MARKING YELLOW (4") = 2261 LIN. FT.
 RAISED PAVEMENT MARKERS (TYPE III YELLOW/YELLOW) (40' O.C.) = 25 EACH

NOTE: THE 4" YELLOW STRIPING QUANTITY HAS BEEN ESTIMATED BASED ON A DOUBLE YELLOW CENTERLINE STRIPE FOR THE ENTIRE PROJECT. THE PROJECT MUST BE MARKED FOR PASSING/NO PASSING ZONES PRIOR TO THE PLACEMENT OF ANY FINAL STRIPING. CONTACT THE MAINTENANCE DIVISION AFTER THE FINAL LIFT OF SURFACE COURSE HAS BEEN PLACED TO SCHEDULE THE ZONING OF THE PROJECT.

DATE REVISED	DATE FILMED	DATE REVISED	DATE FILMED	FED. RD. DIST. NO.	STATE	FED. AID PROJ. NO.	SHEET NO.	TOTAL SHEETS
				6	ARK.		22	56
				JOB NO. 090346				

2 PERMANENT PAVEMENT MARKING DETAILS

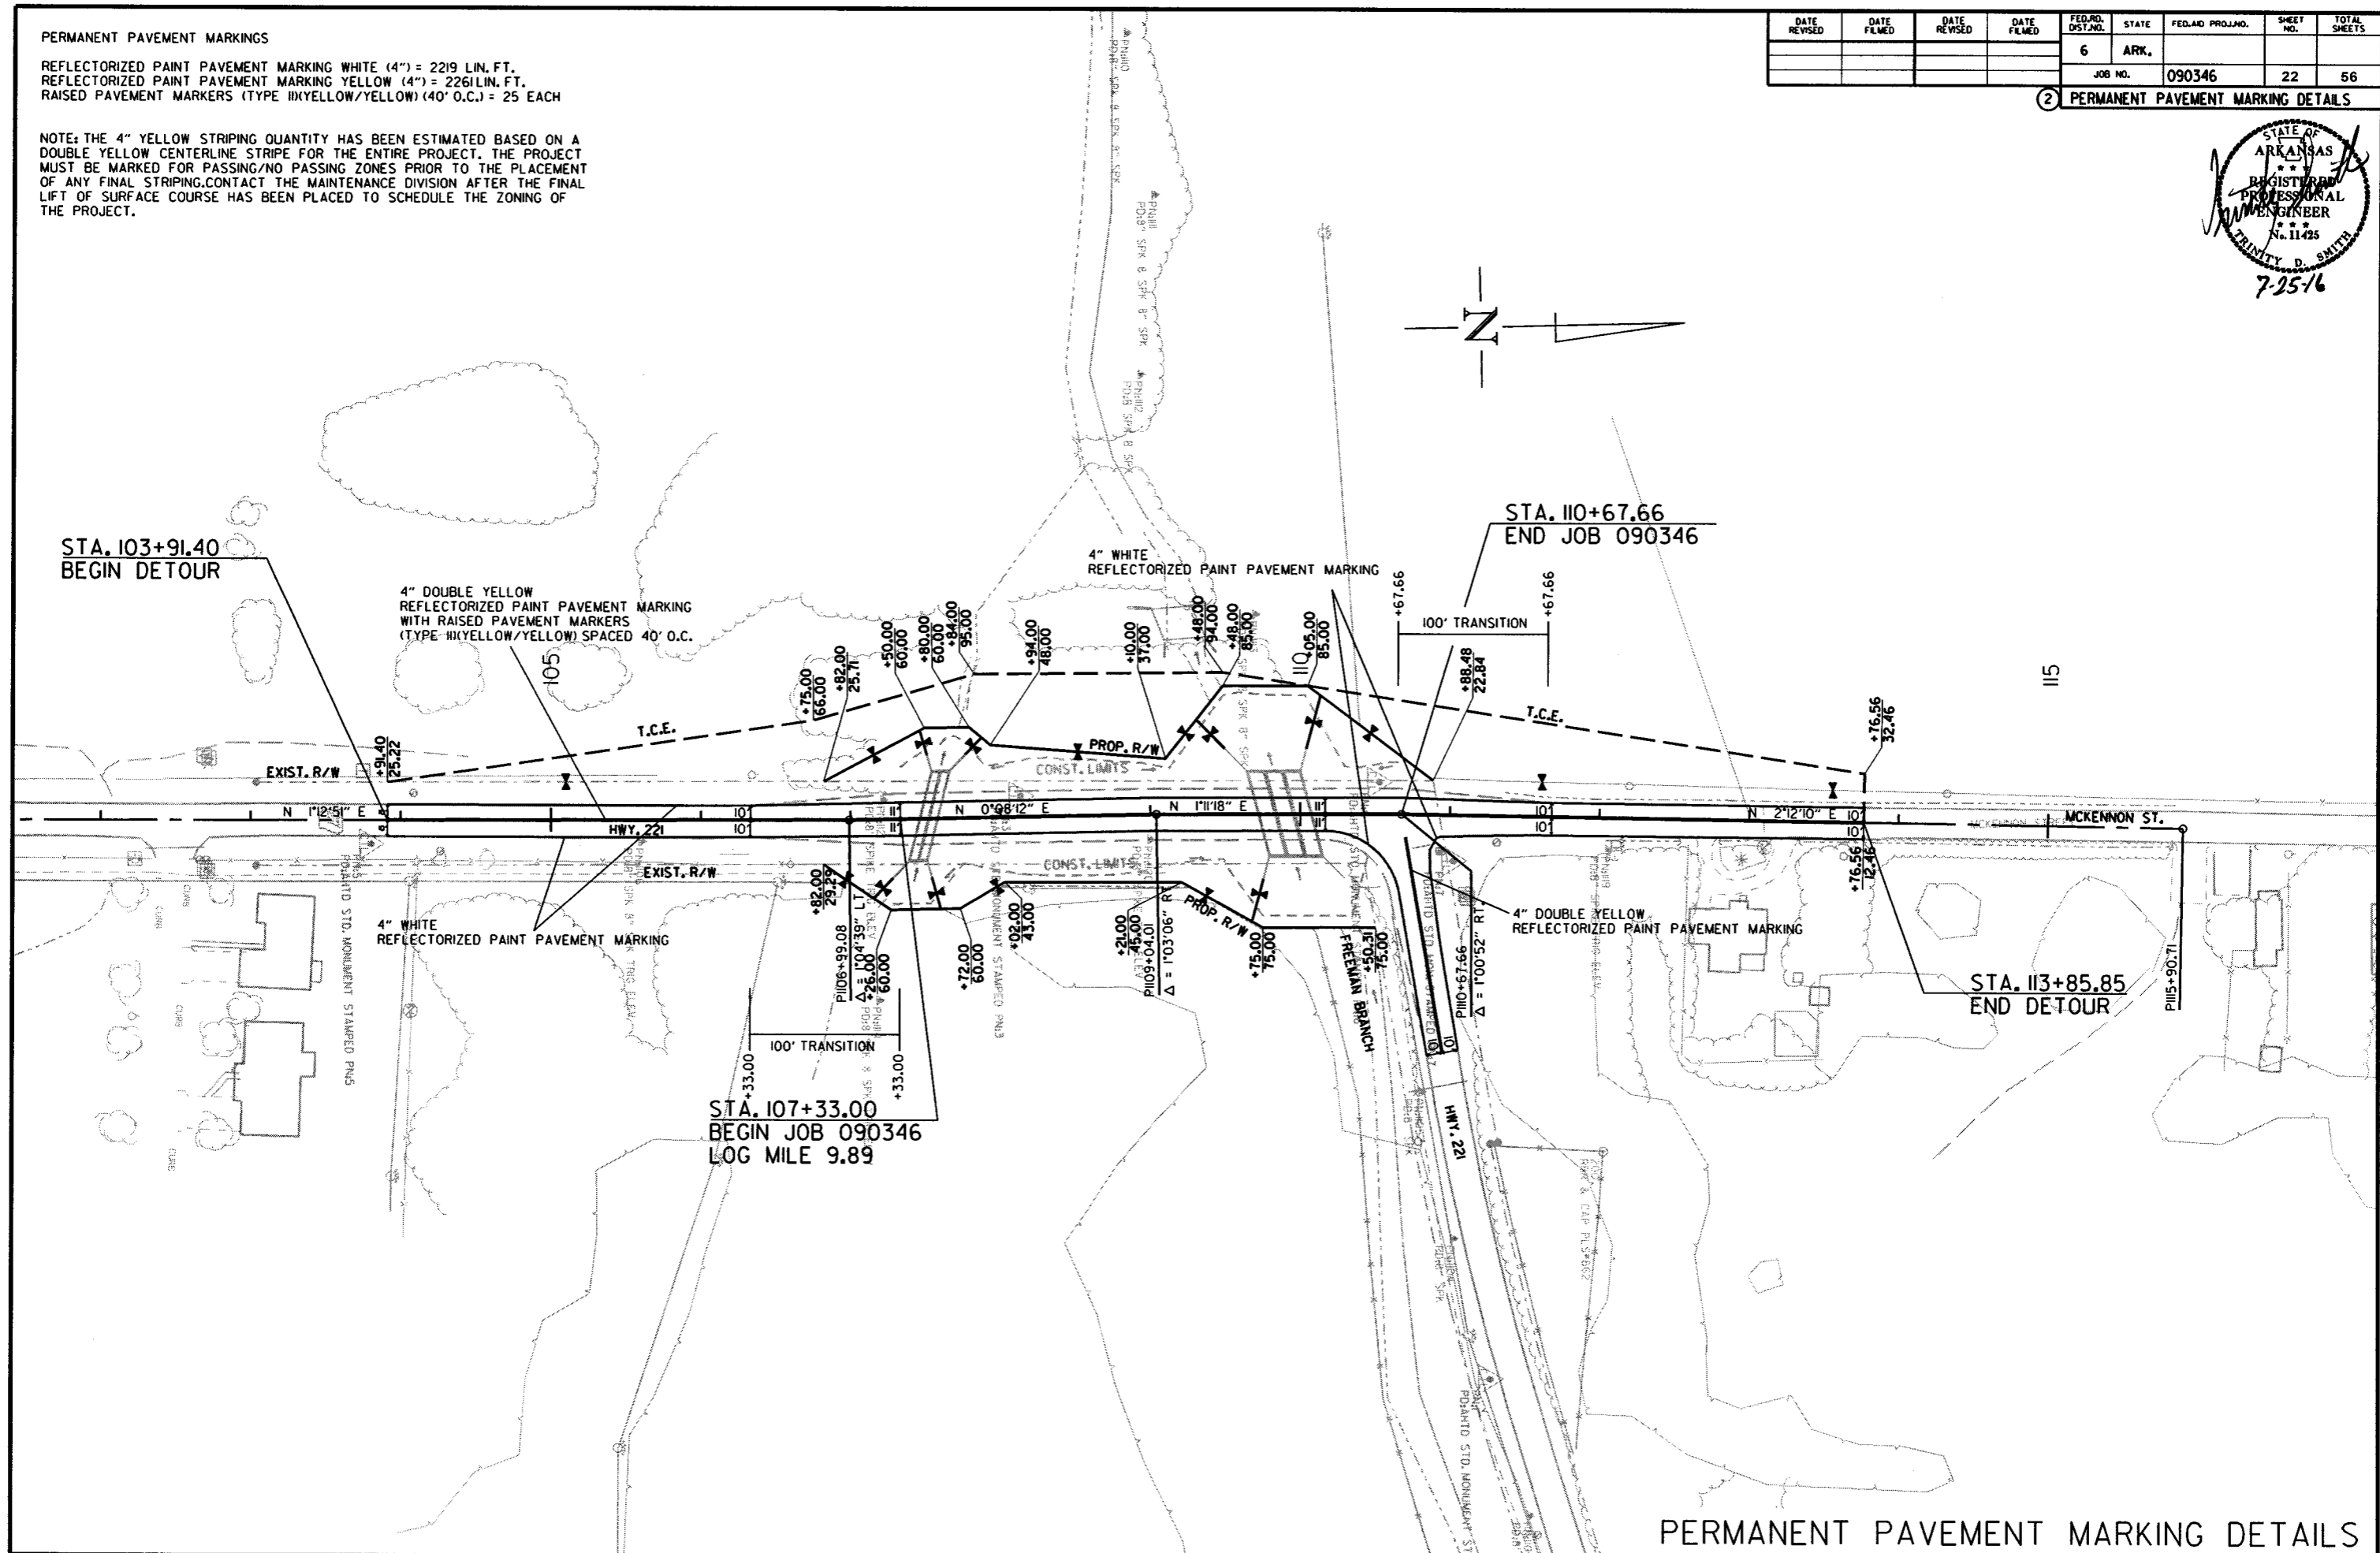


PERMANENT PAVEMENT MARKING DETAILS

7/21/2016

R090346.DGN

DATE REVISED	DATE FILMED	DATE REVISED	DATE FILMED	FED. RD. DIST. NO.	STATE	FED. AID PROJ. NO.	SHEET NO.	TOTAL SHEETS
				6	ARK.		23	56
				JOB NO. 090346				

② QUANTITIES

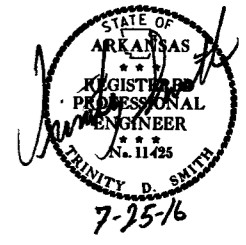

CONSTRUCTION PAVEMENT MARKINGS AND PERMANENT PAVEMENT MARKINGS

DESCRIPTION	STAGE 2	STAGE 3	END OF JOB	CONSTRUCTION PAVEMENT MARKINGS	RAISED PAVEMENT MARKERS	REFLECTORIZED PAINT PAVEMENT MARKING	
						4"	
						WHITE	YELLOW
LIN. FT. - EACH				LIN. FT.	TYPE II (YEL/YEL) EACH	LIN. FT.	
CONSTRUCTION PAVEMENT MARKINGS	4225	4041		8266			
RAISED PAVEMENT MARKERS TYPE II (YEL/YEL)			25		25		
REFLECTORIZED PAINT PAVEMENT MARKING WHITE (4")			2219			2219	
REFLECTORIZED PAINT PAVEMENT MARKING YELLOW (4")			2261				2261
TOTALS:				8266	25	2219	2261

NOTE: THIS IS A LOW TRAFFIC VOLUME ROAD AS DEFINED IN SECTION 604.03, STANDARD SPECIFICATIONS FOR HIGHWAY CONSTRUCTION.

NOTE: THE 4" YELLOW STRIPING QUANTITY HAS BEEN ESTIMATED BASED ON A DOUBLE YELLOW CENTERLINE STRIPE FOR THE ENTIRE PROJECT. THE PROJECT MUST BE MARKED FOR PASSING/NO PASSING ZONES PRIOR TO THE PLACEMENT OF ANY FINAL STRIPING. CONTACT THE MAINTENANCE DIVISION AFTER THE FINAL LIFT OF SURFACE COURSE HAS BEEN PLACED TO SCHEDULE THE ZONING OF THE PROJECT.

ADVANCE WARNING SIGNS AND DEVICES

SIGN NUMBER	DESCRIPTION	SIGN SIZE	STAGE 1	STAGE 2	STAGE 3	MAXIMUM NUMBER REQUIRED	TOTAL SIGNS REQUIRED		VERTICAL PANELS	TRAFFIC DRUMS	BARRICADES (TYPE III)		FURNISHING & INSTALLING PRECAST CONC. BARRIER	RELOCATING PRECAST CONCRETE BARRIER	TEMPORARY IMPACT ATTENUATION BARRIER	TEMP. IMPACT ATTEN.BARR. (REPAIR)	TEMP. IMPACT ATTEN.BARR. (RELOCATION)			
							NO.	SQ. FT.			EACH	RIGHT						LEFT	LIN. FT.	EACH
W20-1	ROAD WORK 1500 FT.	48"x48"	3	3	3	3	3	48.0												
W20-1	ROAD WORK 1000 FT.	48"x48"	3	3	3	3	3	48.0												
W20-1	ROAD WORK 500 FT.	48"x48"	3	3	3	3	3	48.0												
G20-2	END ROAD WORK	48"x24"	3	3	3	3	3	24.0												
R2-1	SPEED LIMIT 30	24"x30"	2	2	2	2	2	10.0												
R11-2	ROAD CLOSED	48"x30"	3	4	3	4	4	40.0												
W1-6	LARGE ARROW	48"x24"	2	2	2	2	2	16.0												
R4-1	DO NOT PASS	24"x30"	2	2	2	2	2	10.0												
RSP-1	SHOULDER CLOSED	48"x30"	2	2	2	2	2	20.0												
W8-1	BUMP	30"x30"	2	2	2	2	2	12.5												
	VERTICAL PANELS		12		5	12			12											
	TRAFFIC DRUMS		10	36	10	36				36										
	TYPE III BARRICADE-RT. (16')		2	3	2	3					48									
	TYPE III BARRICADE-LT. (16')		2	3	2	3						48								
	FURNISHING AND INSTALLING PRECAST CONCRETE BARRIER		160	220		380						380								
	RELOCATING PRECAST CONCRETE BARRIER			160		160							160							
	TEMPORARY IMPACT ATTENUATION BARRIER		1			1								1						
	TEMPORARY IMPACT ATTENUATION BARRIER (REPAIR)		1			1									1					
	TEMPORARY IMPACT ATTENUATION BARRIER (RELOCATION)			1		1											1			
TOTALS:								276.5	12	36	48	48	380	160	1	1	1			

NOTE: THIS IS A LOW TRAFFIC VOLUME ROAD AS DEFINED IN SECTION 604.03, STANDARD SPECIFICATIONS FOR HIGHWAY CONSTRUCTION.

7/21/2016

R090346.DCN

QUANTITIES

DATE REVISED	DATE FILMED	DATE REVISED	DATE FILMED	FED. RD. DIST. NO.	STATE	FED. AID PROJ. NO.	SHEET NO.	TOTAL SHEETS
				6	ARK.		24	56
				JOB NO. 090346				

CLEARING AND GRUBBING

STATION	STATION	LOCATION	CLEARING	GRUBBING
			STATION	
106+33	108+00	LT. AND RT. OF HWY. 221	2	2
108+00	109+00	LT. OF HWY. 221	1	1
109+00	110+25	LT. AND RT. OF HWY. 221	2	2
TOTALS:			5	5

REMOVAL AND DISPOSAL OF CULVERTS


STATION	DESCRIPTION	BOX CULVERTS
		EACH
107+52	4' X 7' X 24' R.C. BOX CULVERT	1
TOTAL:		1

NOTE: QUANTITY SHOWN ABOVE SHALL INCLUDE REMOVAL & DISPOSAL OF ALL HEADWALLS AND FLARED END SECTIONS IF APPLICABLE.

REMOVAL OF EXISTING BRIDGE STRUCTURE

STATION	STATION	LOCATION	LUMP SUM
109+73	110+11	HWY. 221 (SITE NO. 1)	1.00

② QUANTITIES

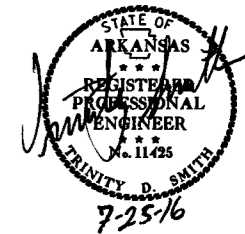

REMOVAL AND DISPOSAL OF ITEMS

STATION	STATION	LOCATION	SIGN FOUNDATIONS	GUARDRAIL	SIGNS
			EACH	LIN. FT.	EACH
108+99	109+74	LT. OF HWY. 221		75	
109+21	109+80	RT. OF HWY. 221		75	
110+06	110+81	LT. OF HWY. 221		75	
110+10	110+61	RT. OF HWY. 221		75	
110+89		LT. OF HWY. 221	1		1
TOTALS:			1	300	1

EARTHWORK

STATION	STATION	LOCATION / DESCRIPTION	UNCLASSIFIED EXCAVATION	COMPACTED EMBANKMENT	* SOIL STABILIZATION
			CU. YD.	CU. YD.	TON
ENTIRE PROJECT		STAGE 1	917	1779	
ENTIRE PROJECT		STAGE 2	1232	1100	
ENTIRE PROJECT		STAGE 3	2562	679	
ENTIRE PROJECT		TO BE USED IF AND WHERE DIRECTED BY THE ENGINEER			10
TOTALS:			4711	3558	10

NOTE: EARTHWORK QUANTITIES SHOWN ABOVE SHALL BE PAID AS PLAN QUANTITY.
* QUANTITY ESTIMATED.
SEE SECTION 104.03 OF THE STD. SPECS.

FENCING

STATION	STATION	LOCATION	WIRE FENCE	* 16'-0" GATES
			(TYPE D) LIN. FT.	EACH
103+91	107+51	LT. OF HWY. 221	380	2
106+82	107+28	RT. OF HWY. 221	60	
107+53	108+22	RT. OF HWY. 221	92	1
107+77	109+49	LT. OF HWY. 221	216	1
108+99	110+08	RT. OF HWY. 221	216	
110+04	113+77	LT. OF HWY. 221	419	1
TOTALS:			1383	5

* DENOTES ALTERNATE BID ITEM.

REMOVAL AND DISPOSAL OF FENCE

STATION	STATION	LOCATION	FENCE
			LIN. FT.
103+91	109+40	LT. OF HWY. 221	626
106+82	108+22	RT. OF HWY. 221	140
108+99	110+08	RT. OF HWY. 221	131
109+95	113+77	LT. OF HWY. 221	427
TOTAL:			1324

SOIL LOG

STATION	LATITUDE			LONGITUDE			LOCATION	DEPTH FEET	LIQUID LIMIT	PLASTICITY INDEX	AASHTO CLASSIFICATION	COLOR
	DEG	MIN	SEC	DEG	MIN	SEC						
105+35	36	21	21.10	93	34	16.00	4.80' RT.	0-4Z	42	26	A-7-6 (18)	BROWN
105+35	36	21	21.10	93	34	15.80	17.80' RT.	0-1.5Z	25	10	A-4 (2)	BROWN
112+50	36	21	28.10	93	34	16.20	4.69' LT.	0-5	35	21	A-6 (10)	BROWN
112+50	36	21	28.10	93	34	16.20	14.69' LT.	0-4Z	29	14	A-6 (11)	BROWN
203+88	36	21	27.10	93	34	11.50	4.86' LT.	0-4Z	32	18	A-6 (4)	BROWN
203+88	36	21	27.20	93	34	11.50	18.86' LT.	0-4Z	31	17	A-6 (14)	BROWN
203+88	36	21	27.20	93	34	11.50	18.86' LT.	0-4Z	61	39	A-7-6 (39)	BROWN

SOIL CHARACTERISTICS TABULATED ABOVE ARE REPRESENTATIVE AT THE LOCATION OF THE SAMPLE, AND FROM SURFACE INDICATIONS ARE TYPICAL FOR THE LIMITS SHOWN. THESE DATA ARE SHOWN FOR INFORMATION ONLY. THE STATE WILL NOT BE RESPONSIBLE FOR VARIATIONS IN THE SOIL CHARACTERISTICS AND/OR EXTENT OF SAME DIFFERING FROM THE ABOVE TABULATIONS.
Z- AUGER REFUSAL.

EROSION CONTROL

STATION	STATION	LOCATION	PERMANENT EROSION CONTROL					TEMPORARY EROSION CONTROL											
			SEEDING	LIME	MULCH COVER	WATER	SECOND SEEDING APPLICATION	TEMPORARY SEEDING	MULCH COVER	WATER	WATTLE (20")	SAND BAG DITCH CHECKS	ROCK DITCH CHECKS	SILT FENCE	TRIANGULAR SILT DIKE	SEDIMENT BASIN	OBLITERATION OF SEDIMENT BASIN	*SEDIMENT REMOVAL & DISPOSAL	
																			ACRE
ENTIRE PROJECT		CLEARING AND GRUBBING																	
ENTIRE PROJECT		STAGE 1																12	
ENTIRE PROJECT		STAGE 2							0.81	0.81	16.5							27	
ENTIRE PROJECT		STAGE 3							0.38	0.38	7.8							4	
ENTIRE PROJECT		END OF JOB	1.06	2.12	1.06	108.1	1.06		0.34	0.34	6.9							4	
*ENTIRE PROJECT TO BE USED IF AND WHERE DIRECTED BY THE ENGINEER.			0.27	0.54	0.27	27.5	0.27		0.38	0.38	7.8	90	220	42	200	250	133	133	184
TOTALS:			1.33	2.66	1.33	135.6	1.33		1.91	1.91	39.0	90	220	204	520	250	133	133	231

BASIS OF ESTIMATE:
LIME 2 TONS / ACRE OF SEEDING
WATER..... 102.0 M.G. / ACRE OF SEEDING
WATER..... 20.4 M.G. / ACRE OF TEMPORARY SEEDING
SAND BAG DITCH CHECKS..... 22 BAGS / LOCATION
ROCK DITCH CHECKS..... 3 CU.YD./LOCATION
TRIANGULAR SILT DIKES..... 25 LIN. FT./LOCATION

NOTE: THE TEMPORARY EROSION CONTROL DEVICES SHOWN ABOVE AND ON THE PLANS SHALL BE INSTALLED IN SUCH A SEQUENCE AS TO DETER EROSION AND SEDIMENTATION ON U.S. WATERWAYS AS EXPLAINED BY THE NATIONAL POLLUTANT DISCHARGE ELIMINATION SYSTEM PERMIT.

*QUANTITIES ESTIMATED.
SEE SECTION 104.03 OF THE STD. SPECS.

QUANTITIES

7/21/2016 R090346.DGN

DATE REVISED	DATE FILMED	DATE REVISED	DATE FILMED	FED. RD. DIST. NO.	STATE	FED. AID PROJ. NO.	SHEET NO.	TOTAL SHEETS
				6	ARK.			
						JOB NO. 090346	25	56

CONCRETE DITCH PAVING

STATION	STATION	LOCATION	LENGTH		CONC. DITCH PAVING (TYPE B)		SOLID SODDING	WATER
			LIN. FT.	FEET	SQ. YD.	SQ. YD.	M. GAL.	
107+33.00	107+51.44	HWY. 221-LT.	18.44	6.33	12.97	8.20	0.10	
107+53.45	109+75.32	HWY. 221-RT.	221.87	6.33	156.05	98.61	1.24	
107+77.18	109+49.43	HWY. 221-LT.	172.25	6.33	121.15	76.56	0.96	
110+04.05	110+66.67	HWY. 221-LT.	62.62	6.33	44.04	27.83	0.35	
TOTALS:						334.21	211.20	2.65


BASIS OF ESTIMATE:
WATER.....12.6 GAL. / SQ. YD. OF SOLID SODDING.

ASPHALT CONCRETE PATCHING FOR MAINTENANCE OF TRAFFIC

LOCATION	TON	TACK COAT GALLON
ENTIRE PROJECT - TO BE USED IF AND WHERE DIRECTED BY THE ENGINEER	1	2
TOTALS:	1	2

BASIS OF ESTIMATE:
ASPHALT CONCRETE PATCHING FOR MAINTENANCE OF TRAFFIC...25 TON/MILE
TACK COAT FOR MAINTENANCE OF TRAFFIC.....50 GAL./MILE

QUANTITIES

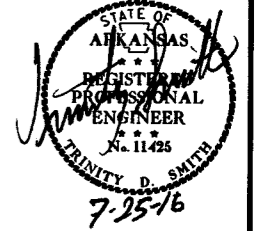

BENCH MARKS

STATION	LOCATION	BENCH MARKS
		EACH
107+52	HEADWALL ON LT. OF R.C. BOX CULVERT	1
109+90	HEADWALL ON LT. OF R.C. BOX CULVERT	1
TOTAL:		2

NOTE: SHOWN FOR INFORMATION ONLY. BENCH MARKS SHALL BE FURNISHED AND PLACED BY STATE FORCES.

COLD MILLING ASPHALT PAVEMENT

STATION	STATION	LOCATION	AVG. WIDTH	COLD MILLING ASPHALT PAVEMENT
			FEET	SQ. YD.
106+33.00	107+33.00	HWY. 221	20.00	222.22
110+67.66	111+67.66	HWY. 221	20.00	222.22
110+67.66	111+67.66	MCKENNON ST.	20.00	222.22
TOTAL:				666.66

NOTE: AVERAGE MILLING DEPTH 1".

4" PIPE UNDERDRAIN

STATION	STATION	LOCATIONS	4" PIPE UNDERDRAINS	UNDERDRAIN OUTLET PROTECTORS
			LIN. FT.	EACH
ENTIRE PROJECT TO BE USED IF AND WHERE DIRECTED BY THE ENGINEER			500	2
TOTALS:			500	2

* NOTE: QUANTITY ESTIMATED. SEE SECTION 104.03 OF THE STD. SPECS.

STRUCTURES

STATION	DESCRIPTION	TEMPORARY CULVERTS			SPAN	HEIGHT	LENGTH	CLASS S CONCRETE-ROADWAY	REINF. STEEL-ROADWAY (GRADE 60)	UNCL. EXC. FOR STR.-ROADWAY	SOLID SODDING	WATER	STD. DWG. NOS.
		12"	42"	60"									
		LIN. FT.											
107+52	DBL. 5' X 4' X 62' R.C. BOX CULVERT, 15° LT. FWD. SKEW				5	4	62	64.12	7297	30	17	0.21	SPECIAL DETAILS, PCB-1, RCB-1, RCB-2
107+69	DBL. 42" X 54' TEMP. PIPE CULVERT, 20° LT. FWD. SKEW		108										PCC-1, PCM-1, PCP-1, PCP-2
109+72	TRI. 60" X 62' TEMP. PIPE CULVERT, 35° RT. FWD. SKEW			186									PCC-1, PCM-1
110+76	12" X 90' TEMP. PIPE CULVERT	90											PCC-1, PCM-1
SUBTOTALS:		90	108	186				64.12	7297	30	17	0.21	
STRUCTURES OVER 20' - 0" SPAN													
109+90	TRI. 10' X 7' X 59' R.C. BOX CULVERT, 15° RT. FWD. SKEW				10	7	59	187.84	27449	86	32	0.40	SPECIAL DETAILS, PCB-1, RCB-1, RCB-2
SUBTOTALS:								187.84	27449	86	32	0.40	
TOTALS:		90	108	186				251.96	34746	116	49	0.61	

BASIS OF ESTIMATE:
WATER.....12.6 GAL. / SQ. YD. OF SOLID SODDING.

NOTE: FOR R.C. PIPE CULVERT INSTALLATIONS USE TYPE 3 BEDDING UNLESS OTHERWISE SPECIFIED.

NOTE: FOR C.M. PIPE CULVERT INSTALLATIONS USE TYPE 2 BEDDING UNLESS OTHERWISE SPECIFIED.

ACHM PATCHING OF EXISTING ROADWAY

DESCRIPTION	TON
ENTIRE PROJECT - TO BE USED IF AND WHERE DIRECTED BY THE ENGINEER	20
TOTAL:	20

NOTE: QUANTITY ESTIMATED. SEE SECTION 104.03 OF THE STD. SPECS.

BASE AND SURFACING

STATION	STATION	LOCATION	LENGTH	AGGREGATE BASE COURSE (CLASS 7)		TACK COAT				ACHM SURFACE COURSE (1/2")								
				TON / STATION	TON	AVG. WID.	SQ. YD.	GALLONS / SQ. YD.	GALLON	AVG. WID.	SQ. YD.	POUND / SQ. YD.	PG 64-22	AVG. WID.	SQ. YD.	POUND / SQ. YD.	PG 64-22	TOTAL PG 64-22
						FEET				FEET			TON	FEET			TON	TON
MAIN LANES																		
106+33.00	107+33.00	HWY. 221 TRANSITION	100.00			20.00	222.22	0.17	37.78					20.00	222.22	220.00	24.44	24.44
107+33.00	110+67.66	HWY. 221	334.66	267.00	893.54	22.25	827.35	0.05	41.37	22.25	827.35	220.00	91.01	34.00	1264.27	220.00	139.07	230.08
110+67.66	111+67.66	HWY. 221 TRANSITION	100.00			VAR.	601.08	0.17	102.18					VAR.	601.08	220.00	66.12	66.12
DETOUR																		
103+91.40	105+68.56	DETOUR - NOTCH AND WIDEN	177.16	VAR.	128.46									VAR.	187.61	220.00	20.64	20.64
105+68.56	112+12.12	DETOUR	643.56	177.25	1140.71									24.00	1716.16	220.00	188.78	188.78
112+12.12	113+85.85	DETOUR - NOTCH AND WIDEN	173.73	VAR.	124.10									VAR.	180.94	220.00	19.90	19.90
110+21.89	111+36.08	DETOUR - HWY. 221 TURNOUT	114.19	VAR.	112.01									VAR.	175.85	220.00	19.34	19.34
TOTALS:					2398.82		1650.65		181.33		827.35		91.01		4348.13		478.29	569.30

BASIS OF ESTIMATE:
ACHM SURFACE COURSE (1/2").....94.7% MIN. AGGR.....5.3% ASPHALT BINDER
MAXIMUM NUMBER OF GYRATIONS = 115 FOR PG 64-22


7/21/2016

R090346.DGN

DATE REVISED	DATE FILMED	DATE REVISED	DATE FILMED	FED. RD. DIST. NO.	STATE	FED. AID PROJ. NO.	SHEET NO.	TOTAL SHEETS
				6	ARK.			
				JOB NO.	090346		26	56

SUMMARY OF QUANTITIES

2 SUMMARY OF QUANTITIES AND REVISIONS

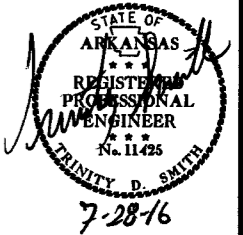

ITEM NUMBER	ITEM	QUANTITY	UNIT
SP & 201	CLEARING	5	STATION
201	GRUBBING	5	STATION
202	REMOVAL AND DISPOSAL OF FENCE	1324	LIN. FT.
202	REMOVAL AND DISPOSAL OF SIGN FOUNDATIONS	1	EACH
202	REMOVAL AND DISPOSAL OF BOX CULVERTS	1	EACH
202	REMOVAL AND DISPOSAL OF GUARDRAIL	300	LIN. FT.
202	REMOVAL AND DISPOSAL OF SIGNS	1	EACH
210	UNCLASSIFIED EXCAVATION	4711	CU. YD.
SP & 210	COMPACTED EMBANKMENT	3558	CU. YD.
SP & 210	SOIL STABILIZATION	10	TON
SS & 303	AGGREGATE BASE COURSE (CLASS 7)	2399	TON
SS & 401	TACK COAT	183	GAL.
SP, SS, & 407	MINERAL AGGREGATE IN ACHM SURFACE COURSE (1/2")	539	TON
SP, SS, & 407	ASPHALT BINDER (PG 64-22) IN ACHM SURFACE COURSE (1/2")	30	TON
412	COLD MILLING ASPHALT PAVEMENT	667	SQ. YD.
SP & 414	ASPHALT CONCRETE PATCHING FOR MAINTENANCE OF TRAFFIC	1	TON
SP & 415	ACHM PATCHING OF EXISTING ROADWAY	20	TON
601	MOBILIZATION	1.00	LUMP SUM
SP & 602	FURNISHING FIELD OFFICE	1	EACH
603	MAINTENANCE OF TRAFFIC	1.00	LUMP SUM
603	12" TEMPORARY CULVERT	90	LIN. FT.
603	42" TEMPORARY CULVERT	108	LIN. FT.
603	60" TEMPORARY CULVERT	186	LIN. FT.
SS & 604	SIGNS	277	SQ. FT.
SS & 604	BARRICADES	96	LIN. FT.
SS & 604	TRAFFIC DRUMS	36	EACH
604	FURNISHING AND INSTALLING PRECAST CONCRETE BARRIER	380	LIN. FT.
604	RELOCATING PRECAST CONCRETE BARRIER	160	LIN. FT.
604	CONSTRUCTION PAVEMENT MARKINGS	8266	LIN. FT.
SS & 604	VERTICAL PANELS	12	EACH
605	CONCRETE DITCH PAVING (TYPE B)	334	SQ. YD.
611	UNDERDRAIN OUTLET PROTECTORS	2	EACH
611	4" PIPE UNDERDRAINS	500	LIN. FT.
619	WIRE FENCE (TYPE D)	1383	LIN. FT.
619	16' STEEL GATES (ALTERNATE NO. 1)	5	EACH
619	16' ALUMINUM GATES (ALTERNATE NO. 2)	5	EACH
620	LIME	3	TON
620	SEEDING	1.33	ACRE
SS & 620	MULCH COVER	3.24	ACRE
620	WATER	177.9	M.GAL.
621	TEMPORARY SEEDING	1.91	ACRE
621	SILT FENCE	520	LIN. FT.
621	SAND BAG DITCH CHECKS	220	BAG
621	SEDIMENT BASIN	133	CU. YD.
621	OBLITERATION OF SEDIMENT BASIN	133	CU. YD.
621	SEDIMENT REMOVAL AND DISPOSAL	231	CU. YD.
621	ROCK DITCH CHECKS	204	CU. YD.
621	WATTLE (20")	90	LIN. FT.
621	TRIANGULAR SILT DIKE	250	LIN. FT.
623	SECOND SEEDING APPLICATION	1.33	ACRE
624	SOLID SODDING	260	SQ. YD.
635	ROADWAY CONSTRUCTION CONTROL	1.00	LUMP SUM
718	REFLECTORIZED PAINT PAVEMENT MARKING WHITE (4")	2219	LIN. FT.
718	REFLECTORIZED PAINT PAVEMENT MARKING YELLOW (4")	2261	LIN. FT.
721	RAISED PAVEMENT MARKERS (TYPE II)	25	EACH
731	TEMPORARY IMPACT ATTENUATION BARRIER	1	EACH
731	TEMPORARY IMPACT ATTENUATION BARRIER (REPAIR)	1	EACH
731	TEMPORARY IMPACT ATTENUATION BARRIER (RELOCATION)	1	EACH
801	UNCLASSIFIED EXCAVATION FOR STRUCTURES-ROADWAY	30	CU. YD.
802	CLASS S CONCRETE-ROADWAY	64.12	CU. YD.
804	REINFORCING STEEL-ROADWAY (GRADE 60)	7297	POUND
STRUCTURES OVER 20' SPAN			
205	REMOVAL OF EXISTING BRIDGE STRUCTURE (SITE NO. 1)	1.00	LUMP SUM
801	UNCLASSIFIED EXCAVATION FOR STRUCTURES-ROADWAY	86	CU. YD.
802	CLASS S CONCRETE-ROADWAY	187.84	CU. YD.
804	REINFORCING STEEL-ROADWAY (GRADE 60)	27449	POUND

* DENOTES ALTERNATE BID ITEMS.

REVISIONS

DATE	REVISION	SHEET NUMBER


7/28/2016

R090346.DGN

SURVEY CONTROL COORDINATES
 Project Name: 090346
 Date: 8/19/2013
 Coordinate System: Arkansas State Plane Coordinates
 Based on AHTD GPS PTS : 080020, 080028, 080034, & 080034A
 Projected to Ground Coordinates
 Units: U.S. Survey Foot

DATE REWSED	DATE FILMED	DATE REWSED	DATE FILMED	FED. RD. DIST. NO.	STATE	FED. AID PROJ. NO.	SHEET NO.	TOTAL SHEETS
				6	ARK.		27	56

2 SURVEY CONTROL DETAILS

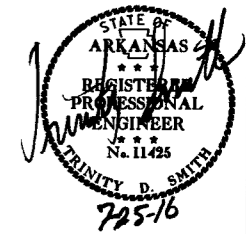

COORDINATES LISTED BELOW ARE GROUND (Localized) COORDINATES !!!!

Point No.	Northing	SY	Easting	SX	Elevation	SZ	Feature Code	Point Description
1	740486.0048	0.0126	850093.6547	0.01	1147.451	0.0101	CTL	PD:AHTD STD. MONUMENT STAMPED PN:1
2	740468.2843	0.0111	849749.3042	0.0099	1150.779	0.01	CTL	PD:AHTD STD. MONUMENT STAMPED PN:2
3	740180.0757	0.0107	849700.4559	0.0098	1151.365	0.0102	CTL	PD:AHTD STD. MONUMENT STAMPED PN:3
4	741207.7369	0.0113	849733.4463	0.0097	1218.799	0.0094	CTL	PD:AHTD STD. MONUMENT STAMPED PN:4
5	739746.6043	0.0106	849722.8212	0.0099	1188.209	0.0104	CTL	PD:AHTD STD. MONUMENT STAMPED PN:5
6	740419.5988	0.0105	849696.0508	0.0094	1147.984	0.0101	CTL	PD:AHTD STD. MONUMENT STAMPED PN:6
7	740468.1741	0.0077	849749.2332	0.0062	1150.522	0.0037	CTL	PD:AHTD STD. MONUMENT STAMPED PN:7
100	736848.6231	0.0001	852312.1272	0.0001	1283.688	0.0116	GPS	PD:AHTD GPS #080020
101	738334.6183	0.0001	852309.2826	0.0001	1267.133	0.0112	GPS	PD:AHTD GPS #080028
102	747629.4213	0.0001	846193.0617	0.0001	1271.569	0.0077	GPS	PD:AHTD GPS #080034
103	746456.0672	0.0001	846822.9243	0.0001	1290.98	0.0074	GPS	PD:AHTD GPS #080034A
901	753821.891	30	845682.4138	30	1077	0.0037	TBM	PD:SQUARE CUT IN CONCRETE
902	751174.3057	30	846784.741	30	1122.418	0.0052	TBM	PD:TOP OF PIPE
903	748035.5889	30	846979.6935	30	1243.333	0.0068	TBM	PD:PAINT SPOT IN LIP OF MH
904	743468.0749	30	847969.8179	30	1218.045	0.0082	TBM	PD:PAINT SPOT IN LIP MH
999	757971.8629	30	845503.9548	30	1051.9	0.0001	BM	PD:NGS 1ST ORDER BM U5
1105	740444.413	0.0001	849902.3591	0.0001	1145	0.0081	TV	PD:8" SPK
1104	740463.4837	0.0001	850000.2454	0.0001	1145.891	0.0089	TV	PD:8" SPK
1103	740511.2173	0.0001	850184.3946	0.0001	1148.812	0.0096	TV	PD:8" SPK
1102	740538.9382	0.0001	850277.2417	0.0001	1150.122	0.0096	TV	PD:8" SPK
1101	740573.8064	0.0001	850373.934	0.0001	1151.47	0.0094	TV	PD:8" SPK
1100	740639.7556	0.0001	850457.3338	0.0001	1153.096	0.0089	TV	PD:8" SPK
1113	740339.4155	0.0001	849583.1413	0.0001	1144.016	0.005	TV	PD:8" SPK
1112	740266.313	0.0001	849422.1429	0.0001	1139.533	0.0065	TV	PD:8" SPK
1111	740277.8004	0.0001	849303.2359	0.0001	1137.249	0.0073	TV	PD:8" SPK
1110	740261.5178	0.0001	849194.8152	0.0001	1136.1	0.0075	TV	PD:8" SPK
1109	740271.9922	0.0001	849011.018	0.0001	1134.621	0.0073	TV	PD:8" SPK
1106	739927.2186	0.0082	849724.9931	0.0079	1169.156	0.0026	TV	PD:8" SPK
1107	740559.3329	0.0264	850557.7012	0.0116	1154.216	0.0034	TV	PD:8" SPK
1108	740538.8112	0.0235	850488.0738	0.0113	1153.391	0.0034	TV	PD:8" SPK
1114	740083.8419	0.0001	849833.7278	0.0001	1156.635	0.0001	TV	PD:8" SPK
1115	738973.4334	0.0148	849710.3796	0.0284	1229.523	0.0095	TV	PD:8" SPK
1116	738681.7016	0.0395	848971.5637	0.0394	1215.566	0.0116	TV	PD:8" SPK
1117	738973.4344	0.0171	849710.3766	0.0298	1229.523	0.0097	TV	PD:8" SPK

HWY. 221

POINT NO.	TYPE	STATION	NORTHING	EASTING
8000	POB	99+99.99	739366.5227	849699.0182
8001	PI	106+99.08	740065.4466	849713.8325
8002	PI	109+04.01	740270.3761	849714.3215
8003	PI	110+67.66	740433.9915	849717.7151
8004	PI	115+90.71	740956.6590	849737.8202

DETOUR

POINT NO.	TYPE	STATION	NORTHING	EASTING
8006	PC	103+91.40	739757.8448	849707.3126
8008	PT	105+36.47	739902.2011	849695.7272
8009	PC	106+53.39	740017.1988	849674.6394
8011	PT	107+98.13	740161.2296	849663.0472
8012	PC	110+01.17	740364.2301	849667.2577
8014	PT	111+88.27	740548.6589	849695.3868
8015	PC	112+11.44	740570.9179	849701.8349
8017	PT	113+85.85	740742.6692	849729.5888

other markings indicated in the point description of the individual point. AHTD monuments will be stamped "Arkansas Hwy & Trans Dept" with "PN: ###" & "Job

**Standard GPS Control Point Monument - 5/8" x 48" Rebar with 2.5" Aluminum Cap stamped: "(include all common information here)" plus other markings indicated

SX, SY, SZ - Represents the standard error estimate of the coordinate values of each point at the 67% confidence level (one sigma) based on the least squares

Reference Control points (1500 series) shall be used to re-establish horizontal datum if the primary control has been destroyed. These reference control points shall

All additional project control shall be occupied, measured, and adjusted with direct survey ties to at least two of the control points listed in the table above. New

Positional Accuracy: Horizontal - GPS (1.0 cm ± 1PPM) PN: 100-103 (in the above example)
 Horizontal - Primary (2.0 cm ± 20PPM): PN: 1-7 (in the above example)
 Horizontal - Secondary (3 cm ± 50PPM): PN: 1100-1117 (in the above example)
 Vertical - NGS 1st Order (±4mm x vdist in km) PN: 999 (in the above example)
 Vertical - NGS 2nd Order (±6mm x vdist in km) PN: (in the above example)
 Vertical - NGS 3rd Order (±8mm x vdist in km) PN: 1-7, 1100-1105, 1109-1113 (in the above example)

Horizontal Datum: NAD 1983 (1997) State Plane Zone: 0301 - North Zone
 The adjustment year is based on metadata in the SDMS Control file
 A project CAF of: 0.999966288 has been used to compute the above coordinates.
 The project CAF shall have a minimum precision of 9 digits right of the decimal.
 This CAF is intended for use within the project limits only.
 Grid Distance = Ground Distance X CAF
 If Coordinates are listed as Ground:
 To compute Grid Coordinates, multiply the Ground Coordinates by CAF about the origin of X=0 & Y=0
 If Coordinates are listed as Grid:
 To compute Ground Coordinates, divide the Grid Coordinates by CAF about the origin of X=0 & Y=0

Vertical Datum: NAVD 1988 based NGS BM:
 A project Elevation Factor of: #REF! has been computed and incorporated in the above CAF.
 This is based on the average elevation of the project: #REF! Feet
 3-Wire Leveling techniques have been used to establish elevations on
 Points: 1-7, 100-103, 901-904 From NGS BM: U5

Basis of Bearing: Grid Bearings based on AHTD GPS points: 080020, 080028, 080034, & 080034A
 Convergence Angle is: 0°54'51.40" LEFT at PN: 6
 LT: 36-21-26.13 N LG: 093-34-16.3 W
 Grid Azimuth = Astronomical Azimuth - Convergence Angle

Note: Information in Italics is for clarification only. It is not to be part of the actual Control Table or Control Detail Sheets.



SURVEY CONTROL DETAILS

7/21/2016

R090346.DGN

DATE REVISED	DATE FILMED	DATE REVISED	DATE FILMED	FED. RD. DIST. NO.	STATE	FED. AID PROJ. NO.	SHEET NO.	TOTAL SHEETS
				6	ARK.			
				JOB NO.	090346		28	56

2 SURVEY CONTROL DETAILS

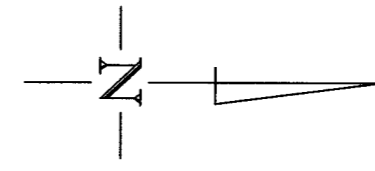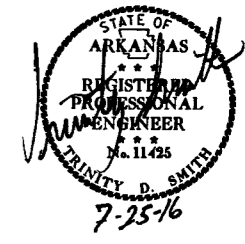


DETOUR
 PI = 107+26.01
 Δ = 11°34'46" RT.
 D = 8°00'00"
 T = 72.62'
 L = 144.74'
 PC = 106+53.39
 PT = 107+98.13
 e = 0.058' /'
 Ls = 200'

DETOUR
 PI = 110+95.26
 Δ = 14°58'02" RT.
 D = 8°00'00"
 T = 94.09'
 L = 187.10'
 PC = 110+01.17
 PT = 111+88.27
 e = 0.058' /'
 Ls = 200'

DETOUR
 PI = 104+64.19
 Δ = 11°36'19" LT.
 D = 8°00'00"
 T = 72.79'
 L = 145.07'
 PC = 103+91.40
 PT = 105+36.47
 NO SUPER

DETOUR
 PI = 112+99.08
 Δ = 13°57'10" LT.
 D = 8°00'00"
 T = 87.64'
 L = 174.41'
 PC = 112+11.44
 PT = 113+85.85
 NO SUPER

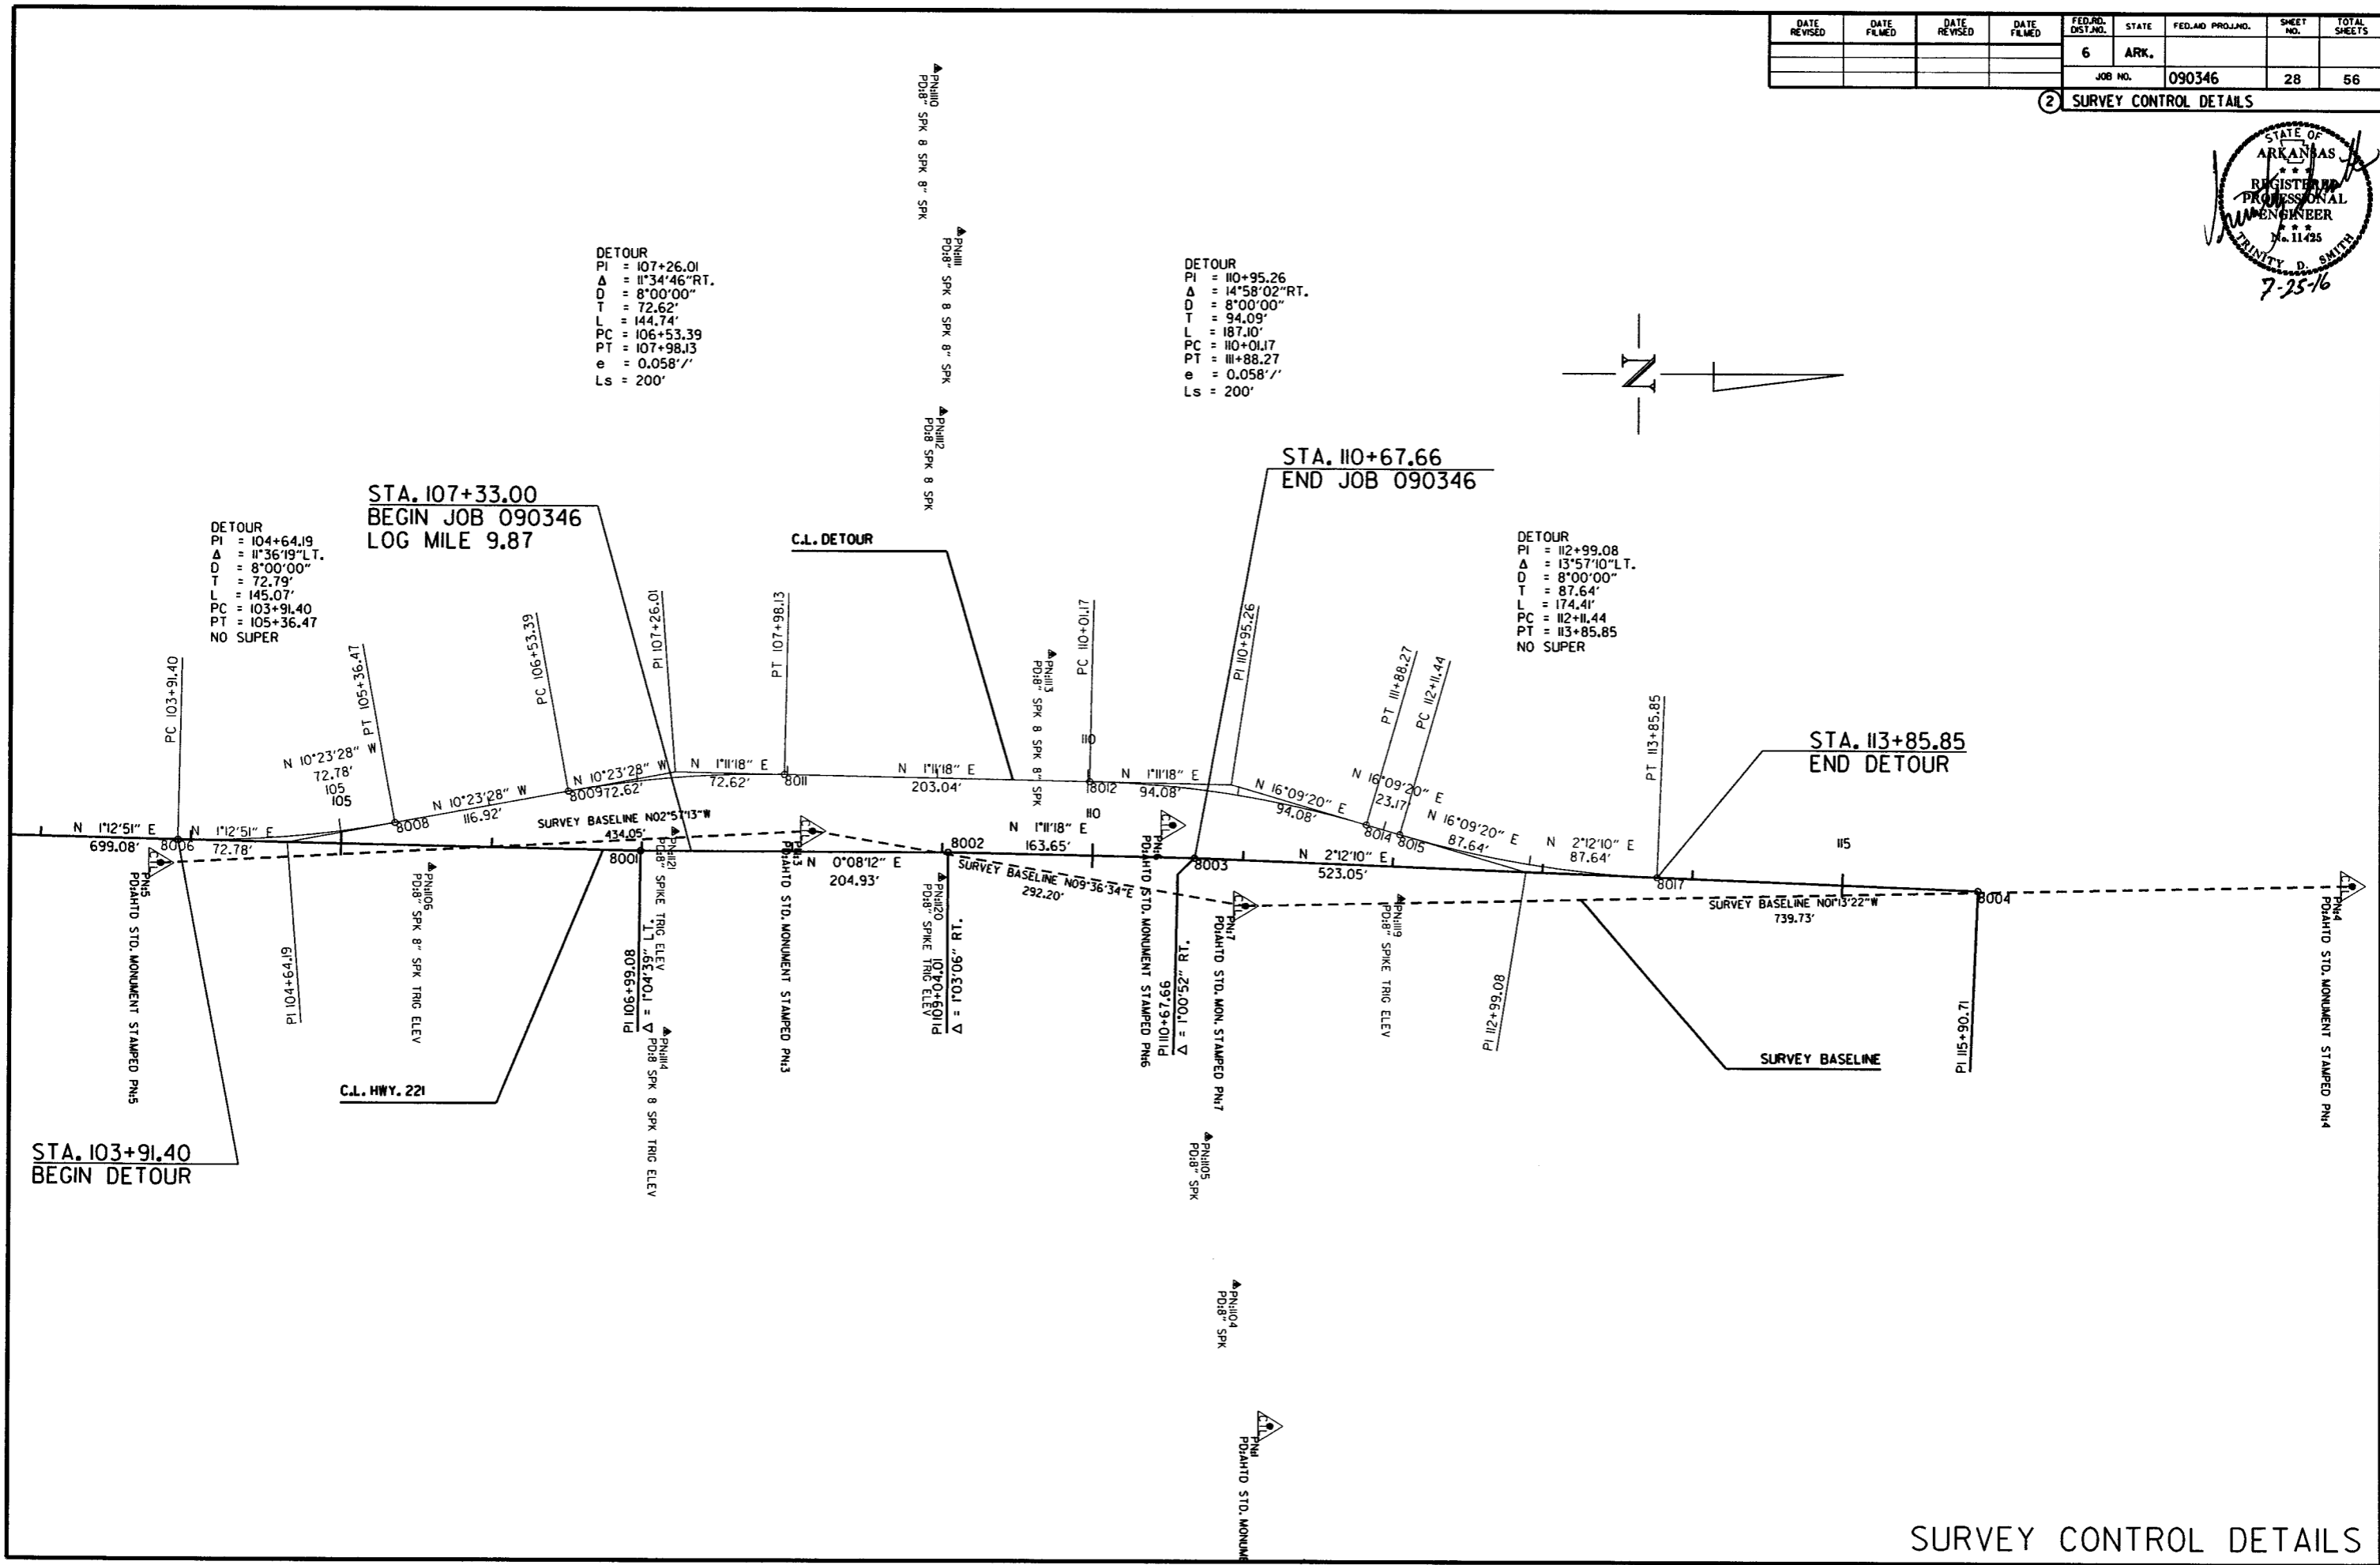

7/21/2016
 R090346.DCN

REMOVAL AND DISPOSAL OF FENCE STA.	STA.	SIDE	LIN. FT.
103+91	109+40	LT.	626
106+82	108+22	RT.	140
108+99	110+08	RT.	131
109+95	113+77	LT.	427

WIRE FENCE STA.	STA.	SIDE	(TYPE D) LIN. FT.
103+91	107+51	LT.	380
106+82	107+28	RT.	60
107+53	108+22	RT.	92
107+77	109+49	LT.	216
108+99	110+08	RT.	216
110+04	113+77	LT.	419

STA. 107+50 TO STA. 110+85
SPECIAL FLOOD HAZARD AREA

STA. 107+33.00 TO STA. 107+51.44 LT. OF C.L.
CONCRETE DITCH PAVING (TYPE B) ("W"=6.33') = 12.97 SQ. YD.


STA. 107+33.00
BEGIN JOB 090346
LOG MILE 9.87

STA. 109+75.69 - STA. 110+08.09 IN PLACE
23' X 33' BRIDGE NO. M2369 CONSISTING OF
STEEL, STRINGER/MULTI-BEAM OR GIRDER
REMOVE AS EXISTING BRIDGE STRUCTURE (SITE NO. 1)
= 1.00 LUMP SUM

STA. 110+67.66
END JOB 090346


DATE REVISED	DATE FILMED	DATE REVISED	DATE FILMED	FED. RD. DIST. NO.	STATE	FED. AID PROJ. NO.	SHEET NO.	TOTAL SHEETS
				6	ARK.		29	56

2 PLAN & PROFILE - HWY. 221

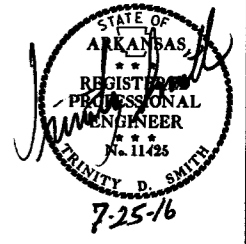

REMOVAL AND DISPOSAL OF GUARDRAIL STA.	STA.	SIDE	LIN. FT.
108+99	109+74	LT.	75
109+21	109+80	RT.	75
110+06	110+81	LT.	75
110+10	110+61	RT.	75

STA. 110+04.05 TO STA. 110+66.67 LT. OF C.L.
CONCRETE DITCH PAVING (TYPE B) ("W"=6.33') = 44.04 SQ. YD.

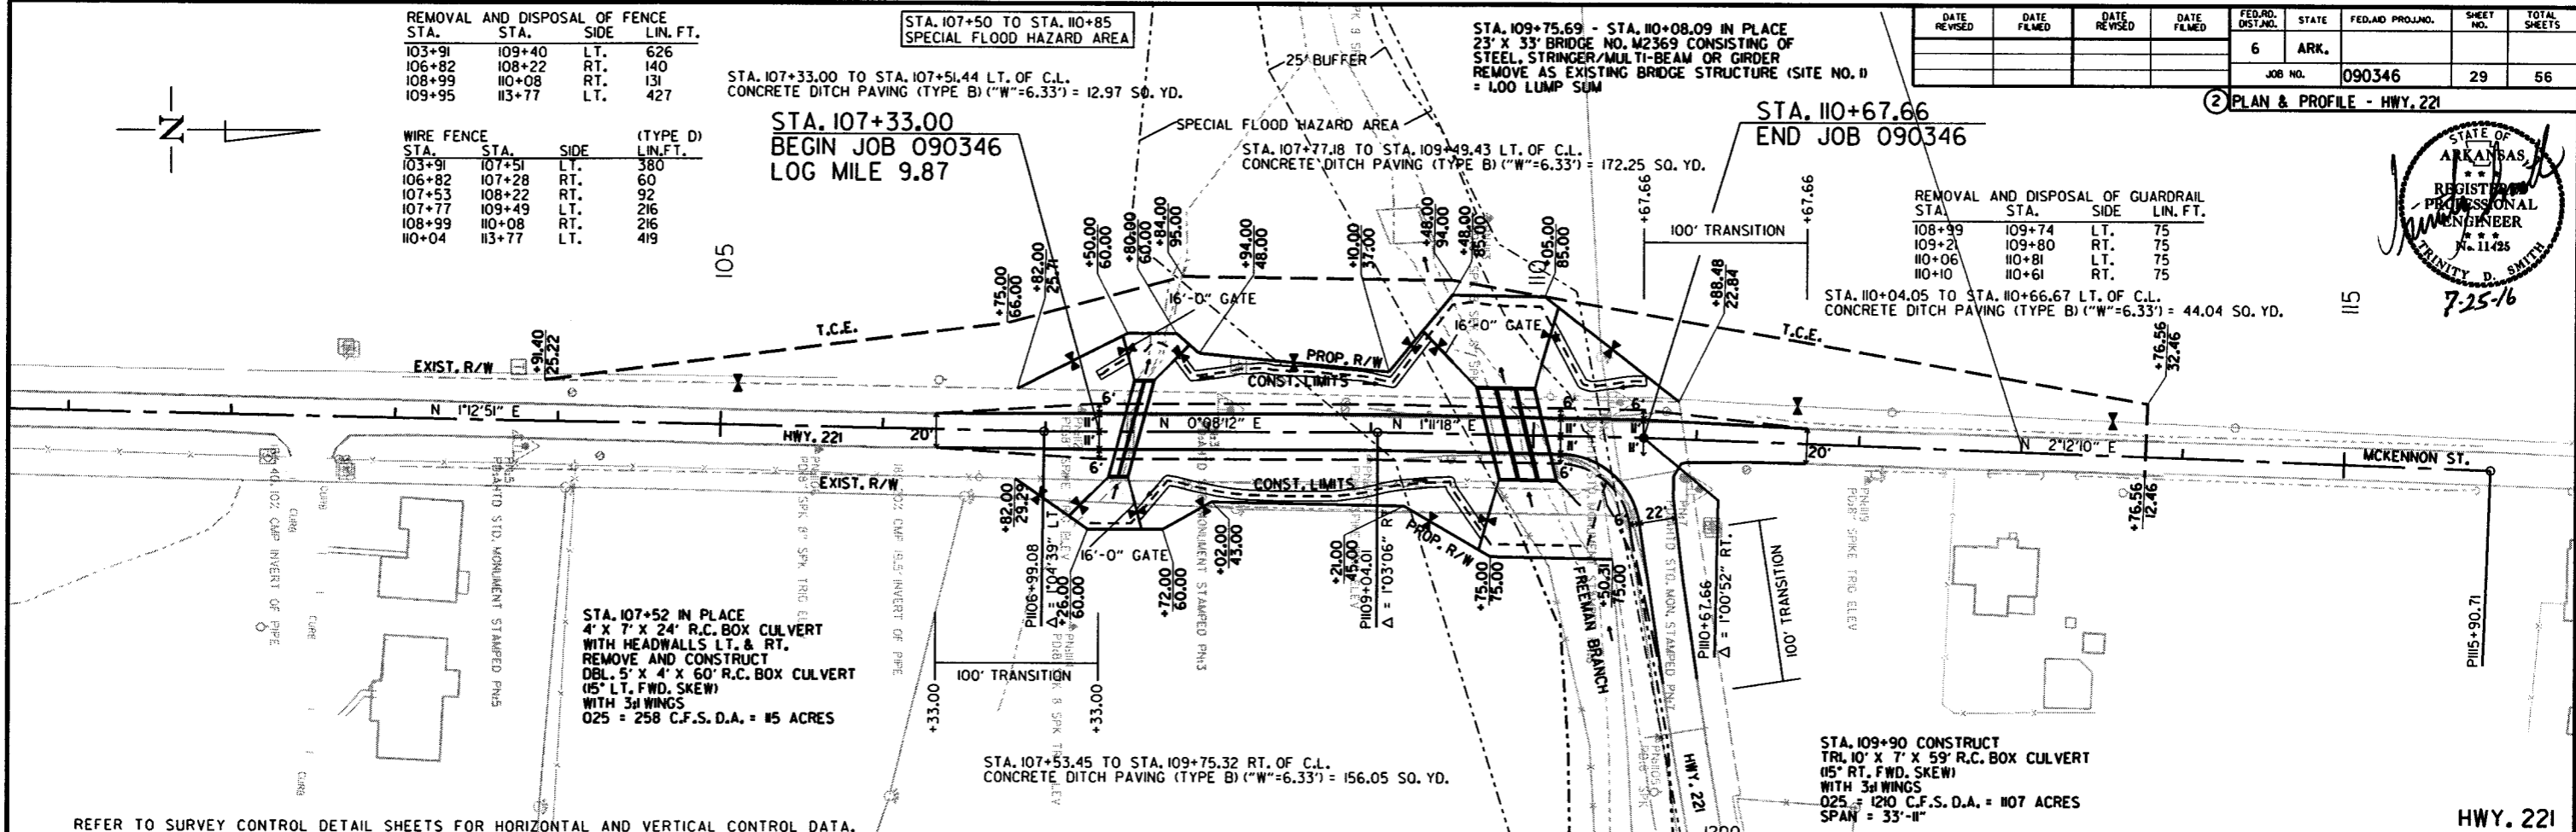


STA. 107+52 IN PLACE
4' X 7' X 24' R.C. BOX CULVERT
WITH HEADWALLS LT. & RT.
REMOVE AND CONSTRUCT
DBL. 5' X 4' X 60' R.C. BOX CULVERT
(15' LT. FWD. SKEW)
WITH 3# WINGS
025 = 258 C.F.S. D.A. = #5 ACRES

STA. 107+53.45 TO STA. 109+75.32 RT. OF C.L.
CONCRETE DITCH PAVING (TYPE B) ("W"=6.33') = 156.05 SQ. YD.

STA. 109+90 CONSTRUCT
TRL 10' X 7' X 59' R.C. BOX CULVERT
(15' RT. FWD. SKEW)
WITH 3# WINGS
025 = 1210 C.F.S. D.A. = #07 ACRES
SPAN = 33'-11"

REFER TO SURVEY CONTROL DETAIL SHEETS FOR HORIZONTAL AND VERTICAL CONTROL DATA.

NOTE: FOR ALL THE CONSTRUCTION OF TEMPORARY WORK RAMP OR HAUL ROADS, THIS STREAM IS CLASSIFIED AS AN INTERMITTENT STREAM. THE STREAMBANK ELEVATION IS 1150.00 FT. M.L.S. BETWEEN STA. 107+50 AND STA. 110+00. REFER TO SECTION 110.06 (C) OF THE 2014 STANDARD SPECIFICATIONS.

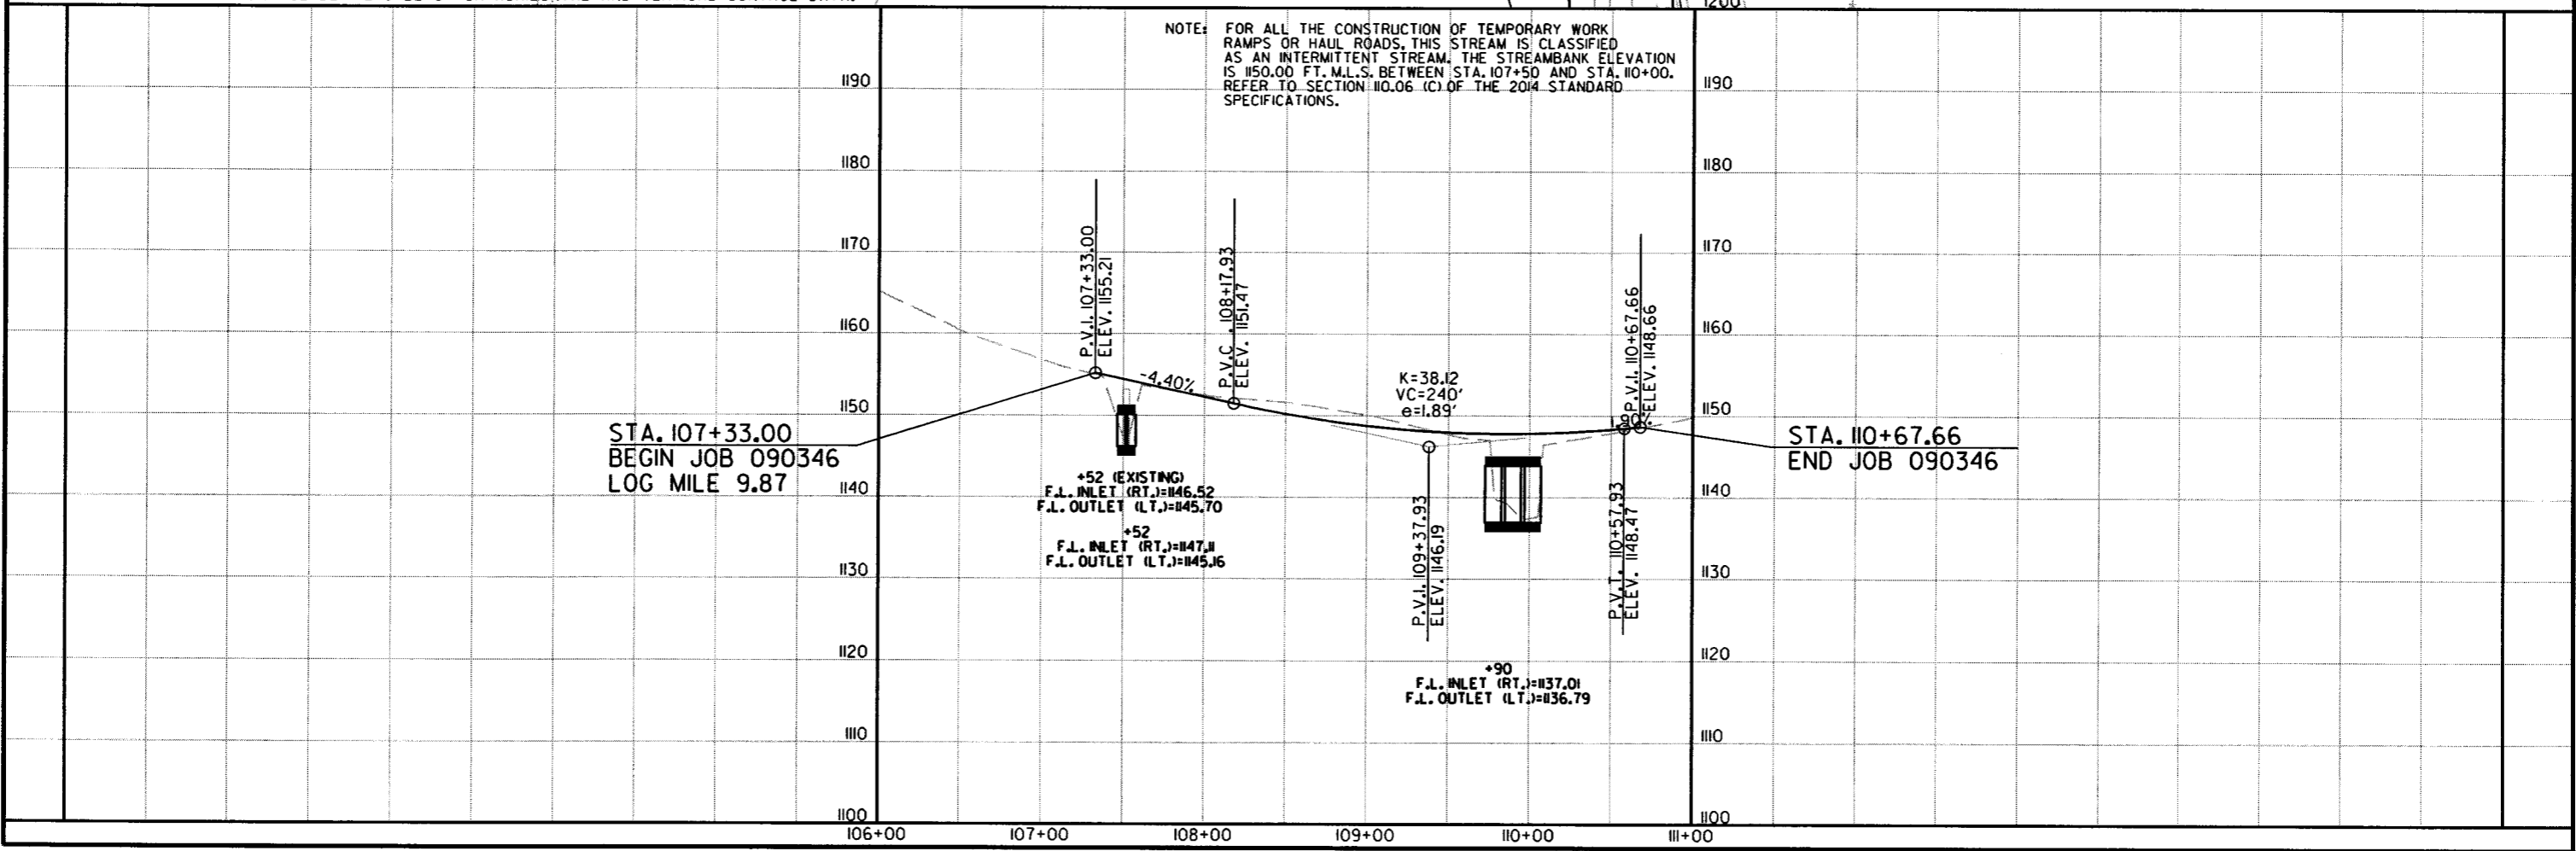

STA. 107+33.00
BEGIN JOB 090346
LOG MILE 9.87



STA. 110+67.66
END JOB 090346

7/21/2016


R090346.DGN

DATE REVISED	DATE FILMED	DATE REVISED	DATE FILMED	FED. RD. DIST. NO.	STATE	FED. AID PROJ. NO.	SHEET NO.	TOTAL SHEETS
				6	ARK.			
JOB NO. 090346							30	56

2 PLAN & PROFILE - DETOUR

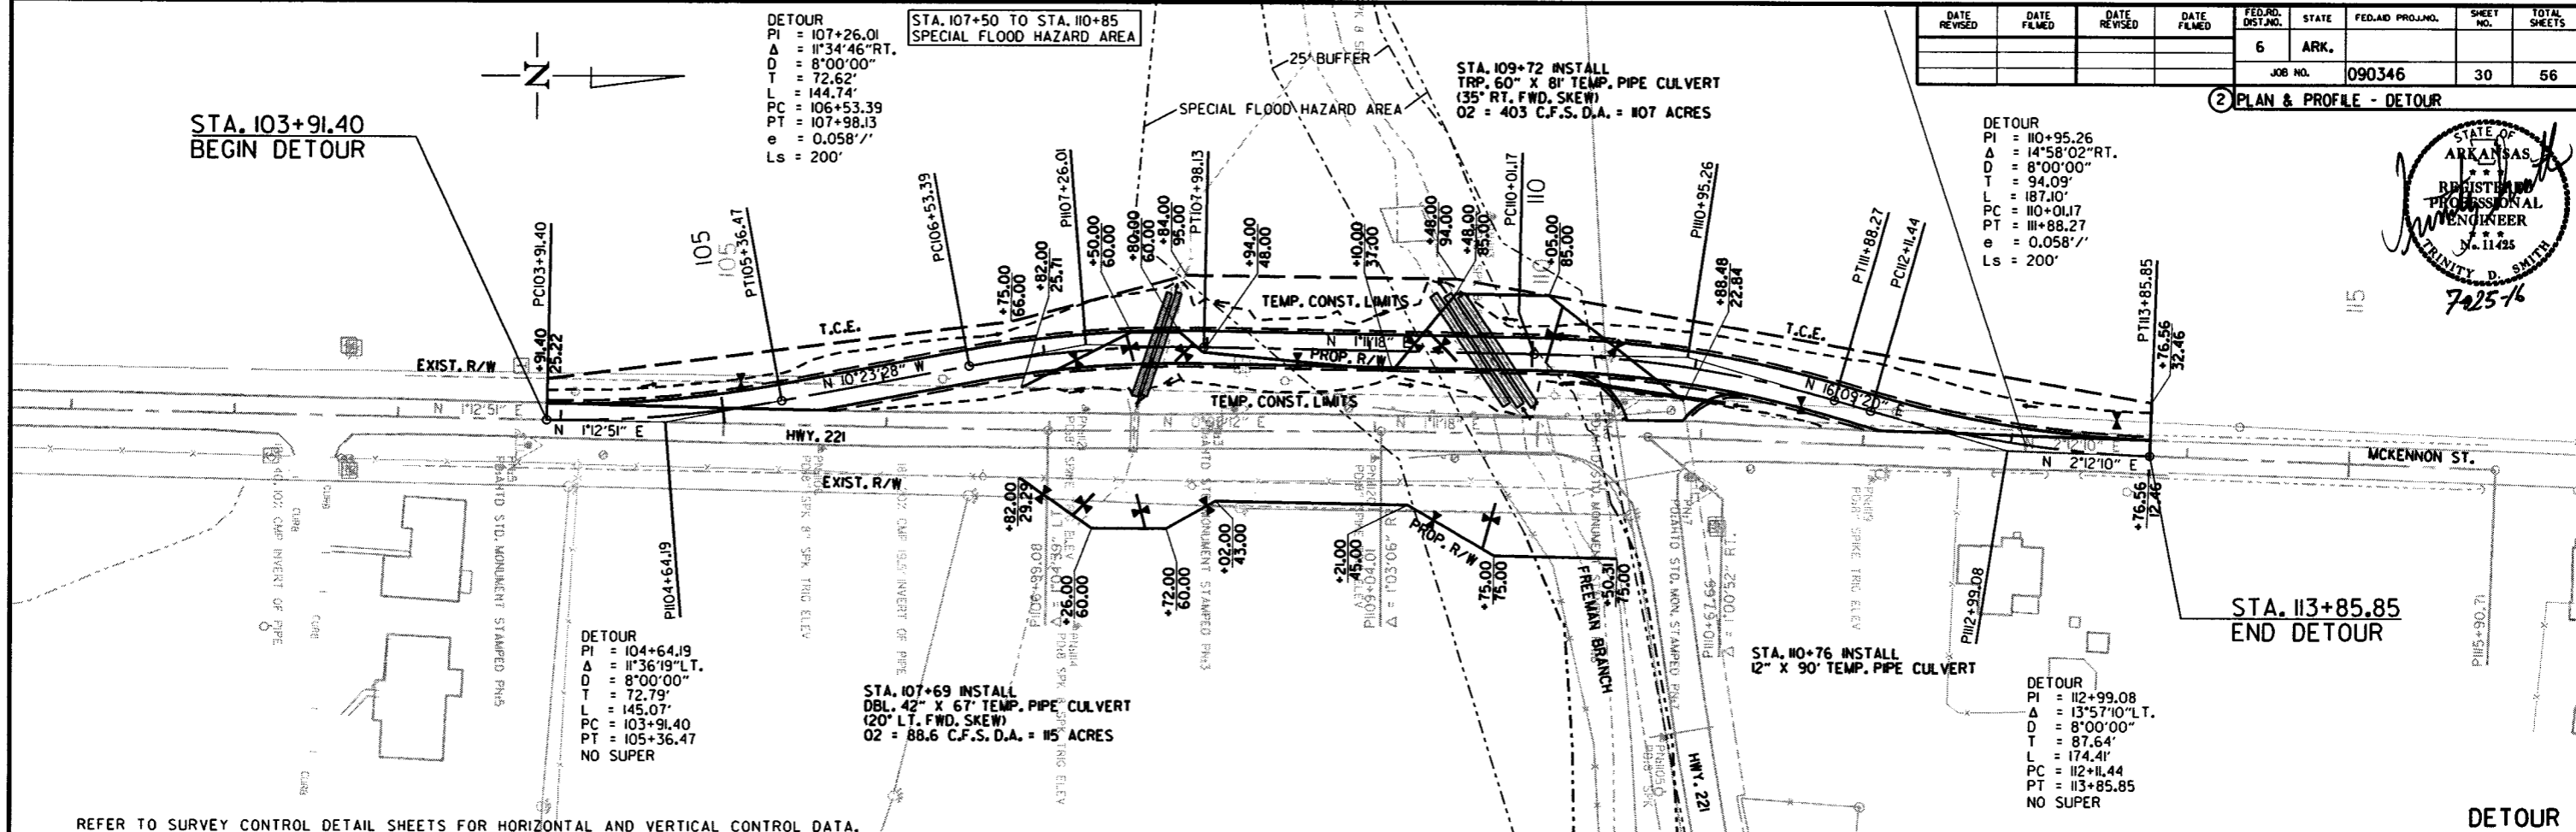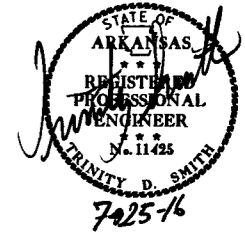

REFER TO SURVEY CONTROL DETAIL SHEETS FOR HORIZONTAL AND VERTICAL CONTROL DATA.

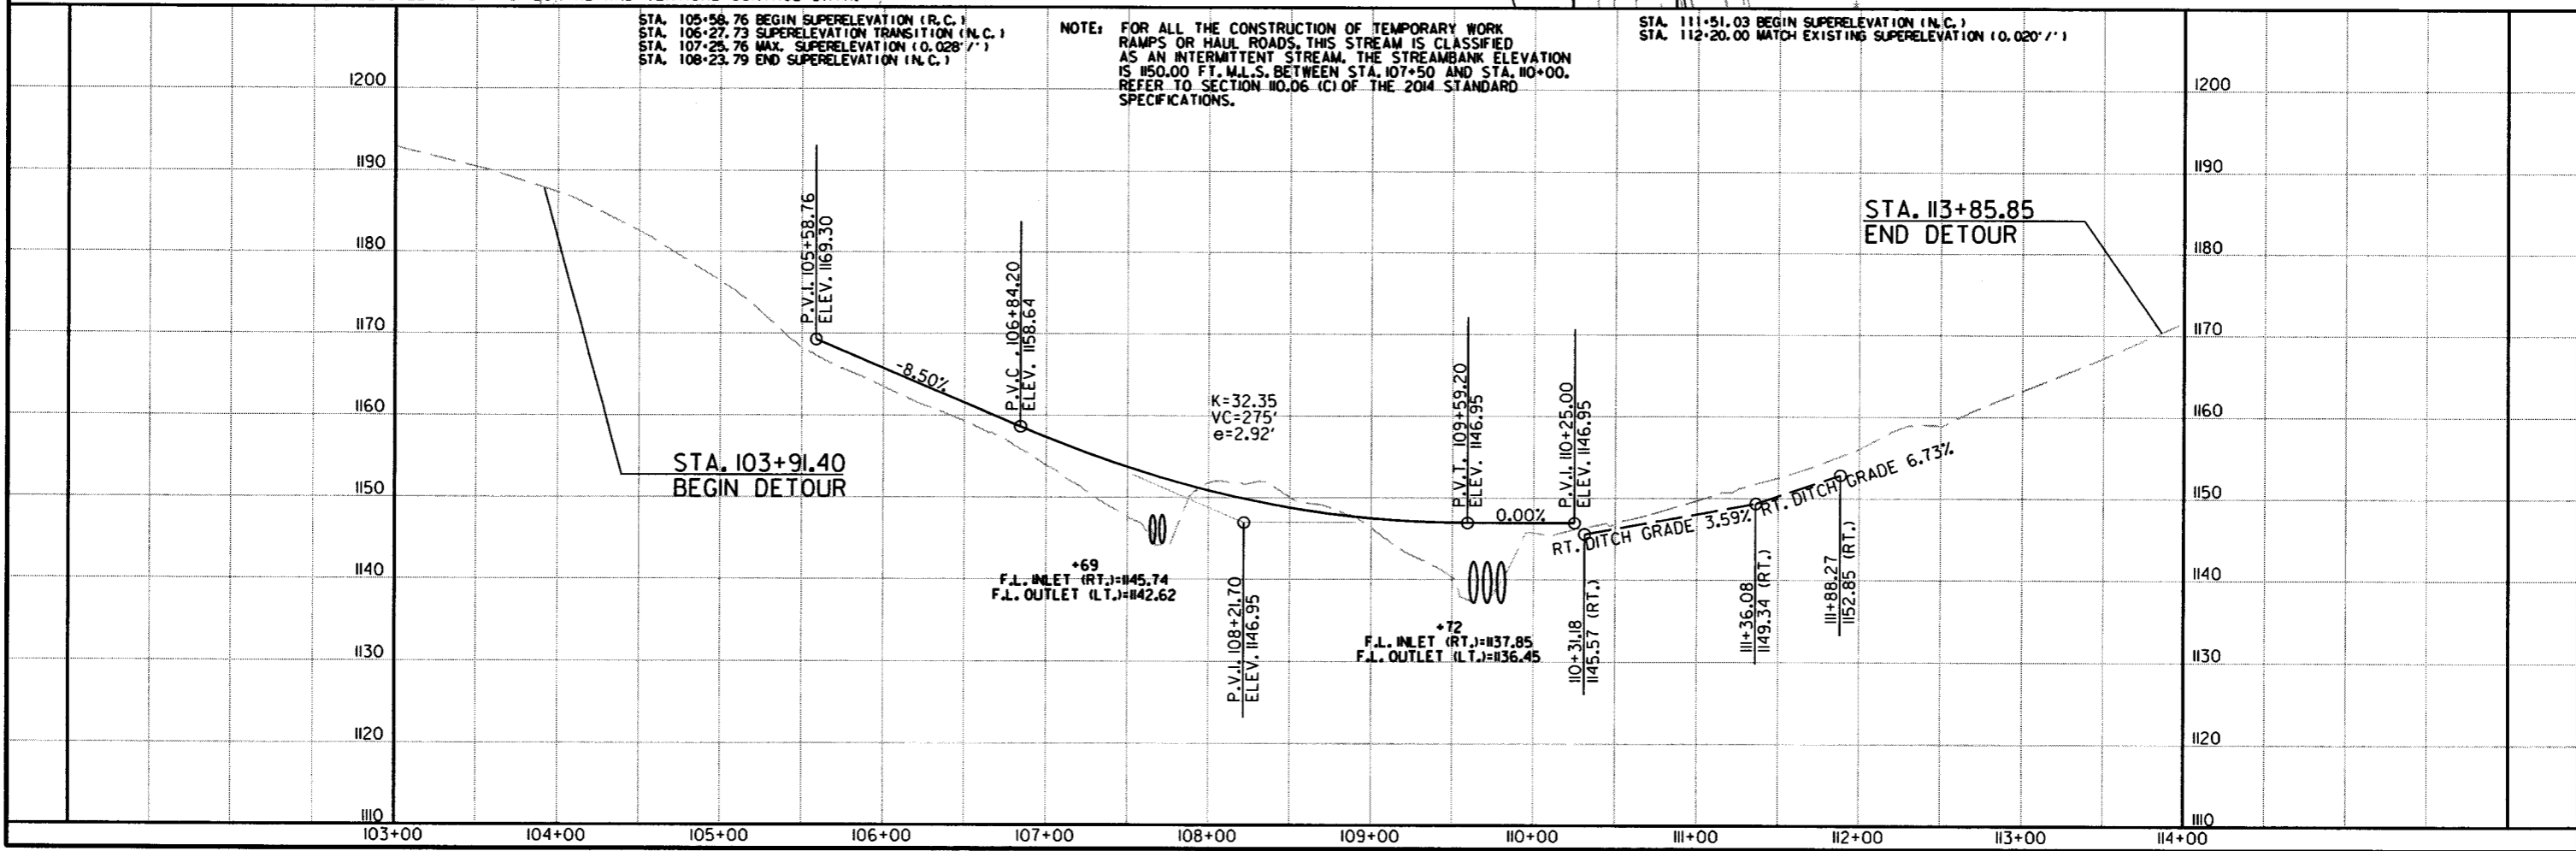


NOTE: FOR ALL THE CONSTRUCTION OF TEMPORARY WORK RAMPS OR HAUL ROADS, THIS STREAM IS CLASSIFIED AS AN INTERMITTENT STREAM, THE STREAMBANK ELEVATION IS 150.00 FT. M.L.S. BETWEEN STA. 107+50 AND STA. 110+00. REFER TO SECTION 10.06 (C) OF THE 2014 STANDARD SPECIFICATIONS.

STA. 105+58.76 BEGIN SUPERELEVATION (N.C.)
 STA. 106+27.73 SUPERELEVATION TRANSITION (N.C.)
 STA. 107+25.76 MAX. SUPERELEVATION (0.028'/'')
 STA. 108+23.79 END SUPERELEVATION (N.C.)


STA. 111+51.03 BEGIN SUPERELEVATION (N.C.)
 STA. 112+20.00 MATCH EXISTING SUPERELEVATION (0.020'/'')

REFER TO TABULATION OF QUANTITIES FOR 'W' & 'B' DIMENSIONS

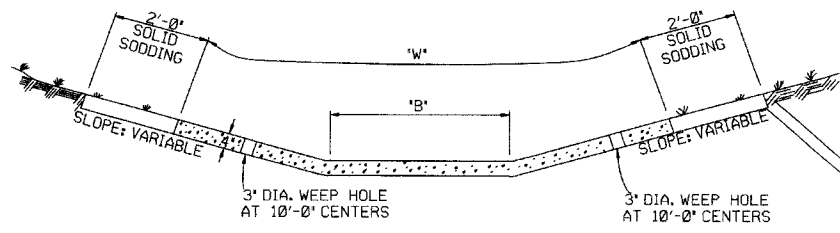

TYPE A


REFER TO TABULATION OF QUANTITIES FOR 'W' DIMENSIONS

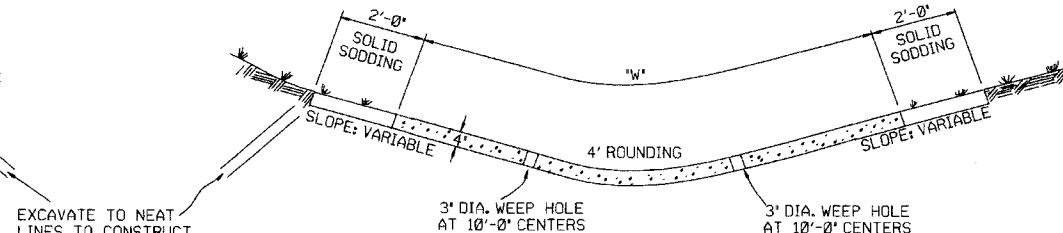

TYPE B


EXCAVATE TO NEAT LINES TO CONSTRUCT DITCH PAVING AND SOLID SODDING.

THE STEEL AND ADDITIONAL CONCRETE FOR THE WALLS SHALL NOT BE PAID FOR DIRECTLY, BUT SHALL BE CONSIDERED TO BE INCLUDED IN THE PRICE BID FOR 'CONCRETE DITCH PAVING.'

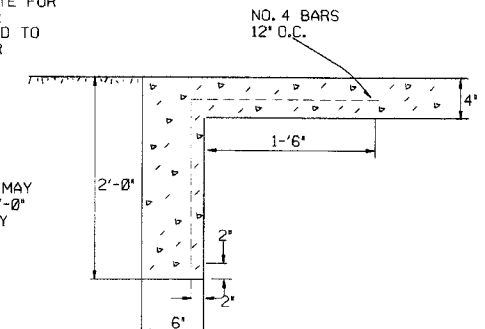


TOE WALL DEPTH MAY BE ALTERED TO 1'-0" WHEN DIRECTED BY THE ENGINEER IN ROCK EXCAVATION

TOE WALL DETAIL FOR CONCRETE DITCH PAVING

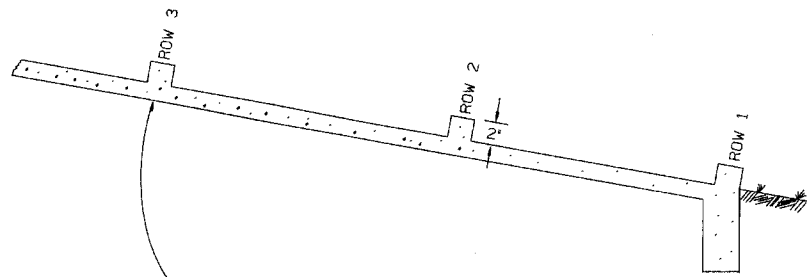

NUMBER OF ELEMENTS PER ROW VARIES WITH WIDTH OF PAVING SPECIFIED

ENERGY DISSIPATORS TO BE USED FOR THE ENTIRE LENGTH OF DITCH WHEN SLOPE OF DITCH PAVING EXCEEDS 7%. THE DISSIPATORS WILL NOT BE PAID FOR DIRECTLY, BUT SHALL BE CONSIDERED TO BE INCLUDED IN THE PRICE BID FOR CONCRETE DITCH PAVING.

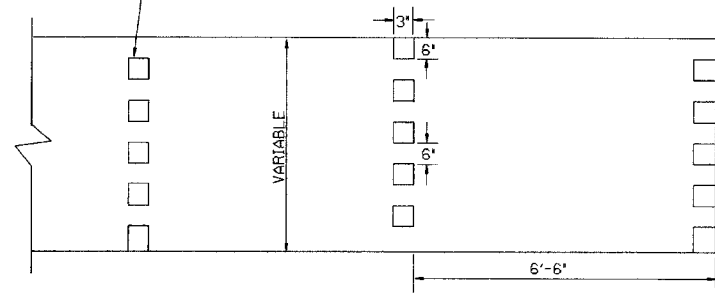

ENERGY DISSIPATORS (NO SCALE)

GENERAL NOTES:

THE FULL WIDTH OF EACH SECTION SHALL BE POURED MONOLITHICALLY.
TOE WALLS TO BE CONSTRUCTED FULL WIDTH AT EACH END OF DITCH PAVING, AND POURED MONOLITHICALLY.

SOLID SOD ALONG DITCH PAVING TO BE PLACED WITHIN 14 DAYS OF DITCH PAVING CONSTRUCTION.

1" WIDE TRANSVERSE EXPANSION JOINTS SHALL BE PLACED IN CONCRETE DITCH PAVING AT 45' INTERVALS. THE SPACE SHALL BE FILLED WITH APPROVED JOINT FILLER COMPLYING WITH AASHTO M213.

11-17-10	ADDED GENERAL NOTE	
6-2-94	ADDED GENERAL NOTE ABOUT SOLID SODDING	
11-30-8	ELIMINATED MIN. ROWS OF ELEMENTS	111-30-89
7-15-89	REVISED DISSIPATOR NOTE	853-7-15-88
4-3-87	REVISED ENERGY DISSIPATOR	871-4-3-87
1-9-87	MODIFIED NOTE ON ENERGY DISS.	832-1-9-87
11-3-86	ADDED NOTE TO ENERGY DISS.	889-12-1-86
11-1-84	ENERGY DISSIPATOR DETAILS	508-11-1-84
	ADDED	
11-1-84	EXCAVATION DETAILS ADDED	
	TYPED A & B	
10-2-72	REVISED AND REDRAWN	508-10-2-72
DATE	REVISION	DATE FILM'D

ARKANSAS STATE HIGHWAY COMMISSION

CONCRETE DITCH PAVING

STANDARD DRAWING CDP-1

REINFORCED CONCRETE ARCH PIPE DIMENSIONS

EQUIV. DIA.	SPAN		RISE	
	AASHTO M 206	AHTD NOMINAL	AASHTO M 206	AHTD NOMINAL
INCHES	INCHES			
15	18	18	11	11
18	22	22	13 1/2	14
21	26	26	15 1/2	16
24	28 1/2	29	18	18
30	36 1/4	36	22 1/2	23
36	43 3/8	44	26 3/8	27
42	51 1/8	51	31 3/8	31
48	58 1/2	59	36	36
54	65	65	40	40
60	73	73	45	45
72	88	88	54	54
84	102	102	62	62
90	115	115	72	72
96	122	122	77 1/2	77
108	138	138	87 1/8	87
120	154	154	96 3/8	97
132	168 1/4	169	106 1/2	107

THE MEASURED SPAN AND RISE SHALL NOT VARY MORE THAN ± 2 PERCENT FROM THE VALUES SPECIFIED BY AASHTO M206.

REINFORCED CONCRETE HORIZONTAL ELLIPTICAL PIPE DIMENSIONS

EQUIV. DIA.	AASHTO M 207	
	SPAN	RISE
INCHES	INCHES	
18	23	14
24	30	19
27	34	22
30	38	24
33	42	27
36	45	29
39	49	32
42	53	34
48	60	38
54	68	43
60	76	48
66	83	53
72	91	58
78	98	63
84	106	68

THE MEASURED SPAN AND RISE SHALL NOT VARY MORE THAN ± 2 PERCENT FROM THE VALUES SPECIFIED BY AASHTO M207.

CONSTRUCTION SEQUENCE

1. PLACE STRUCTURAL BEDDING MATERIAL TO GRADE. DO NOT COMPACT.
2. INSTALL PIPE TO GRADE.
3. COMPACT STRUCTURAL BEDDING OUTSIDE THE MIDDLE THIRD OF THE PIPE.
4. PLACE AND COMPACT THE HAUNCH AREA UP TO THE MIDDLE OF THE PIPE.
5. COMPLETE BACKFILL ACCORDING TO SUBSECTION 606.03.(F)(II).

NOTE: HAUNCH AND STRUCTURAL BEDDING MATERIAL WILL NOT BE PAID FOR SEPARATELY, BUT COMPENSATION WILL BE CONSIDERED TO BE INCLUDED IN THE PRICE BID PER LINEAR FOOT OF CONCRETE PIPE.


- LEGEND -

- D₁ = NORMAL INSIDE DIAMETER OF PIPE
- D₀ = OUTSIDE DIAMETER OF PIPE
- H = FILL COVER HEIGHT OVER PIPE (FEET)
- MIN. = MINIMUM
- [Symbol] = UNDISTURBED SOIL

INSTALLATION TYPE	MATERIAL REQUIREMENTS FOR HAUNCH AND STRUCTURAL BEDDING
TYPE 1	AGGREGATE BASE COURSE (CLASS 5 OR CLASS 7)
TYPE 2	SELECTED MATERIALS (CLASS SM-1, SM-2, OR SM-4) OR TYPE 1 INSTALLATION MATERIAL*
TYPE 3**	AASHTO CLASSIFICATION A-1 THRU A-6 SOIL OR TYPE 1 OR 2 INSTALLATION MATERIAL

* SM-3 WILL NOT BE ALLOWED.

** MATERIALS SHALL NOT INCLUDE ORGANIC MATERIALS OR STONES LARGER THAN 3 INCHES.

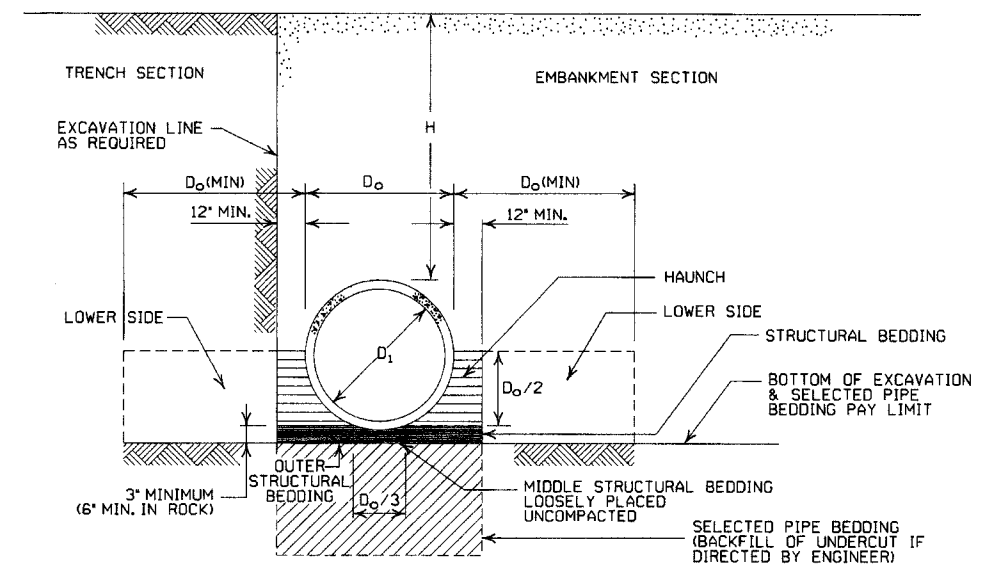

EMBANKMENT AND TRENCH INSTALLATIONS

1. MATERIAL IN THE HAUNCH AND OUTER STRUCTURAL BEDDING SHALL BE COMPACTED TO 95% OF THE MAXIMUM DENSITY ACCORDING TO THE TYPE OR CLASS OF MATERIAL USED.
2. FOR TRENCHES WITH WALLS OF NATURAL SOIL, THE DENSITY OF THE SOIL IN THE LOWER SIDE ZONE SHALL BE AS FIRM AS THE 95% DENSITY REQUIRED FOR THE HAUNCH. IF THE EXISTING SOIL DOES NOT MEET THIS CRITERIA, IT SHALL BE REMOVED AND RECOMPACTED TO 95% OF THE MAXIMUM DENSITY ACCORDING TO THE TYPE OF MATERIAL USED.
3. FOR EMBANKMENTS, THE MATERIAL IN THE LOWER SIDE ZONE SHALL BE COMPACTED TO 95% OF THE MAXIMUM DENSITY ACCORDING TO THE TYPE OR CLASS OF MATERIAL USED.

GENERAL NOTES

1. CONCRETE PIPE CULVERT CONSTRUCTION SHALL CONFORM TO ARKANSAS STATE HIGHWAY AND TRANSPORTATION DEPARTMENT STANDARD SPECIFICATIONS FOR HIGHWAY CONSTRUCTION (CURRENT EDITION), WITH APPLICABLE SUPPLEMENTAL SPECIFICATIONS AND SPECIAL PROVISIONS. UNLESS OTHERWISE NOTED IN THE PLANS, SECTION AND SUBSECTION REFER TO THE STANDARD CONSTRUCTION SPECIFICATIONS.
2. CONCRETE PIPE CULVERT DESIGN SHALL CONFORM TO AASHTO LRFD BRIDGE DESIGN SPECIFICATIONS, FIFTH EDITION (2010) WITH 2010 INTERIMS.
3. ALL PIPE SHALL CONFORM TO SECTION 606. CIRCULAR R.C. PIPE CULVERTS SHALL CONFORM TO AASHTO M170, R.C. ARCH PIPE CULVERTS SHALL CONFORM TO AASHTO M206 AND HORIZONTAL ELLIPTICAL PIPE CULVERTS SHALL CONFORM TO AASHTO M207.
4. ALL PIPE SHALL BE PROTECTED DURING CONSTRUCTION BY A COVER SUFFICIENT TO PREVENT DAMAGE FROM PASSAGE OF EQUIPMENT.
5. THE MINIMUM TRENCH WIDTH SHALL BE THE OUTSIDE DIAMETER OF THE PIPE PLUS 24 INCHES. THE MAXIMUM ALLOWABLE TRENCH WIDTH SHALL BE THE MINIMUM WIDTH PRACTICABLE FOR WORKING CONDITIONS.
6. MULTIPLE PIPE CULVERTS SHALL BE INSTALLED WITH A MINIMUM CLEARANCE OF 24 INCHES BETWEEN STRINGS OF PIPE. REFER TO STD. DWG. FES-2 FOR MINIMUM CLEARANCE WHERE FLARED END SECTIONS ARE USED.
7. IMPERVIOUS MATERIAL SHOULD BE PLACED AS DIRECTED BY THE ENGINEER AT THE ENDS OF THE CULVERT TO PREVENT LOSS OF STRUCTURAL BEDDING WHEN PERVIOUS MATERIAL IS USED FOR STRUCTURAL BEDDING AND/OR BACKFILL.
8. NOT MORE THAN ONE LIFTING HOLE MAY BE PROVIDED IN CONCRETE PIPE TO FACILITATE HANDLING. HOLE MAY BE CAST IN PLACE, CUT INTO THE FRESH CONCRETE AFTER FORMS ARE REMOVED, OR DRILLED. THE HOLE SHALL NOT BE MORE THAN TWO INCHES IN DIAMETER OR TWO INCHES SQUARE. CUTTING OR DISPLACEMENT OF REINFORCEMENT WILL NOT BE PERMITTED. SPALLED AREAS AROUND THE HOLE SHALL BE REPAIRED IN A WORKMANLIKE MANNER. LIFTING HOLE SHALL BE FILLED WITH MORTAR, CONCRETE, OR OTHER METHOD AS APPROVED BY THE ENGINEER.
9. WHEN DIRECTED BY THE ENGINEER, UNSUITABLE MATERIAL THAT IS ENCOUNTERED AT THE BOTTOM OF THE EXCAVATED TRENCH (BELOW THE AREA IDENTIFIED AS "STRUCTURAL BEDDING" ABOVE) WILL BE EXCAVATED AND REPLACED WITH SELECTED PIPE BEDDING. THE QUANTITY OF MATERIAL REQUIRED TO BACKFILL THE UNDERCUT AREA UP TO THE SELECTED PIPE BEDDING PAY LIMIT DESIGNATED ABOVE WILL BE MEASURED AND PAID FOR AS "SELECTED PIPE BEDDING."
10. WHEN THE EXISTING MATERIAL EXCAVATED FOR THE PIPE TRENCH IS DETERMINED BY THE ENGINEER TO BE UNSUITABLE FOR BACKFILLING THE PIPE (ABOVE THE AREA IDENTIFIED ABOVE AS THE HAUNCH), BORROW MATERIAL OR MATERIAL FROM THE ROADWAY EXCAVATION WILL BE USED TO BACKFILL THE PIPE. IF SUITABLE MATERIAL IS NOT AVAILABLE, THE ENGINEER MAY AUTHORIZE THE USE OF "SELECTED PIPE BACKFILL."

MINIMUM HEIGHT OF FILL "H" OVER CIRCULAR R.C. PIPE CULVERTS

INSTALLATION TYPE	CLASS OF PIPE			
	TYPE 1 OR 2	TYPE 3	ALL	ALL
PIPE ID (IN.)	FEET			
12-15	2	2.5	2	1
18-24	2.5	3	2	1
27-33	3	4	2	1
36-42	3.5	5	2	1
48	4.5	5.5	2	1
54-60	5	7	2	1
66-78	6	8	2	1
84-108	7.5	8	2	1

NOTE: FOR MINIMUM COVER VALUES, "H" SHALL INCLUDE A MINIMUM OF 12" OF PAVEMENT AND/OR BASE.

MAXIMUM HEIGHT OF FILL "H" OVER CIRCULAR R.C. PIPE CULVERTS

INSTALLATION TYPE	CLASS OF PIPE		
	CLASS III	CLASS IV	CLASS V
TYPE 1	21	32	50
TYPE 2	16	25	39
TYPE 3	12	20	30

NOTE: IF FILL HEIGHT EXCEEDS 50 FEET, A SPECIAL DESIGN CONCRETE PIPE WILL BE REQUIRED USING TYPE 1 INSTALLATION.

MINIMUM HEIGHT OF FILL "H" OVER R.C. ARCH & HORIZONTAL ELLIPTICAL PIPE CULVERTS

INSTALLATION TYPE	CLASS OF PIPE	
	CLASS III	CLASS IV
TYPE 2 OR TYPE 3	FEET	
	2.5	1.5

NOTE: TYPE 1 INSTALLATION WILL NOT BE ALLOWED FOR ARCH & HORIZONTAL ELLIPTICAL PIPE CULVERTS.

NOTE: FOR MINIMUM COVER VALUES, "H" SHALL INCLUDE A MINIMUM OF 12" OF PAVEMENT AND/OR BASE.

MAXIMUM HEIGHT OF FILL "H" OVER R.C. ARCH & HORIZONTAL ELLIPTICAL PIPE CULVERTS

INSTALLATION TYPE	CLASS OF PIPE	
	CLASS III	CLASS IV
TYPE 2	13	21
TYPE 3	10	16

NOTE: TYPE 1 INSTALLATION WILL NOT BE ALLOWED FOR ARCH & HORIZONTAL ELLIPTICAL PIPE CULVERTS.

DATE	REVISION	DATE FILMED
2-27-14	REVISED GENERAL NOTE 1.	
12-15-11	REVISED FOR LRFD DESIGN SPECIFICATIONS	
5-18-00	REVISED TYPE 3 BEDDING & ADDED NOTE	
3-30-00	REVISED INSTALLATIONS	
11-06-97	ISSUED	

ARKANSAS STATE HIGHWAY COMMISSION

CONCRETE PIPE CULVERT
FILL HEIGHTS & BEDDING

STANDARD DRAWING PCC-1

CORRUGATED STEEL PIPE (ROUND)

PIPE DIAMETER (INCHES)	① MINIMUM COVER TOP OF PIPE TO TOP OF GROUND "H" (FEET)	MAX. FILL HEIGHT "H" ABOVE TOP OF PIPE (FEET)				
		METAL THICKNESS (INCHES)				
		0.064	0.079	0.109	0.138	0.168
2 3/4 INCH BY 1/2 INCH CORRUGATION RIVETED, WELDED, OR HELICAL LOCK-SEAM						
12	1	84	91			
15	1	67	73			
18	1	56	61			
24	1	46	46	59		
30	2	42	38	47		
36	2	32	30	39	41	
42	2	26	43	67	70	73
48	2	24	37	58	61	64
② 3 INCH BY 1 INCH OR 5 INCH BY 1 INCH CORRUGATION RIVETED, WELDED, BOLTED, OR HELICAL LOCK-SEAM						
36	1	48	60	88	111	118
42	1	41	51	72	90	102
48	1	36	45	64	77	85
54	2	32	40	59	71	79
60	2	29	36	53	64	71
66	2	26	33	47	58	64
72	2	24	30	44	53	59
78	2		28	41	49	54
84	2		26	38	45	51
90	2		24	35	43	45
96	2		22	33	40	44
102	2			31	38	42
108	2			30	35	39
114	2			28	34	37
120	2			27	32	35


CONSTRUCTION SEQUENCE

1. PLACE STRUCTURAL BEDDING MATERIAL TO GRADE. DO NOT COMPACT.
2. INSTALL PIPE TO GRADE.
3. COMPACT STRUCTURAL BEDDING OUTSIDE THE MIDDLE THIRD OF THE PIPE.
4. COMPLETE STRUCTURAL BACKFILL OPERATION BY WORKING FROM SIDE TO SIDE OF THE PIPE. THE SIDE TO SIDE STRUCTURAL BACKFILL DIFFERENTIAL SHALL NOT EXCEED 24 INCHES OR 1/3 THE SIZE OF THE PIPE, WHICHEVER IS LESS.

NOTE: STRUCTURAL BACKFILL AND STRUCTURAL BEDDING MATERIAL WILL NOT BE PAID FOR SEPARATELY, BUT COMPENSATION WILL BE CONSIDERED TO BE INCLUDED IN THE PRICE BID PER LINEAR FOOT OF METAL PIPE.

INSTALLATION TYPE	MATERIAL REQUIREMENTS FOR STRUCTURAL BACKFILL AND STRUCTURAL BEDDING
TYPE 1	AGGREGATE BASE COURSE (CLASS 4, 5, 6, OR 7)
TYPE 2	SELECTED MATERIALS (CLASS SM-1, SM-2, OR SM-4) OR TYPE 1 INSTALLATION MATERIAL ③

③ SM-3 WILL NOT BE ALLOWED.

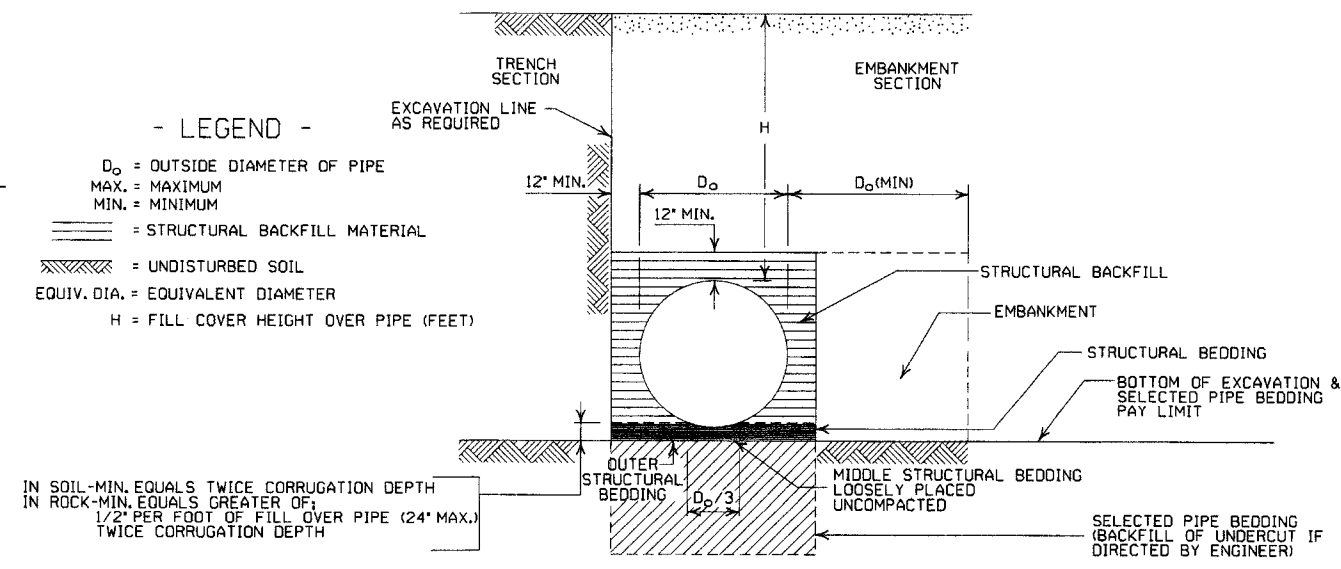

IN SOIL - MIN. EQUALS TWICE CORRUGATION DEPTH
IN ROCK - MIN. EQUALS GREATER OF:
1/2" PER FOOT OF FILL OVER PIPE (24" MAX.)
TWICE CORRUGATION DEPTH

EMBANKMENT AND TRENCH INSTALLATIONS

1. STRUCTURAL BACKFILL, EMBANKMENT, AND OUTER STRUCTURAL BEDDING MATERIAL SHALL BE COMPACTED TO 95% OF THE MAXIMUM DENSITY ACCORDING TO THE TYPE OR CLASS OF MATERIAL USED.
2. INSTALLATION TYPE 1 OR 2 MAY BE USED FOR CORRUGATED STEEL OR ALUMINUM PIPE (ROUND).
3. INSTALLATION TYPE 1 SHALL BE USED FOR CORRUGATED STEEL OR ALUMINUM PIPE ARCHES WITH 2 3/8" X 1/2" CORRUGATION.
4. INSTALLATION TYPE 1 OR 2 MAY BE USED FOR CORRUGATED STEEL OR ALUMINUM PIPE ARCHES WITH 3" X 1" OR 5" X 1" CORRUGATION.

GENERAL NOTES

1. METAL PIPE CULVERT CONSTRUCTION SHALL CONFORM TO ARKANSAS STATE HIGHWAY AND TRANSPORTATION DEPARTMENT STANDARD SPECIFICATIONS FOR HIGHWAY CONSTRUCTION (CURRENT EDITION), WITH APPLICABLE SUPPLEMENTAL SPECIFICATIONS AND SPECIAL PROVISIONS. UNLESS OTHERWISE NOTED IN THE PLANS, SECTION AND SUBSECTION REFER TO THE STANDARD CONSTRUCTION SPECIFICATIONS.
2. METAL PIPE CULVERT DESIGN SHALL CONFORM TO AASHTO LRFD BRIDGE DESIGN SPECIFICATIONS, FIFTH EDITION (2010) WITH 2010 INTERIMS.
3. METAL PIPE CULVERT MATERIALS AND INSTALLATIONS SHALL CONFORM TO SECTION 606 AND JOB SPECIAL PROVISION "METAL PIPE".
4. ALL PIPE SHALL BE PROTECTED DURING CONSTRUCTION BY A COVER SUFFICIENT TO PREVENT DAMAGE FROM PASSAGE OF EQUIPMENT.
5. THE MINIMUM TRENCH WIDTH SHALL BE THE OUTSIDE DIAMETER OF THE PIPE PLUS 24 INCHES. THE MAXIMUM ALLOWABLE TRENCH WIDTH SHALL BE THE MINIMUM WIDTH PRACTICABLE FOR WORKING CONDITIONS.
6. MULTIPLE PIPE CULVERTS SHALL BE INSTALLED WITH A MINIMUM CLEARANCE OF 24 INCHES BETWEEN STRINGS OF PIPE. REFER TO STD. DWG. FES-2 FOR MINIMUM CLEARANCE WHERE FLARED END SECTIONS ARE USED.
7. IMPERVIOUS MATERIAL SHOULD BE PLACED AS DIRECTED BY THE ENGINEER AT THE ENDS OF THE CULVERT TO PREVENT LOSS OF STRUCTURAL BEDDING WHEN PERVIOUS MATERIAL IS USED FOR STRUCTURAL BEDDING AND/OR BACKFILL.
8. WHEN DIRECTED BY THE ENGINEER, UNSUITABLE MATERIAL THAT IS ENCOUNTERED AT THE BOTTOM OF THE EXCAVATED TRENCH (BELOW THE AREA IDENTIFIED AS "STRUCTURAL BEDDING" ABOVE) WILL BE EXCAVATED AND REPLACED WITH SELECTED PIPE BEDDING. THE QUANTITY OF MATERIAL REQUIRED TO BACKFILL THE UNDERCUT AREA UP TO THE SELECTED PIPE BEDDING PAY LIMIT DESIGNATED ABOVE WILL BE MEASURED AND PAID FOR AS "SELECTED PIPE BEDDING."
9. WHEN THE EXISTING MATERIAL EXCAVATED FOR THE PIPE TRENCH IS DETERMINED BY THE ENGINEER TO BE UNSUITABLE FOR BACKFILLING THE PIPE (ABOVE THE AREA IDENTIFIED AS STRUCTURAL BACKFILL), BORROW MATERIAL OR MATERIAL FROM THE ROADWAY EXCAVATION WILL BE USED TO BACKFILL THE PIPE. IF SUITABLE MATERIAL IS NOT AVAILABLE, THE ENGINEER MAY AUTHORIZE THE USE OF "SELECTED PIPE BACKFILL."

CORRUGATED ALUMINUM PIPE (ROUND)

PIPE DIAMETER (INCHES)	① MINIMUM COVER TOP OF PIPE TO TOP OF GROUND "H" (FEET)	MAX. FILL HEIGHT "H" ABOVE TOP OF PIPE (FEET)				
		METAL THICKNESS IN INCHES				
		0.060	0.075	0.105	0.135	0.164
2 3/4 INCH BY 1/2 INCH CORRUGATION RIVETED OR HELICAL LOCK-SEAM						
12	1	45	45			
18	2	30	30	52		
24	2	22	22	39	41	
30	2		18	31	32	34
36	2.5		15	26	27	28
42	2			43	43	44
48	2			40	41	43
54	2			35	37	38
60	2				33	34
66	2					31
72	2					29

EQUIVALENT METAL THICKNESSES AND GAUGES

METAL THICKNESS IN INCHES			GAUGE NUMBER
STEEL			
ZINC COATED	UNCOATED	ALUMINUM	
0.064	0.0598	0.060	16
0.079	0.0747	0.075	14
0.109	0.1046	0.105	12
0.138	0.1345	0.135	10
0.168	0.1644	0.164	8

CORRUGATED METAL PIPE ARCHES

EQUIV. DIA. (INCHES)	PIPE DIMENSION SPAN X RISE (INCHES)	MINIMUM CORNER RADIUS (INCHES)	STEEL				ALUMINUM			
			MIN. THICKNESS REQUIRED INCHES	① MIN. HEIGHT OF FILL, "H" (FT.)		MIN. THICKNESS REQUIRED INCHES	① MIN. HEIGHT OF FILL, "H" (FT.)			
				INSTALLATION TYPE 1	INSTALLATION TYPE 1		INSTALLATION TYPE 1	INSTALLATION TYPE 1		
			2 3/4 INCH BY 1/2 INCH CORRUGATION RIVETED, WELDED, OR HELICAL LOCK-SEAM				2 3/4 INCH BY 1/2 INCH CORRUGATION RIVETED OR HELICAL LOCK-SEAM			
15	17x13	3	0.064	2	15	0.060	2	15		
18	21x15	3	0.064	2	15	0.060	2	15		
21	24x18	3	0.064	2.25	15	0.060	2.25	15		
24	28x20	3	0.064	2.5	15	0.075	2.5	15		
30	35x24	3	0.079	3	12	0.075	3	12		
36	42x29	3 1/2	0.079	3	12	0.105	3	12		
42	49x33	4	0.079	3	12	0.105	3	12		
48	57x38	5	0.109	3	13	0.135	3	13		
54	64x43	6	0.109	3	14	0.135	3	14		
60	71x47	7	0.138	3	15	0.135	3	14		
66	77x52	8	0.168	3	15					
72	83x57	9	0.168	3	15	0.164	3	15		
② 3 INCH BY 1 INCH OR 5 INCH BY 1 INCH CORRUGATION RIVETED, WELDED, OR HELICAL LOCK-SEAM										
INSTALLATION										
TYPE 2 TYPE 1 TYPE 2 TYPE 1										
36	40x31	5	0.079	3	2	12	15			
42	46x36	6	0.079	3	2	13	15			
48	53x41	7	0.079	3	2	13	15			
54	60x46	8	0.079	3	2	13	15			
60	66x51	9	0.079	3	2	13	15			
66	73x55	12	0.079	3	2	15	15			
72	81x59	14	0.079	3	2	15	15			
78	87x63	14	0.079	3	2	15	15			
84	95x67	16	0.109	3	2	15	15			
90	103x71	16	0.109	3	2	15	15			
96	112x75	18	0.109	3	2	15	15			
102	117x79	18	0.109	3	2	15	15			
108	128x83	18	0.138	3	2	15	15			

① FOR MINIMUM COVER VALUES, "H" SHALL INCLUDE A MINIMUM 12" OF PAVEMENT AND/OR BASE.

② WHERE THE STANDARD 2 2/3" x 1/2" CORRUGATION AND GAUGE IS SPECIFIED FOR A GIVEN DIAMETER, A PIPE OF THE SAME DIAMETER WITH A 3" x 1" OR 5" x 1" CORRUGATION MAY BE SUBSTITUTED, PROVIDING IT IS GAUGED FOR A FILL HEIGHT CONDITION EQUAL TO OR GREATER THAN THE MAXIMUM FILL HEIGHT CONDITION FOR THE SPECIFIED GAUGE AND CORRUGATION.

DATE	REVISION	DATE FILMED
2-27-14	REVISED GENERAL NOTE 1	
12-15-11	REVISED FOR LRFD DESIGN SPECS	
3-30-00	REVISED INSTALLATIONS	
11-06-97	ISSUED	

ARKANSAS STATE HIGHWAY COMMISSION

METAL PIPE CULVERT

FILL HEIGHTS & BEDDING

STANDARD DRAWING PCM-1

INSTALLATION TYPE	•• MATERIAL REQUIREMENTS FOR STRUCTURAL BACKFILL AND STRUCTURAL BEDDING
TYPE 2	•SELECTED MATERIALS (CLASS SM-1, SM-2 OR SM-4)

- AGGREGATE BASE COURSE (CLASS 4, 5, 6, OR 7) MAY BE USED IN LIEU OF SELECTED MATERIAL.
 - SM3 WILL NOT BE ALLOWED.
 - STRUCTURAL BEDDING MATERIAL SHALL HAVE A MAXIMUM PARTICLE SIZE OF 1 INCH. STRUCTURAL BACKFILL MATERIAL SHALL BE FREE OF ORGANIC MATERIAL, STONES LARGER THAN 1.50 INCH IN GREATEST DIMENSION, OR FROZEN LUMPS.
- STRUCTURAL BACKFILL AND STRUCTURAL BEDDING MATERIAL WILL NOT BE PAID FOR SEPARATELY, BUT COMPENSATION WILL BE CONSIDERED TO BE INCLUDED IN THE PRICE BID PER LINEAR FOOT OF HDPE PIPE.

MINIMUM TRENCH WIDTH BASED ON FILL HEIGHT "H"

PIPE DIAMETER	TRENCH WIDTH (FEET)	
	"H" < 10'-0"	"H" >OR= 10'-0"
18"	4'-6"	4'-6"
24"	5'-0"	6'-0"
30"	5'-6"	7'-6"
36"	6'-0"	9'-0"
42"	7'-0"	10'-6"
48"	8'-0"	12'-0"

NOTE:
18" MIN. (18" - 30" DIAMETERS)
24" MIN. (36" - 48" DIAMETERS)
MINIMUM COVER VALUES, "H" SHALL INCLUDE A MINIMUM 12" OF PAVEMENT AND/OR BASE.


MULTIPLE INSTALLATION OF HIGH DENSITY POLYETHYLENE PIPES

PIPE DIAMETER	CLEAR DISTANCE BETWEEN PIPES
18"	1'-6"
24"	2'-0"
30"	2'-6"
36"	3'-0"
42"	3'-6"
48"	4'-0"

MINIMUM COVER FOR CONSTRUCTION LOADS

PIPE DIAMETER	MIN. COVER (FEET) FOR INDICATED CONSTRUCTION LOADS			
	18.0-50.0 (KIPS)	50.0-75.0 (KIPS)	75.0-110.0 (KIPS)	110.0-175.0 (KIPS)
36" OR LESS	2'-0"	2'-6"	3'-0"	3'-0"
42" OR GREATER	3'-0"	3'-0"	3'-6"	4'-0"

MINIMUM COVER SHALL BE MEASURED FROM TOP OF PIPE TO TOP OF THE MAINTAINED CONSTRUCTION ROADWAY SURFACE. THE SURFACE SHALL BE MAINTAINED.

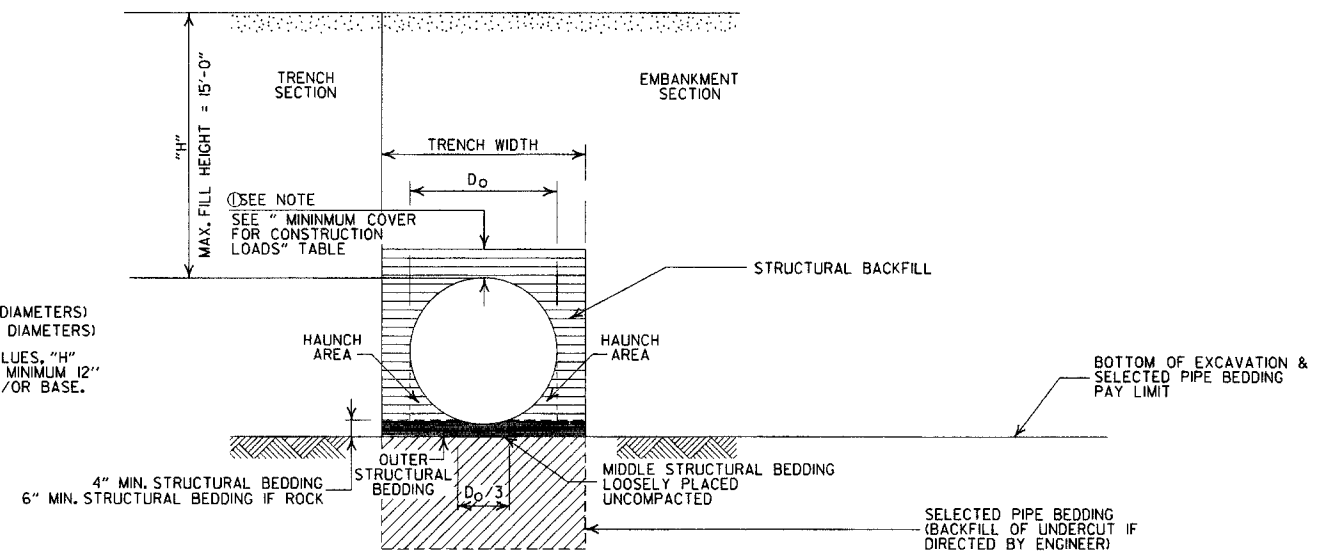

TYPE 2 EMBANKMENT AND TRENCH INSTALLATIONS

1. STRUCTURAL BACKFILL, EMBANKMENT, AND OUTER STRUCTURAL BEDDING MATERIAL SHALL BE COMPACTED TO 95% OF THE MAXIMUM DENSITY ACCORDING TO THE TYPE OR CLASS OF MATERIAL USED.

CONSTRUCTION SEQUENCE

1. PLACE STRUCTURAL BEDDING MATERIAL TO GRADE. DO NOT COMPACT.
2. INSTALL PIPE TO GRADE.
3. COMPACT STRUCTURAL BEDDING OUTSIDE THE MIDDLE THIRD OF THE PIPE.
4. THE STRUCTURAL BACKFILL SHALL BE PLACED AND COMPACTED IN LAYERS NOT EXCEEDING 8". THE LAYERS SHALL BE BROUGHT UP EVENLY AND SIMULTANEOUSLY TO THE ELEVATION OF THE MINIMUM COVER.
5. PIPE INSTALLATION MAY REQUIRE THE USE OF RESTRAINTS, WEIGHTING OR OTHER APPROVED METHODS IN ORDER TO HELP MAINTAIN GRADE AND ALIGNMENT.

- LEGEND -

H = FILL HEIGHT (FT.)
D_o = OUTSIDE DIAMETER OF PIPE
MAX. = MAXIMUM
MIN. = MINIMUM

===== = STRUCTURAL BACKFILL MATERIAL
||||||| = UNDISTURBED SOIL

GENERAL NOTES

1. PIPE SHALL CONFORM TO AASHTO M294, TYPE S. INSTALLATION SHALL CONFORM TO JOB SPECIAL PROVISION "PLASTIC PIPE" AND SECTION 606 OF THE STANDARD SPECIFICATIONS FOR HIGHWAY CONSTRUCTION (CURRENT EDITION).
2. PLASTIC PIPE CULVERT DESIGN SHALL CONFORM TO AASHTO LRFD BRIDGE DESIGN SPECIFICATIONS, FIFTH EDITION (2010) WITH 2010 INTERIMS.
3. THE MAXIMUM ALLOWABLE TRENCH WIDTH SHALL BE THE MINIMUM WIDTH PLUS A SUFFICIENT WIDTH TO ENSURE WORKING ROOM TO PROPERLY AND SAFELY PLACE AND COMPACT HAUNCHING AND OTHER BACKFILL MATERIAL.
4. IMPERVIOUS MATERIAL SHOULD BE PLACED AS DIRECTED BY THE ENGINEER AT THE ENDS OF THE CULVERT TO PREVENT LOSS OF STRUCTURAL BEDDING WHEN PERVIOUS MATERIAL IS USED FOR STRUCTURAL BEDDING AND/OR BACKFILL.
5. WHEN DIRECTED BY THE ENGINEER, UNSUITABLE MATERIAL THAT IS ENCOUNTERED AT THE BOTTOM OF THE EXCAVATED TRENCH (BELOW THE AREA IDENTIFIED AS "STRUCTURAL BEDDING" ABOVE) WILL BE EXCAVATED AND REPLACED WITH SELECTED PIPE BEDDING. THE QUANTITY OF MATERIAL REQUIRED TO BACKFILL THE UNDERCUT AREA UP TO THE SELECTED PIPE BEDDING PAY LIMIT DESIGNATED ABOVE WILL BE MEASURED AND PAID FOR AS "SELECTED PIPE BEDDING."
6. WHEN THE EXISTING MATERIAL EXCAVATED FOR THE PIPE TRENCH IS DETERMINED BY THE ENGINEER TO BE UNSUITABLE FOR BACKFILLING THE PIPE (ABOVE THE AREA IDENTIFIED ABOVE AS STRUCTURAL BACKFILL), BORROW MATERIAL OR MATERIAL FROM THE ROADWAY EXCAVATION WILL BE USED TO BACKFILL THE PIPE. IF SUITABLE MATERIAL IS NOT AVAILABLE, THE ENGINEER MAY AUTHORIZE THE USE OF "SELECTED PIPE BACKFILL."
7. FOR PIPE TYPES THAT ARE NOT SMOOTH ON THE OUTSIDE (CORRUGATED OR PROFILE WALLS), BACKFILL GRADATIONS SHOULD BE SELECTED THAT WILL PERMIT THE FILLING OF THE CORRUGATION OR PROFILE VALLEY.
8. HIGH DENSITY POLYETHYLENE PIPES OF DIAMETERS OTHER THAN SHOWN WILL NOT BE ALLOWED.
9. JOINTS FOR HDPE PIPE SHALL MEET THE REQUIREMENTS FOR SOIL TIGHTNESS AS SPECIFIED IN AASHTO SECTION 26.4.2.4 AND 30.4.2 "AASHTO LRFD BRIDGE CONSTRUCTION SPECIFICATIONS." JOINTS SHALL BE INSTALLED PER MANUFACTURER'S RECOMMENDATIONS.

DATE	REVISION	DATE FILMED
2-27-14	REVISED GENERAL NOTE 1.	
12-15-11	REVISED GENERAL NOTES & MINIMUM COVER NOTE	
11-17-10	ISSUED	

ARKANSAS STATE HIGHWAY COMMISSION

PLASTIC PIPE CULVERT
(HIGH DENSITY POLYETHYLENE)

STANDARD DRAWING PCP-1


INSTALLATION TYPE	•• MATERIAL REQUIREMENTS FOR STRUCTURAL BACKFILL AND STRUCTURAL BEDDING
TYPE 2	•SELECTED MATERIALS (CLASS SM-1, SM-2, OR SM-4)

- AGGREGATE BASE COURSE (CLASS 4, 5, 6, OR 7) MAY BE USED IN LIEU OF SELECTED MATERIAL. SM3 WILL NOT BE ALLOWED.
 - STRUCTURAL BEDDING MATERIAL SHALL HAVE A MAXIMUM PARTICLE SIZE OF 1/2 INCH. STRUCTURAL BACKFILL MATERIAL SHALL BE FREE OF ORGANIC MATERIAL, STONES LARGER THAN 1.50 INCH IN GREATEST DIMENSION, OR FROZEN LUMPS.
- STRUCTURAL BACKFILL AND STRUCTURAL BEDDING MATERIAL WILL NOT BE PAID FOR SEPARATELY, BUT COMPENSATION WILL BE CONSIDERED TO BE INCLUDED IN THE PRICE BID PER LINEAR FOOT OF PVC PIPE.

MAXIMUM FILL HEIGHT
BASED ON STRUCTURAL BACKFILL

PIPE DIAMETER	"H"
18"	45'-0"
24"	45'-0"
30"	40'-0"
36"	40'-0"

① NOTE:
12" MIN. (18" - 36" DIAMETERS)
MINIMUM COVER VALUE, "H"
SHALL INCLUDE A MINIMUM 12"
OF PAVEMENT AND/OR BASE.

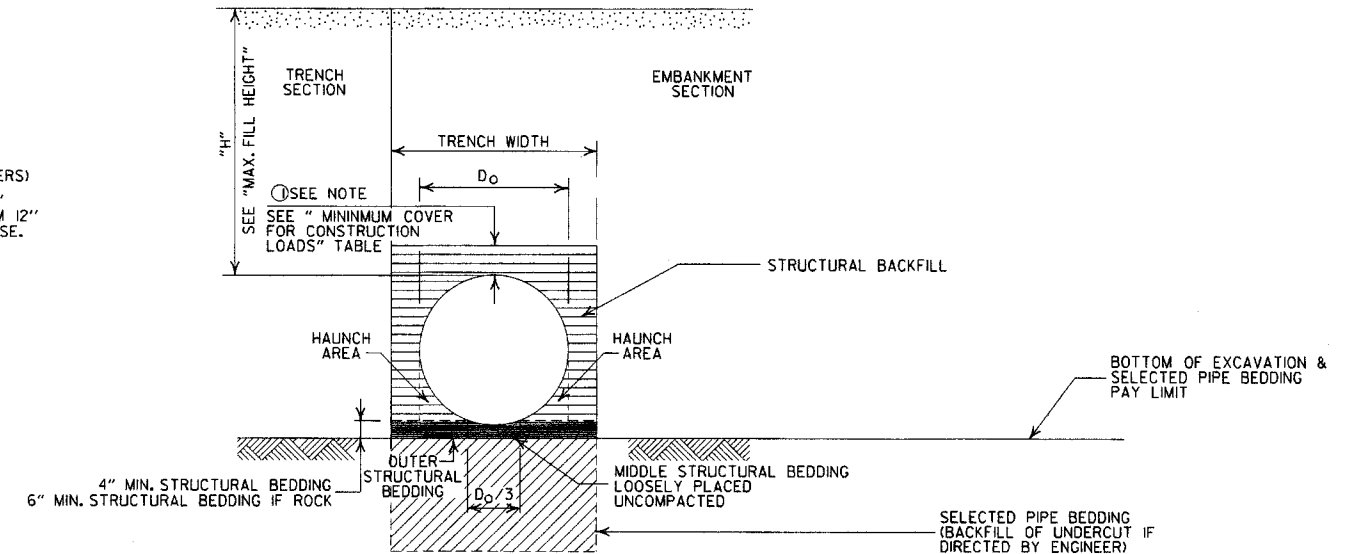

TYPE 2 EMBANKMENT AND TRENCH INSTALLATIONS

I. STRUCTURAL BACKFILL, EMBANKMENT, AND OUTER STRUCTURAL BEDDING MATERIAL SHALL BE COMPACTED TO 95% OF THE MAXIMUM DENSITY ACCORDING TO THE TYPE OR CLASS OF MATERIAL USED.

MINIMUM TRENCH WIDTH
BASED ON FILL HEIGHT "H"

PIPE DIAMETER	TRENCH WIDTH (FEET)	
	"H" < 10'-0"	"H" >OR= 10'-0"
18"	4'-6"	4'-6"
24"	5'-0"	6'-0"
30"	5'-6"	7'-6"
36"	6'-0"	9'-0"

MULTIPLE INSTALLATION OF
PVC PIPES

PIPE DIAMETER	CLEAR DISTANCE BETWEEN PIPES
18"	1'-6"
24"	2'-0"
30"	2'-6"
36"	3'-0"

MINIMUM COVER FOR
CONSTRUCTION LOADS

PIPE DIAMETER	② MIN. COVER (FEET) FOR INDICATED CONSTRUCTION LOADS			
	18.0-50.0 (KIPS)	50.0-75.0 (KIPS)	75.0-110.0 (KIPS)	110.0-175.0 (KIPS)
18" THRU 36"	2'-0"	2'-6"	3'-0"	3'-0"

② MINIMUM COVER SHALL BE MEASURED FROM TOP OF PIPE TO TOP OF THE MAINTAINED CONSTRUCTION ROADWAY SURFACE. THE SURFACE SHALL BE MAINTAINED.

CONSTRUCTION SEQUENCE

1. PLACE STRUCTURAL BEDDING MATERIAL TO GRADE. DO NOT COMPACT.
2. INSTALL PIPE TO GRADE.
3. COMPACT STRUCTURAL BEDDING OUTSIDE THE MIDDLE THIRD OF THE PIPE.
4. THE STRUCTURAL BACKFILL SHALL BE PLACED AND COMPACTED IN LAYERS NOT EXCEEDING 8". THE LAYERS SHALL BE BROUGHT UP EVENLY AND SIMULTANEOUSLY TO THE ELEVATION OF THE MINIMUM COVER.
5. PIPE INSTALLATION MAY REQUIRE THE USE OF RESTRAINTS, WEIGHTING OR OTHER APPROVED METHODS IN ORDER TO HELP MAINTAIN GRADE AND ALIGNMENT.

GENERAL NOTES

1. PIPE SHALL CONFORM TO ASTM F949, CELL CLASS 12454. INSTALLATION SHALL CONFORM TO JOB SPECIAL PROVISION "PLASTIC PIPE" AND SECTION 606 OF THE STANDARD SPECIFICATIONS FOR HIGHWAY CONSTRUCTION (CURRENT EDITION).
2. PLASTIC PIPE CULVERT DESIGN SHALL CONFORM TO AASHTO LRFD BRIDGE DESIGN SPECIFICATIONS, FIFTH EDITION (2010) WITH 2010 INTERIMS.
3. THE MAXIMUM ALLOWABLE TRENCH WIDTH SHALL BE THE MINIMUM WIDTH PLUS A SUFFICIENT WIDTH TO ENSURE WORKING ROOM TO PROPERLY AND SAFELY PLACE AND COMPACT HAUNCHING AND OTHER BACKFILL MATERIAL.
4. IMPERVIOUS MATERIAL SHOULD BE PLACED AS DIRECTED BY THE ENGINEER AT THE ENDS OF THE CULVERT TO PREVENT LOSS OF STRUCTURAL BEDDING WHEN PERVIOUS MATERIAL IS USED FOR STRUCTURAL BEDDING AND/OR BACKFILL.
5. WHEN DIRECTED BY THE ENGINEER, UNSUITABLE MATERIAL THAT IS ENCOUNTERED AT THE BOTTOM OF THE EXCAVATED TRENCH (BELOW THE AREA IDENTIFIED AS "STRUCTURAL BEDDING" ABOVE) WILL BE EXCAVATED AND REPLACED WITH SELECTED PIPE BEDDING. THE QUANTITY OF MATERIAL REQUIRED TO BACKFILL THE UNDERCUT AREA UP TO THE SELECTED PIPE BEDDING PAY LIMIT DESIGNATED ABOVE WILL BE MEASURED AND PAID FOR AS "SELECTED PIPE BEDDING."
6. WHEN THE EXISTING MATERIAL EXCAVATED FOR THE PIPE TRENCH IS DETERMINED BY THE ENGINEER TO BE UNSUITABLE FOR BACKFILLING THE PIPE (ABOVE THE AREA IDENTIFIED ABOVE AS STRUCTURAL BACKFILL), BORROW MATERIAL OR MATERIAL FROM THE ROADWAY EXCAVATION WILL BE USED TO BACKFILL THE PIPE. IF SUITABLE MATERIAL IS NOT AVAILABLE, THE ENGINEER MAY AUTHORIZE THE USE OF "SELECTED PIPE BACKFILL."
7. FOR PIPE TYPES THAT ARE NOT SMOOTH ON THE OUTSIDE (CORRUGATED OR PROFILE WALLS), BACKFILL GRADATIONS SHOULD BE SELECTED THAT WILL PERMIT THE FILLING OF THE CORRUGATION OR PROFILE VALLEY.
8. PVC PIPES OF DIAMETERS OTHER THAN SHOWN WILL NOT BE ALLOWED.
9. JOINTS FOR PVC PIPE SHALL MEET THE REQUIREMENTS FOR SOIL TIGHTNESS AS SPECIFIED IN AASHTO SECTION 26.4.2.4 AND 30.4.2 "AASHTO LRFD BRIDGE CONSTRUCTION SPECIFICATIONS." JOINTS SHALL BE INSTALLED PER MANUFACTURER'S RECOMMENDATIONS.

- LEGEND -

- H = FILL HEIGHT (FT.)
- D_o = OUTSIDE DIAMETER OF PIPE
- MAX. = MAXIMUM
- MIN. = MINIMUM
- ===== = STRUCTURAL BACKFILL MATERIAL
- ||||| = UNDISTURBED SOIL



DATE	REVISION	DATE FILMED
2-27-14	REVISED GENERAL NOTE 1.	
12-15-11	REV GENERAL NOTES & MINIMUM COVER NOTE; DELETED SM3 MATERIAL	
11-17-10	ISSUED	

ARKANSAS STATE HIGHWAY COMMISSION

PLASTIC PIPE CULVERT
(PVC F949)

STANDARD DRAWING PCP-2


- NOTES:
1. REFER TO THE STRIPING DETAILS FOR PAVEMENT MARKING LINE WIDTHS.
 2. THIS DRAWING SHALL BE USED IN CONJUNCTION WITH THE LATEST REVISED ADDITION OF THE "MANUAL ON UNIFORM TRAFFIC CONTROL DEVICES."
 3. RAISED PAVEMENT MARKERS SHALL BE PLACED ON AN 80 FEET SPACING UNLESS OTHERWISE SHOWN IN THE PLANS.

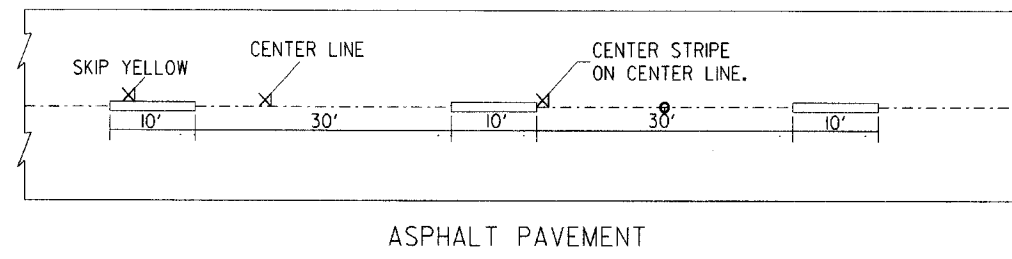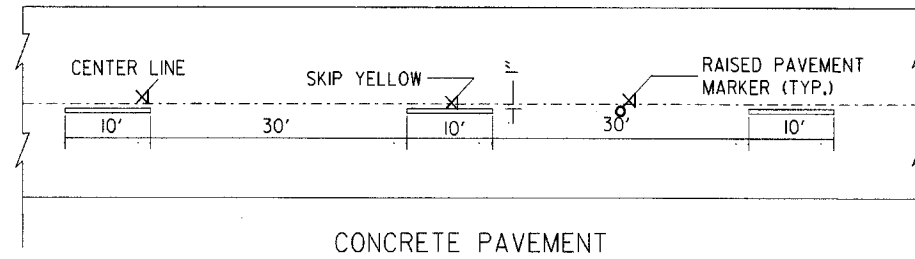


CONCRETE PAVEMENT

ASPHALT PAVEMENT


BROKEN LINE STRIPING

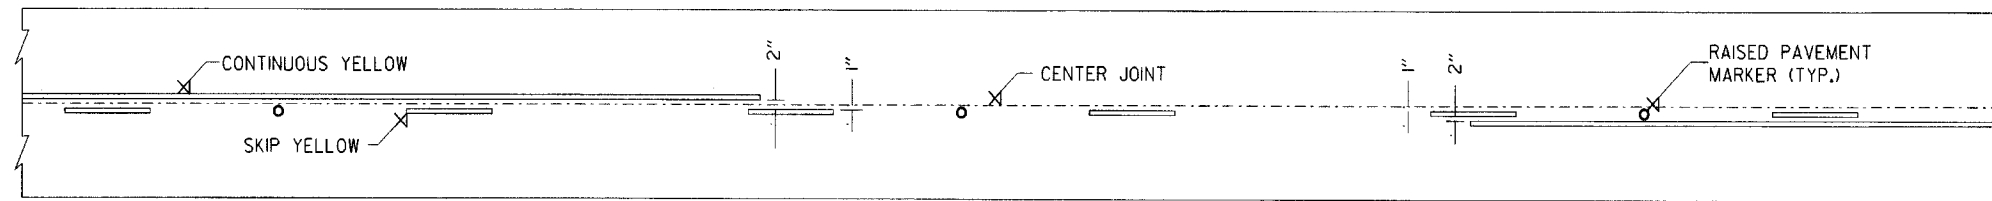


SOLID LINE STRIPING ON CONCRETE PAVEMENT

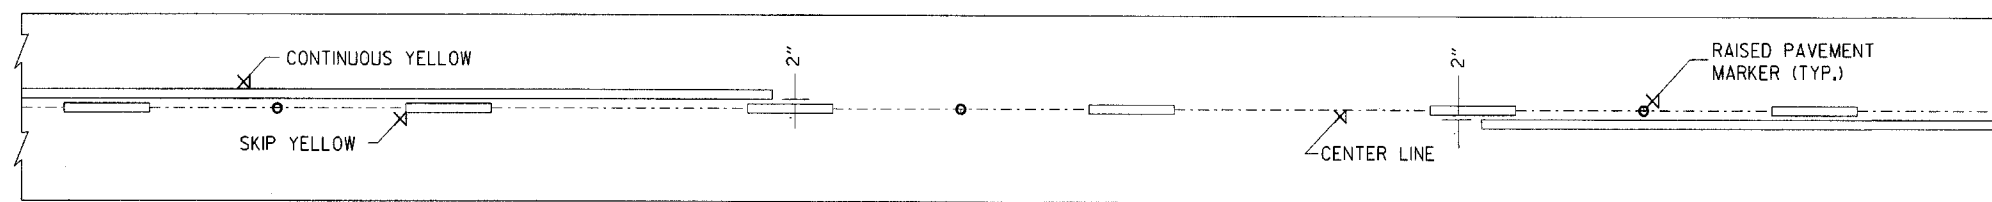

SOLID LINE STRIPING ON ASPHALT PAVEMENT

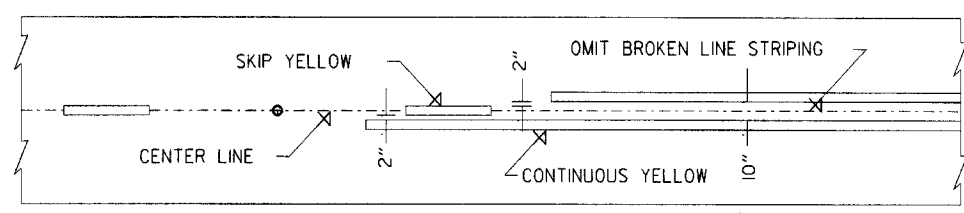


ASPHALT PAVEMENT

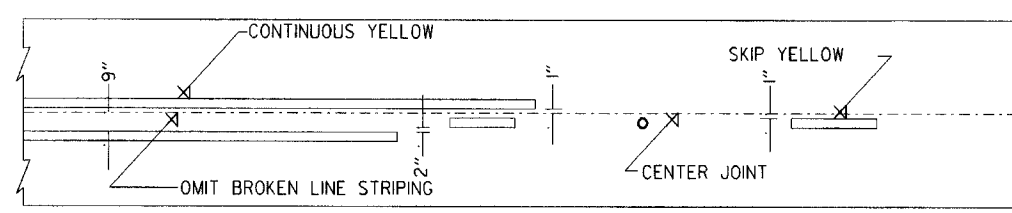


CONCRETE PAVEMENT

STRIPING AT ADJACENT NO PASSING LANES

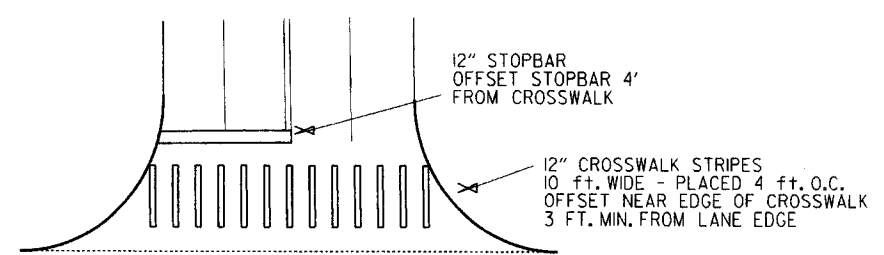


CROSSWALK AND STOPBAR DETAILS

2" FOR ASPHALT OR CONCRETE PAVEMENT
6" FOR BITUMINOUS SURFACE TREATMENT

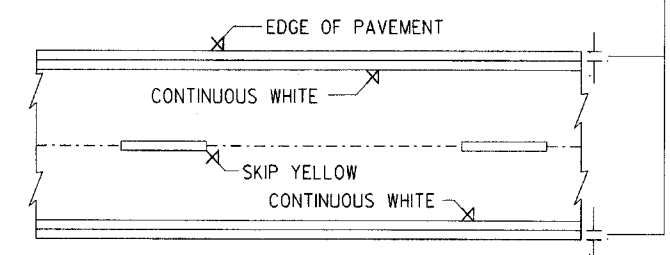

PAVEMENT EDGE LINE MARKING

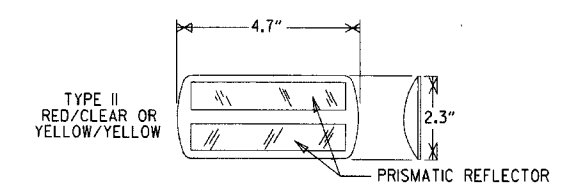

NOTE:
THE RED LENS OF THE TYPE II R.P.M. SHALL FACE THE INCORRECT TRAFFIC MOVEMENT.


DETAIL OF STANDARD RAISED PAVEMENT MARKERS

NOTE:
DIMENSIONS SHOWN FOR RAISED PAVEMENT MARKERS ARE TYPICAL. THE CONTRACTOR MAY SUBSTITUTE SIMILAR MARKERS WITH THE APPROVAL OF THE ENGINEER. REQUESTING APPROVAL FOR SIMILAR MARKERS MAY BE MADE BY REFERRING TO THE AHTD QUALIFIED PRODUCTS LIST.


DATE	REVISION	FILMED
5-12-16	REVISED LINE WIDTHS, SPACING, & NOTES	
9-12-13	REVISED DETAIL OF STANDARD RAISED PAVEMENT MARKERS	
11-17-10	REVISED GENERAL NOTES & REMOVED PLOWABLE PAVT MRKRS	
11-18-04	REVISED NOTE 2 & GENERAL NOTES	
8-22-02	ADDED CROSSWALK & STOPBAR DTLS.	
7-02-98	ADDED DETAILS OF STD. RAISED PAV'T. MARKERS	
4-26-96	REV. NOTES 3&4; ADDED R.P.M.	
9-30-80	DRAWN	1-9-30-80

ARKANSAS STATE HIGHWAY COMMISSION	
PAVEMENT MARKING DETAILS	
STANDARD DRAWING PM-1	


NOTE:
 1. GRANULAR BACKFILL TO BE SUBSIDIARY TO PIPE UNDERDRAIN.
 2. UNLESS OTHERWISE SPECIFIED ON THE PLANS, THE UNDERDRAIN COVER SHALL BE THOROUGHLY COMPACTED EARTH AND SHALL BE SUBSIDIARY TO PIPE UNDERDRAIN.
 3. GRANULAR MATERIAL SHALL BE WRAPPED WITH GEOTEXTILE FABRIC, LAP FABRIC 12" OR THE WIDTH OF THE TRENCH AT THE TOP.

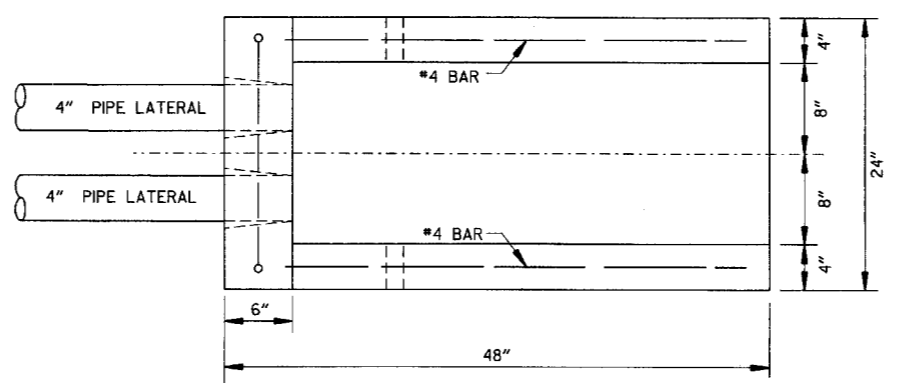



PLAN VIEW

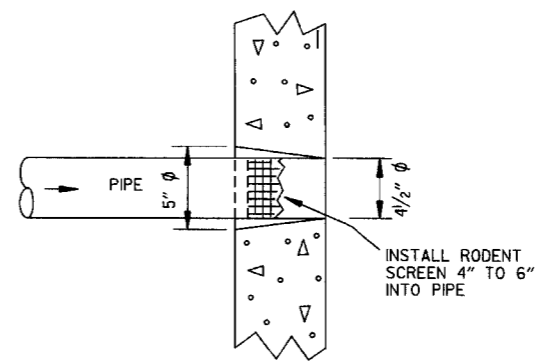


DETAIL OF HOLE FOR 4" PIPE

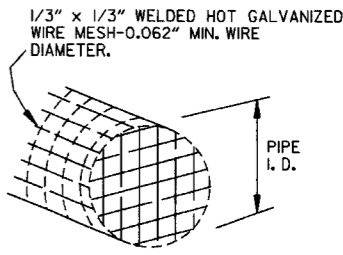


DETAIL OF RODENT SCREEN

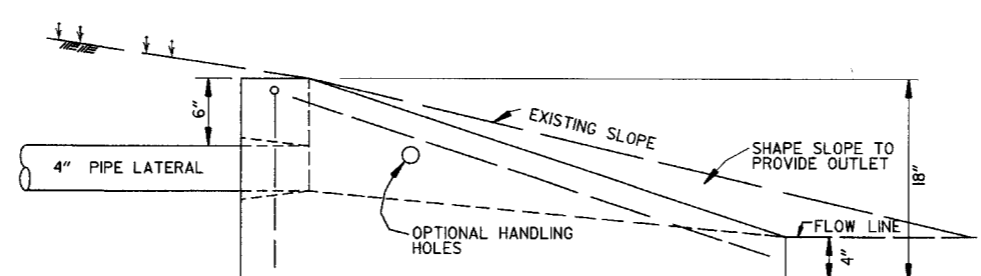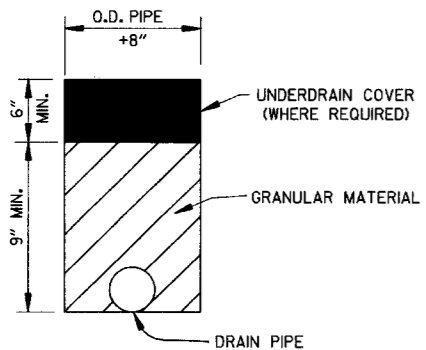

SIDE VIEW

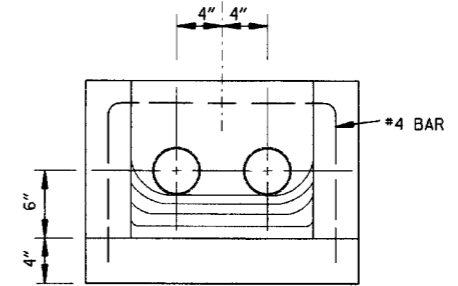


FRONT VIEW

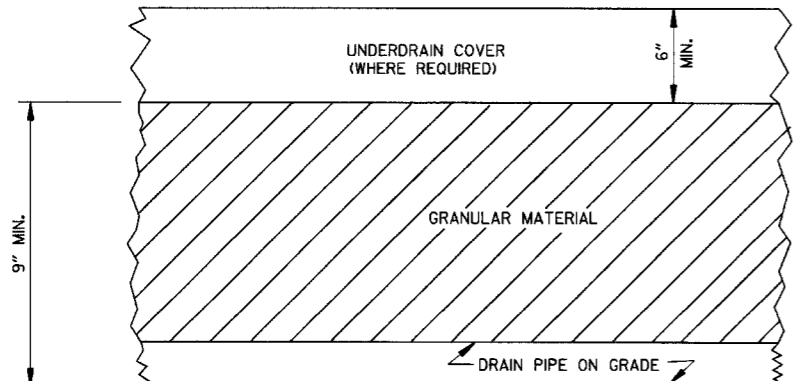

DETAILS OF PIPE UNDERDRAIN

FERNCO 1056-44 (4" CI/PLASTIC) OR FERNCO 1051-44 (4" AC/DI OR 4" CI/PLASTIC) COUPLING OR EQUAL WITH 2 CLAMPS (TYPICAL)

UNDERDRAIN OUTLET PROTECTORS

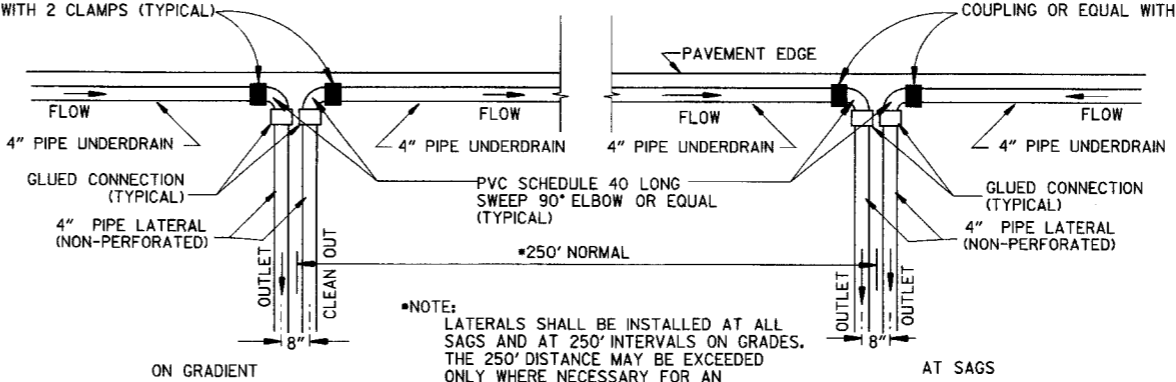

NOTE:
 LATERALS SHALL BE INSTALLED AT ALL SAGS AND AT 250' INTERVALS ON GRADES. THE 250' DISTANCE MAY BE EXCEEDED ONLY WHERE NECESSARY FOR AN ACCEPTABLE OUTLET.

DETAIL OF PIPE UNDERDRAIN LATERALS WHEN PLACED ALONG PAVEMENT EDGE

NOTE: PVC PIPE FOR LATERALS SHALL MEET THE REQUIREMENTS OF ASTM D 1785 (LATEST REVISION) FOR SCHEDULE 40 PIPE.

4-10-03	REVISED NOTE 3	
1-12-00	REVISED DETAIL OF UNDERDRAIN LATERALS	
11-18-98	REVISED NOTE	
10-18-96	REVISED MIN. DEPTH & GEOTEXTILE FABRIC	
4-26-96	ADDED LATERAL NOTE; 5 1/2" TO 5"	
11-22-95	REVISED LATERALS	
7-20-95	REVISED LATERALS & ADDED NOTE	
11-3-94	REVISED FOR DUAL LATERALS	11-3-94
10-1-92	SUBSTITUTED GEOTEXTILE	10-1-92
8-15-91	ADDED POLYETHYLENE PIPE	8-15-91
11-8-90	DELETED ALTERNATE NOTE	11-8-90
1-25-90	ADDED 4" SNAP ADAPTER	1-25-90
11-30-89	DEL. (SUBGRADE); ADDED (WHERE REQUIRED)	11-30-89
7-15-88	ISSUED P.L.M.	647-7-15-88
DATE	REVISION	DATE FILMED

ARKANSAS STATE HIGHWAY COMMISSION


DETAILS OF PIPE UNDERDRAIN

STANDARD DRAWING PU-1

STEEL FABRICATION: REINFORCING STEEL FABRICATION SHALL CONFORM TO THE DIMENSIONS LISTED IN THE TABLE BELOW:

BAR SIZE	PIN DIAMETER	HOOK EXTENSION "K"
3	2 1/4"	4"
4	3"	4 1/2"
5	3 3/4"	5"
6	4 1/2"	6"
7	5 1/4"	7"
8	6"	8"

IF THE OVERALL HEIGHT OF THE HOOK (SEE DIAGRAM BELOW) FOR A "b", "b1", "b2" OR "b3" BENT BAR IS GREATER THAN THE CORRESPONDING TOP OR BOTTOM SLAB THICKNESS, LESS 2 3/4 INCHES, EACH BENT BAR SHALL BE REPLACED WITH ONE HOOKED BAR AND ONE STRAIGHT BAR, USING LENGTHS AS SHOWN IN THE TABLE BELOW. THE TWO BARS SHALL BE THE SAME DIAMETER AS, AND PLACED AT THE SAME SPACING AS, THE "b", "b1", "b2" OR "b3" BENT BARS THEY REPLACE.

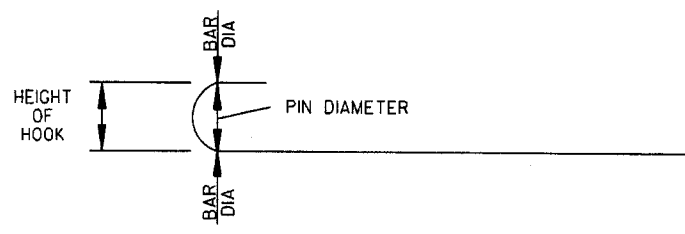

NOTE: DIMENSIONS OF BARS ARE MEASURED OUT TO OUT OF BARS.

OVERALL HEIGHT OF HOOKED BAR DIAGRAM


THE HOOKED BARS SHALL BE PLACED IN THE BOTTOM OF THE TOP SLAB AND THE TOP OF THE BOTTOM SLAB. THE STRAIGHT BARS SHALL BE PLACED IN THE TOP OF THE TOP SLAB AND THE BOTTOM OF THE BOTTOM SLAB. SEE TABLE BELOW FOR LENGTHS OF REPLACEMENT HOOKED AND STRAIGHT BARS.

FOR SKEWED CULVERTS, THE REPLACEMENT STRAIGHT BAR MAY HAVE TO BE CUT IN FIELD TO FIT.

REPLACEMENT BAR LENGTHS TABLE

BAR SIZE: "b", "b1", "b2" OR "b3"	LENGTH OF HOOKED BAR	LENGTH OF STRAIGHT BAR
*4	L + 1' - 0"	SEE "c" BAR LENGTH
*5	L + 1' - 2"	SEE "c" BAR LENGTH
*6	L + 1' - 4"	SEE "c" BAR LENGTH
*7	L + 1' - 8"	SEE "c" BAR LENGTH
*8	L + 1' - 10"	SEE "c" BAR LENGTH
*9	L + 2' - 6"	SEE "c" BAR LENGTH

L = "OW" - 3 INCHES

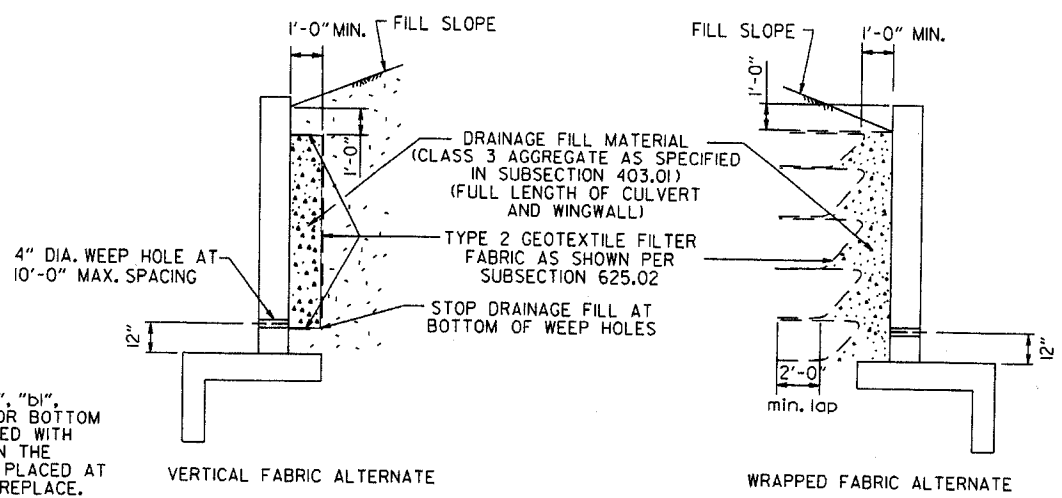

WINGWALL & CULVERT DRAINAGE DETAIL

REINFORCED CONCRETE BOX CULVERT GENERAL NOTES

CONCRETE SHALL BE CLASS S WITH A MINIMUM 28 DAY COMPRESSIVE STRENGTH OF 3500 PSI. REINFORCING STEEL SHALL BE AASHTO M 31OR M 53, GRADE 60.

CONSTRUCTION AND MATERIALS FOR WINGWALL & CULVERT DRAINAGE, INCLUDING WEEP HOLES AND GRANULAR MATERIAL, SHALL BE SUBSIDIARY TO THE BID ITEM, "CLASS S CONCRETE".

MEMBRANE WATERPROOFING SHALL CONFORM TO THE REQUIREMENTS OF SECTION 815 OF THE STANDARD SPECIFICATIONS.


MEMBRANE WATERPROOFING SHALL BE APPLIED TO ALL CONSTRUCTION JOINTS IN THE TOP SLAB AND THE SIDEWALLS OF R.C. BOX CULVERTS AS DIRECTED BY THE ENGINEER. NO PAYMENT SHALL BE MADE FOR THIS ITEM, BUT PAYMENT WILL BE CONSIDERED TO BE INCLUDED IN THE VARIOUS ITEMS BID FOR THE R.C. BOX CULVERT.

REINFORCING STEEL TOLERANCES: THE TOLERANCES FOR REINFORCING STEEL SHALL MEET THOSE LISTED IN "MANUAL OF STANDARD PRACTICE" PUBLISHED BY CONCRETE REINFORCING STEEL INSTITUTE (CRSI) EXCEPT THAT THE TOLERANCE FOR TRUSS BARS SUCH AS FIGURE 3 ON PAGE 7-4 OF THE CRSI MANUAL SHALL BE MINUS ZERO TO PLUS 1/2 INCH.

WEEP HOLES IN BOX CULVERT WALLS SHALL HAVE A MAXIMUM HORIZONTAL SPACING OF 10'-0" AND SHALL BE SPACED TO CLEAR ALL REINFORCING STEEL. THE DRAIN OPENING SHALL BE 4" DIAMETER AND SHALL BE PLACED 12" ABOVE THE TOP OF THE BOTTOM SLAB.

WEEP HOLES IN WINGWALLS SHALL HAVE A MAXIMUM HORIZONTAL SPACING OF 10'-0" AND SHALL BE SPACED TO CLEAR ALL REINFORCING STEEL. THERE SHALL BE A MINIMUM OF TWO (2) WEEP HOLES IN EACH WINGWALL. THE DRAIN OPENING SHALL BE 4" DIAMETER AND SHALL BE PLACED 12" ABOVE THE TOP OF THE WINGWALL FOOTING.

THE REQUIREMENTS SHOWN ON THIS DRAWING SHALL SUPERCEDE THE CORRESPONDING REQUIREMENTS ON ALL REINFORCED CONCRETE BOX CULVERT STANDARD DRAWINGS.

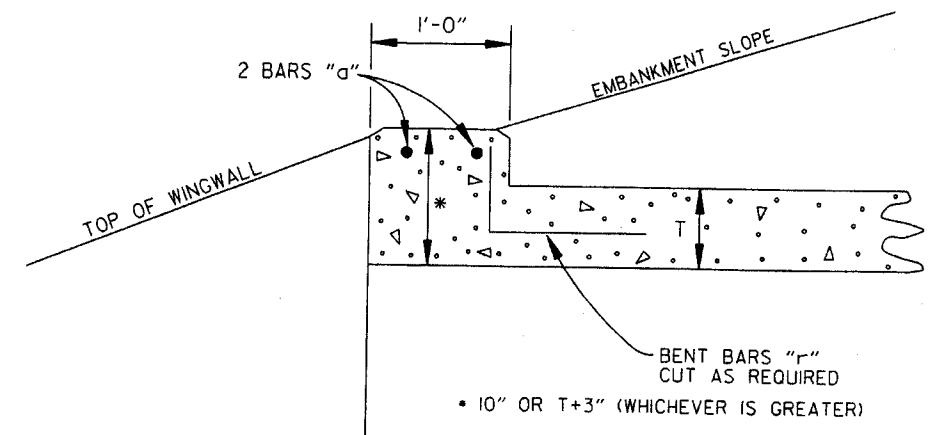

NOTE: FOR ALL SKEWED R.C. BOX CULVERTS THE LENGTH "K" OF THE MODIFIED HEADWALL SHALL BE EQUAL TO THE ROADWAY LENGTH "RL". THE ENDS OF THE HEADWALL SHALL BE CONSTRUCTED PARALLEL TO THE SKEW ANGLE OF THE BOX CULVERT.



R.C. BOX CULVERT HEADWALL MODIFICATIONS

DATE	REVISION	DATE FILMED
7/26/12	REV. DRAINAGE FILL MATERIAL & DETAIL	
12/15/11	REQUIRE WEEP HOLES IN BOX CULVERT WALLS	
5-25-06	REV. GEN. NOTES AND DETAILS FOR WEEP HOLES; BAR DIAGRAM	
11-16-01	ADDED WINGWALL DRAINAGE DETAIL/EDITED GEN. NOTES	
10-18-96	REV. ASTM REF. TO AASHTO & ADDED BAR DIAGRAM	
10-12-95	MOVED SOLID SODDING DETAIL TO RCB-2	
6-2-94	ADDED SOLID SODDING PLAN DETAIL	
8-5-93	REVISED PIN DIAMETER TO SPECS.	
8-15-91	DRAWN AND ISSUED	

ARKANSAS STATE HIGHWAY COMMISSION



REINFORCED CONCRETE BOX CULVERT DETAILS

STANDARD DRAWING RCB-1

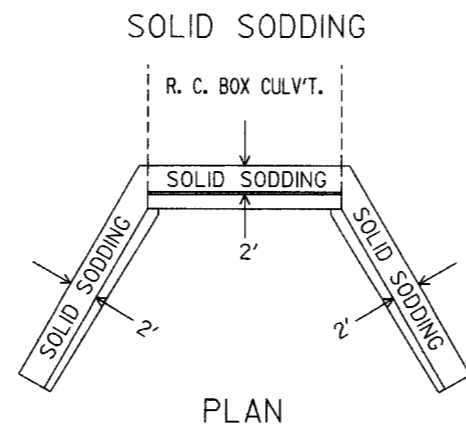
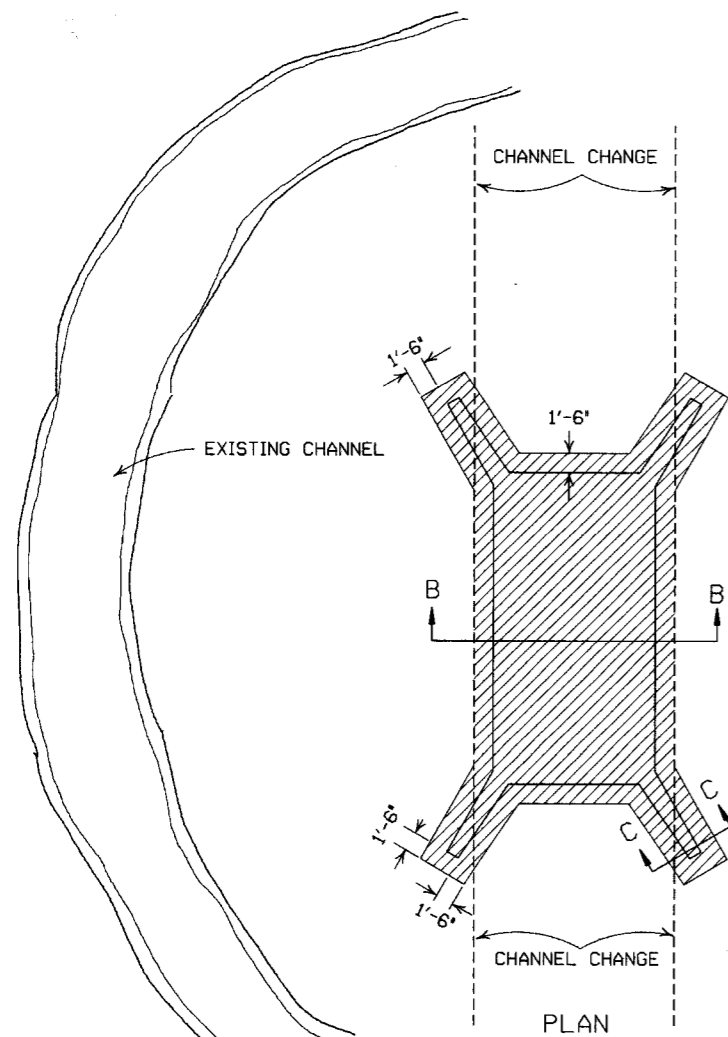


PLAN
PARTIAL SECTION SHOWING SOLID SODDING AT HEADWALLS AND WING WALLS


NOTE: LENGTH MEASURED ALONG THE CENTER OF 2' STRIP OF SOLID SODDING.

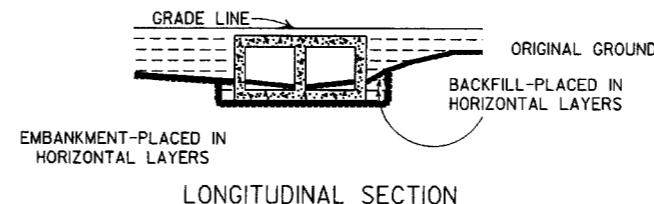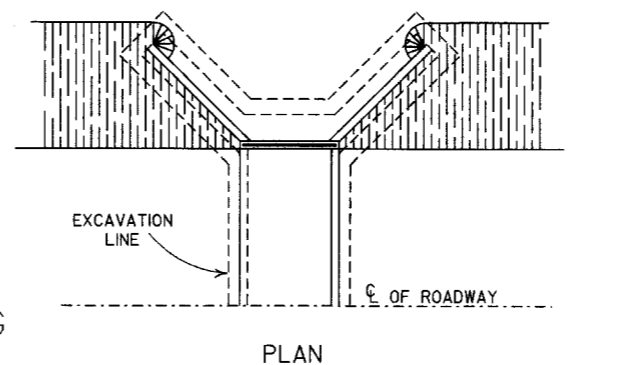


LONGITUDINAL SECTION
BACKFILL DETAILS FOR BOX CULVERT

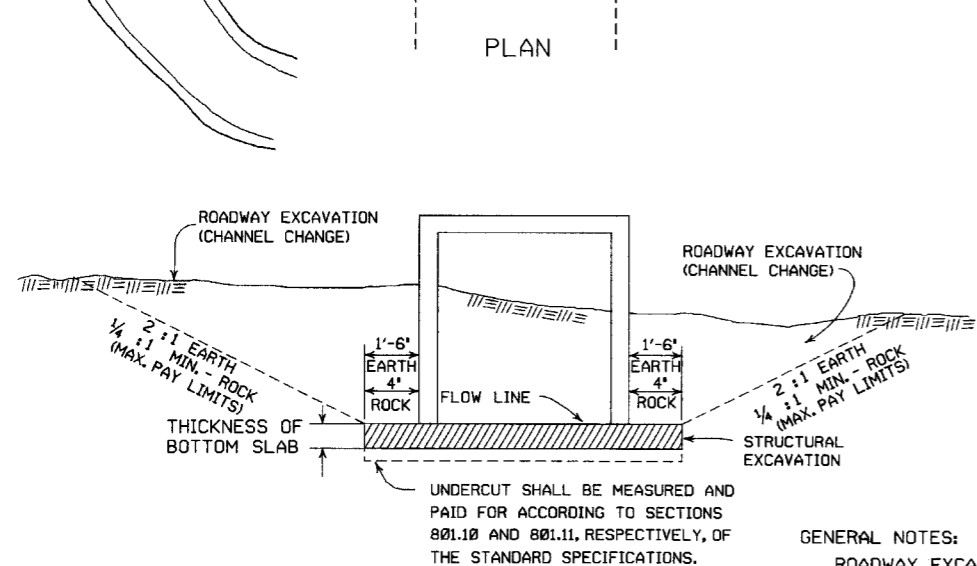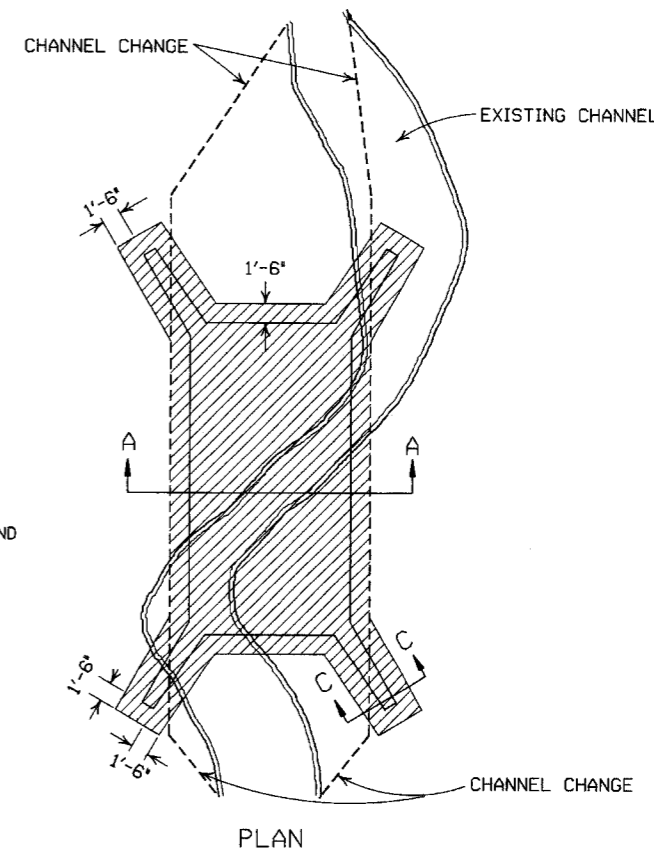

SECTION B-B
DETAILS FOR NEW CHANNELS

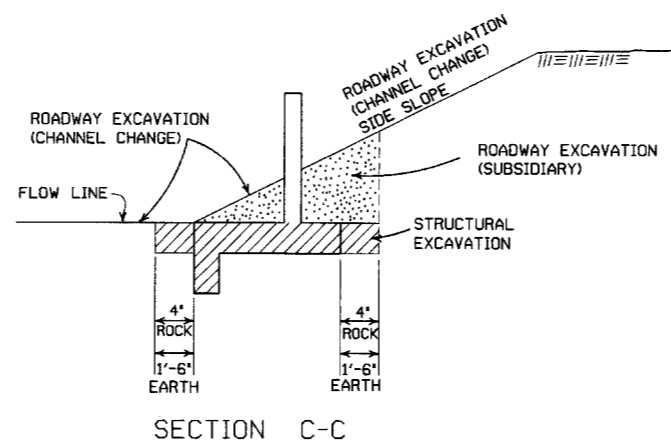

SECTION C-C

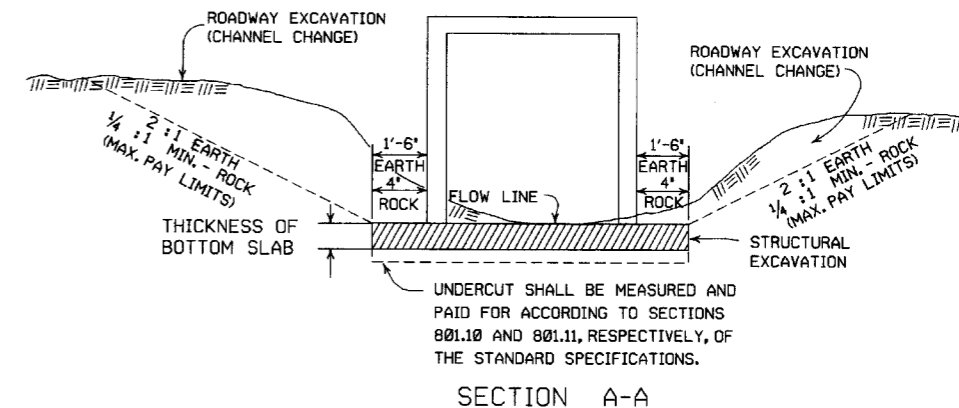

SECTION A-A
DETAILS THROUGH EXISTING CHANNELS

GENERAL NOTES:

ROADWAY EXCAVATION (CHANNEL CHANGE) WILL BE PAID FOR AT R.C. BOX CULVERT LOCATIONS. IT WILL BE PAID TO THE LIMITS ACTUALLY CUT AND WILL BE CONFINED TO THAT PORTION OF THE INDICATED AREA THAT IS ABOVE THE FLOW LINE. ROADWAY EXCAVATION (CHANNEL CHANGE) SHALL BE MEASURED BY CROSS SECTIONS AND VOLUMES COMPUTED BY AVERAGE END AREA METHOD. ALL CHANNEL CHANGES SHALL BE BROUGHT TO GRADE PRIOR TO MAKING ANY EXCAVATION FOR STRUCTURES.

EXCAVATION FOR STRUCTURES WILL BE PAID FOR AT ALL R.C. BOX CULVERT LOCATIONS. IT WILL BE PAID TO THE LIMITS SHOWN AND SHALL BE CONFINED TO THAT PORTION OF THE INDICATED AREA THAT IS BELOW THE CHANNEL FLOW LINE.

ROADWAY EXCAVATION SHOWN IN SECTION C-C ABOVE AS SUBSIDIARY WILL NOT BE MEASURED OR PAID FOR DIRECTLY, BUT PAYMENT WILL BE CONSIDERED TO BE INCLUDED IN THE VARIOUS ITEMS OF EXCAVATION.

11-20-03	REVISED SECTION A-A NOTE	
8-22-02	REVISED SECTION B-B NOTE	
10-12-95	COMBINED 1891B AND 1888A	
1-4-83	REVISED GENERAL NOTES AND ADDED MAXIMUM PAY LIMIT NOTES.	674-1-4-83
2-2-76	EXCAV. PAY LIMITS	917-2-2-76
10-2-72	REVISED AND REDRAWN	564-10-16-72
DATE	REVISION	FILMED

ARKANSAS STATE HIGHWAY COMMISSION

EXCAVATION PAY LIMITS, BACKFILL, & SOLID SODDING FOR BOX CULVERTS

STANDARD DRAWING RCB-2

ADVANCE DISTANCES
(XXXX)

500 FT	1/2 MILE
1000 FT	3/4 MILE
1500 FT	1 MILE AHEAD


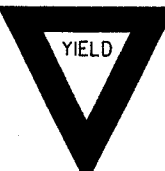
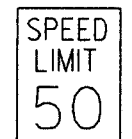

















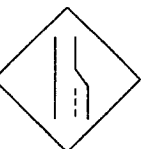




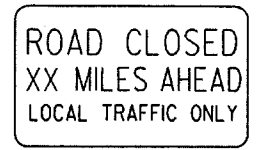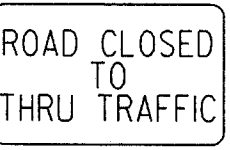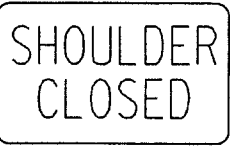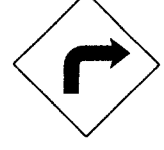












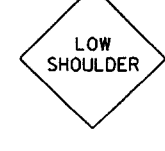
 
 
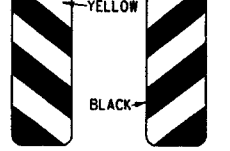


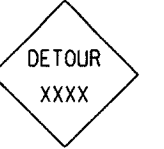
- GENERAL NOTES:
- ALL TRAFFIC CONTROL DEVICES USED ON ROAD CONSTRUCTION SHALL CONFORM TO THE MANUAL ON UNIFORM TRAFFIC CONTROL DEVICES, LATEST EDITION, AND TO THE STANDARD HIGHWAY SIGNS, LATEST EDITION, OR AS APPROVED BY THE FEDERAL HIGHWAY ADMINISTRATION.
 - TRAFFIC CONTROL DEVICES SHALL BE SET UP JUST BEFORE THE START OF CONSTRUCTION OPERATIONS AND SHALL BE PROPERLY MAINTAINED DURING THE TIME SUCH CONDITIONS EXIST. THEY SHALL REMAIN IN PLACE ONLY AS LONG AS NEEDED AND REMOVED THEREAFTER.
 - EXISTING SIGNS AND CONSTRUCTION SIGNS SHALL BE KEPT IN PROPER POSITION, AND BE CLEAN AND LEGIBLE AT ALL TIMES. SIGNS THAT DO NOT APPLY TO EXISTING CONDITIONS SHALL BE REMOVED. SIGNS THAT ARE DAMAGED, DEFACED, OR THAT ACCUMULATE DIRT DURING CONSTRUCTION SHALL BE CLEANED, REPAIRED, OR REPLACED.
 - SIGNS ARE USUALLY MOUNTED ON A SINGLE POST, ALTHOUGH THOSE WIDER THAN 36" OR LARGER THAN 10 SQ. FT. SHALL BE MOUNTED ON TWO POSTS OR ABOVE A TYPE III BARRICADE.
 - SIGN POSTS DIRECT BURIED IN SOIL SHALL BE 2 LB. MINIMUM CHANNEL POST OR 4"x4" WOOD POSTS. CHANNEL POSTS SHALL BE PAINTED GREEN. WOOD POSTS SHALL BE PAINTED WHITE. ALL POSTS SHALL BE NEATLY CONSTRUCTED, AND SHALL BE REPLUMBED, CLEANED, OR REPAIRED AS NEEDED FOR THE DURATION OF THE JOB. THERE SHALL NOT BE MORE THAN 2 POSTS IN A 7' PATH FOR WOOD OR CHANNEL POSTS. ANY CHANNEL POST SPLICE SHALL BE IN ACCORDANCE WITH STANDARD DRAWING TC-3.
 - POST MOUNTED SIGNS IN RURAL AREAS SHALL BE CONSTRUCTED WITH THE NEAR EDGE OF THE SIGN FROM 6 TO 12 FEET FROM THE PAVEMENT EDGE. SIGNS IN URBAN AREAS AND BARRICADE MOUNTED SIGNS SHALL BE MOUNTED A MINIMUM OF 2 FEET FROM THE PAVEMENT EDGE.
 - ALL POST AND BARRICADE MOUNTED SIGNS MOUNTED IN URBAN AREAS SHALL BE MOUNTED A MINIMUM DISTANCE OF 7' FROM THE BOTTOM OF THE SIGN TO THE ROADWAY SURFACE. ALL POST AND BARRICADE MOUNTED SIGNS MOUNTED IN RURAL AREAS SHALL BE MOUNTED A MINIMUM DISTANCE OF 7' FROM THE BOTTOM OF THE SIGN TO THE ROADWAY SURFACE, EXCEPT A MINIMUM OF 6' SHALL BE USED WHEN MOUNTING AN ADVISORY SIGN BELOW A WARNING SIGN. TEMPORARY SIGNS MAY BE MOUNTED ON PORTABLE SUPPORTS FOR INTERMEDIATE TERM STATIONARY WORK CONDITIONS. THE SIGNS MINIMUM MOUNTING HEIGHT SHALL BE 5'. RETROREFLECTIVE DEVICES SHALL BE USED. TEMPORARY SIGNS MAY BE MOUNTED ON PORTABLE SUPPORTS FOR SHORT-TERM, SHORT DURATION, AND MOBILE CONDITIONS. THEY SHALL BE NO LESS THAN ONE (1) FOOT ABOVE THE TRAVELED WAY. LONG-TERM STATIONARY SIGNS SHALL BE DIRECT BURIED IN SOIL, UNLESS CONDITIONS NECESSITATE THE USE OF PORTABLE SIGNS, OR AS APPROVED BY THE ENGINEER. CONCRETE PADS, CONCRETE OR ROCK BALLAST, OR OTHER SOLID MATERIALS SHALL NOT BE UTILIZED WITH PORTABLE SIGN SUPPORTS.
 - FLAGGERS SHALL USE REFLECTORIZED STOP-SLOW PADDLES. FLAGS MAY BE USED ONLY FOR EMERGENCY SITUATIONS.
 - MOST OF THE SIGNS SHOWN ARE ORIENTED TO THE RIGHT. HOWEVER, THIS DOES NOT PRECLUDE THE USE OF MIRROR IMAGES OF THESE SIGNS WHERE THE REVERSE ORIENTATION MIGHT BETTER CONVEY TO MOTORISTS THE PROPER DIRECTION OF MOVEMENT.
 - R55-1 SIGNS SHALL BE PLACED AT LEAST 1500' BUT NOT MORE THAN 1 MILE IN ADVANCE OF THE WORK ZONE. IF A SPEED LIMIT REDUCTION IS IN EFFECT, THE SIGN SHALL BE PLACED A MINIMUM OF 500' IN ADVANCE OF THE "REDUCED SPEED AHEAD" SIGN.


* NOTE: SUPPORTS FOR SIGNS, BARRICADES, AND VERTICAL PANELS THAT ARE DIFFERENT FROM THE REQUIREMENTS SHOWN IN NOTES 4 & 5, BUT MEET THE REQUIREMENTS OF NCHRP-350 OR MANUAL FOR ASSESSING SAFETY HARDWARE (MASH), WILL BE ACCEPTED. COMPLIANCE WITH THE REQUIREMENTS OF NCHRP-350 OR MANUAL FOR ASSESSING SAFETY HARDWARE (MASH) IS REQUIRED FOR ALL PROJECTS.

9-2-85	REVISED REDUCED SPEED LIMIT AHEAD SIGNS REVISED ROAD WORK NEXT XX MILES	
12-15-84	REVISED W24-1	
1-17-80	DELETED W8-9a & ADDED W8-9	
10-5-09	ADDED REFERENCE TO MASH & ADDED SIGN W24-1	
4-17-08	REVISED SIGN DESIGNATIONS	
11-8-04	REVISED NOTES	
10-9-03	REVISED NOTE 1	
1-16-01	REVISED NOTE 7	
9-28-00	REVISED NOTE	
1-18-98	ADDED NOTE	
6-26-97	REVISED NOTE 5	
4-03-97	REVISED NOTE 5	
10-8-96	ADDED CONTROLLED ACCESS HWY. SIGN & TO NOTE 7	
10-12-95	ADDED R55-1	
6-8-95	REVISED TO CORRECT SIGN ILLUSTRATIONS	6-8-95
2-2-95	REVISED PER PART VI, MUTCD SEPT. 3, 1993	
8-5-91	DRAWN AND PLACED IN USE	
DATE	REVISION	FILMED

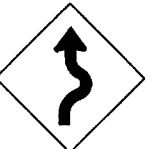
ARKANSAS STATE HIGHWAY COMMISSION
STANDARD TRAFFIC CONTROLS
FOR HIGHWAY CONSTRUCTION
STANDARD DRAWING TC-1

36"x60"
• USE 6" C LETTERS
•• USE 4" D LETTERS

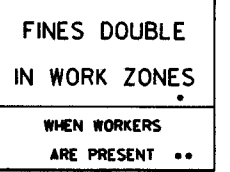
<p>RI-1</p>  <p>STANDARD 30"x30" EXPRESSWAY 36"x36" SPECIAL 48"x48"</p>	<p>RI-2</p>  <p>STD. 36"x36"x36" EXPWY. 48"x48"x48" FWY. 60"x60"x60"</p>	<p>R2-1</p>  <p>STD. 24"x30" EXPWY. 36"x48" FWY. 48"x60"</p>	<p>W3-5</p>  <p>STD. 36"x36" EXPWY. 48"x48" FWY. 48"x48"</p>	<p>W3-5a</p>  <p>STD. 36"x36" EXPWY. 48"x48" FWY. 48"x48"</p>	<p>R4-1</p>  <p>STD. 24"x30" EXPWY. 36"x48" FWY. 48"x60"</p>	<p>R4-2</p>  <p>STD. 24"x30" EXPWY. 36"x48" FWY. 48"x60"</p>	
<p>R5-1</p>  <p>STD. 30"x30" EXPWY. 36"x36" SPECIAL 48"x48"</p>	<p>R11-2</p>  <p>48"x30"</p>	<p>R11-3A</p>  <p>60"x30"</p>	<p>R11-4</p>  <p>60"x30"</p>	<p>RSP-1</p>  <p>48"x30"</p>	<p>W1-1</p>  <p>STD. 36"x36" FWY. 48"x48"</p>	<p>W1-2</p>  <p>STD. 36"x36" FWY. 48"x48"</p>	
<p>W1-3</p>  <p>STD. 48"x48"</p>	<p>W1-4</p>  <p>STD. 48"x48"</p>	<p>W1-6</p>  <p>STD. 48"x24" SPECIAL 60"x30"</p>	<p>W1-8</p>  <p>STD. 18"x24" SPECIAL 24"x30" EXPWY. 30"x36" FWY. 36"x48"</p>	<p>W3-1</p>  <p>STD. 36"x36" SPECIAL 48"x48"</p>	<p>W3-2</p>  <p>STD. 36"x36" SPECIAL 48"x48"</p>	<p>W4-2</p>  <p>STD. 36"x36" FWY. 48"x48"</p>	
<p>W5-1</p>  <p>STD. 36"x36" SPECIAL 48"x48"</p>	<p>W6-3</p>  <p>EXPWY. 36"x36" SPECIAL 48"x48"</p>	<p>W8-7</p>  <p>EXPWY. 36"x36" FWY. 48"x48"</p>	<p>W9-2</p>  <p>STD. 36"x36" FWY. 48"x48"</p>	<p>W13-1</p>  <p>STD. 24"x24"</p>	<p>W20-1</p>  <p>STD. 48"x48"</p>	<p>W20-2</p>  <p>STD. 48"x48"</p>	<p>W20-3</p>  <p>STD. 48"x48"</p>
<p>W20-4</p>  <p>STD. 48"x48"</p>	<p>W20-5</p>  <p>STD. 48"x48"</p>	<p>W20-7a</p>  <p>STD. 36"x36" FWY. 48"x48"</p>	<p>W21-2</p>  <p>STD. 30"x30" SPECIAL 36"x36"</p>	<p>W21-5</p>  <p>STD. 30"x30" SPECIAL 36"x36"</p>	<p>W24-1</p>  <p>STD. 36"x36"</p>	<p>W1-4b</p>  <p>STD. 48"x48"</p>	<p>R56-1</p>  <p>STD. 18"x18"</p>
<p>W8-11</p>  <p>STD. 36"x36" FWY. 48"x48"</p>	<p>W8-9</p>  <p>STD. 36"x36" FWY. 48"x48"</p>	<p>G20-1</p>  <p>60"x24"</p>	<p>G20-2</p>  <p>48"x24"</p>	<p>OM-3L OM-3R</p>  <p>12"x36"</p>	<p>M4-9</p>  <p>STD. 30"x24" SPECIAL 48"x36" SPECIAL 60"x48"</p>	<p>M4-10</p>  <p>48"x18"</p>	<p>R55-1</p>  <p>36"x60" • USE 6" C LETTERS •• USE 4" D LETTERS</p>

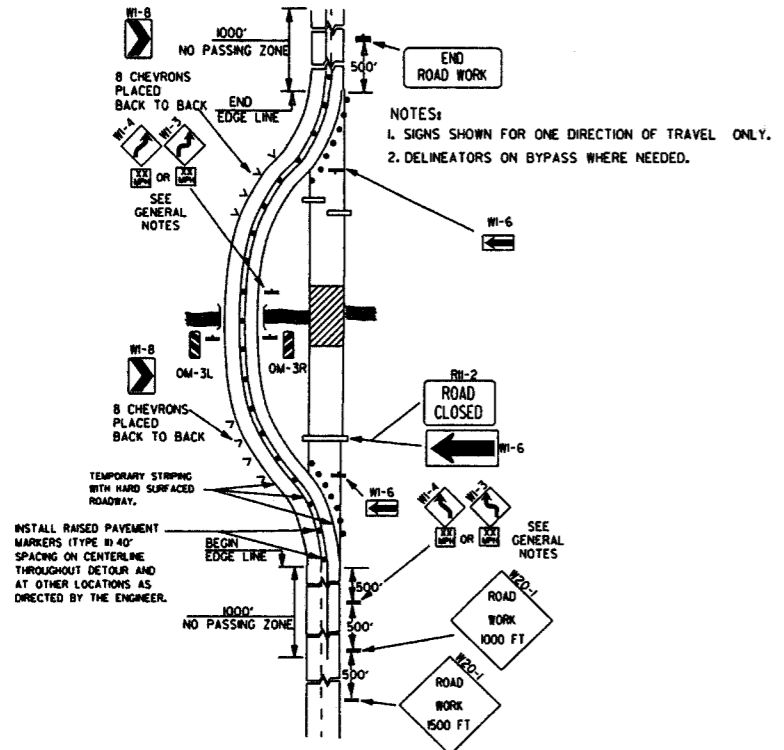


(A) TYPICAL APPLICATION OF TRAFFIC CONTROL DEVICES ON A 2-LANE HIGHWAY WHERE THE ENTIRE ROADWAY IS CLOSED AND A BYPASS DETOUR IS PROVIDED.

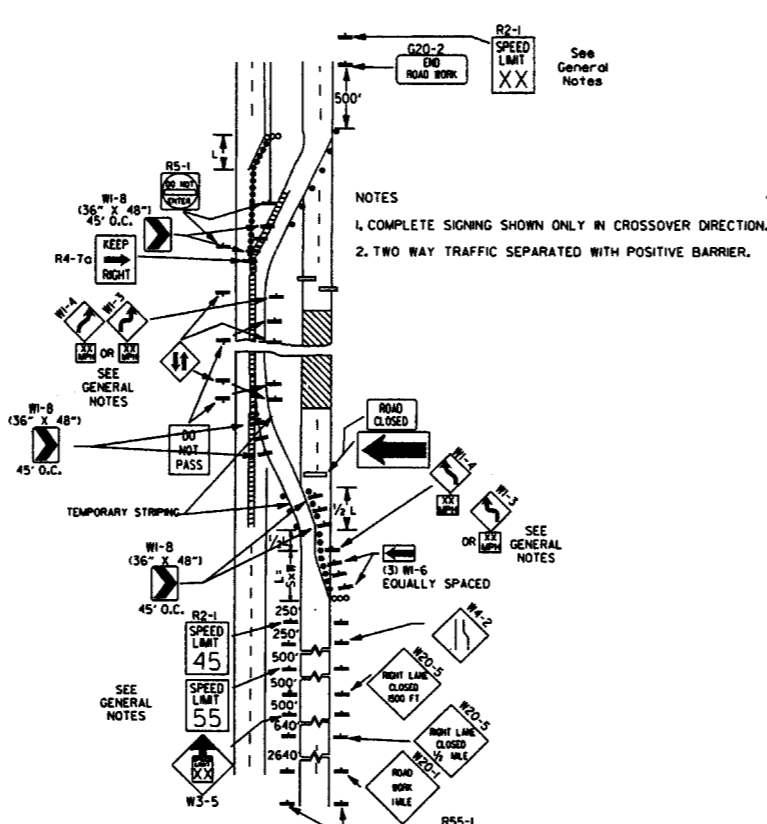


(B) TYPICAL APPLICATION - 4-LANE DIVIDED ROADWAY WHERE ONE ROADWAY IS CLOSED.

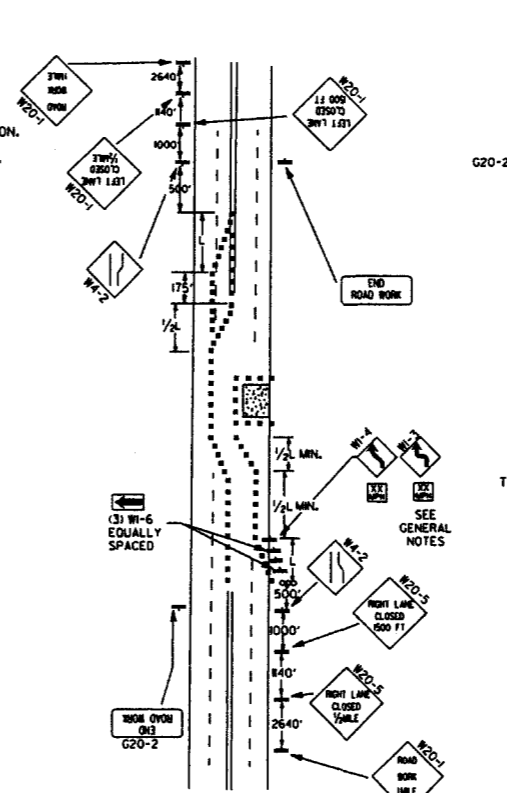


(C) TYPICAL APPLICATION - 4-LANE UNDIVIDED ROADWAY WHERE HALF OF THE ROADWAY IS CLOSED.

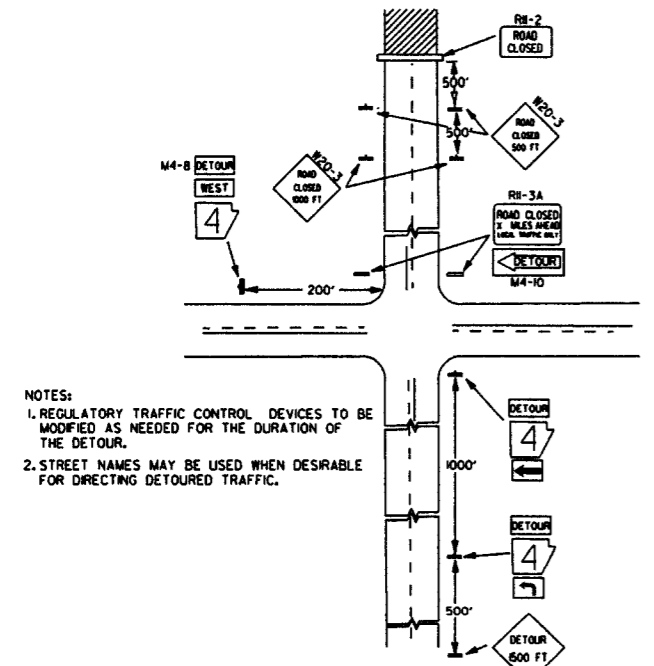


(D) TYPICAL APPLICATION - ROADWAY CLOSED BEYOND DETOUR POINT.

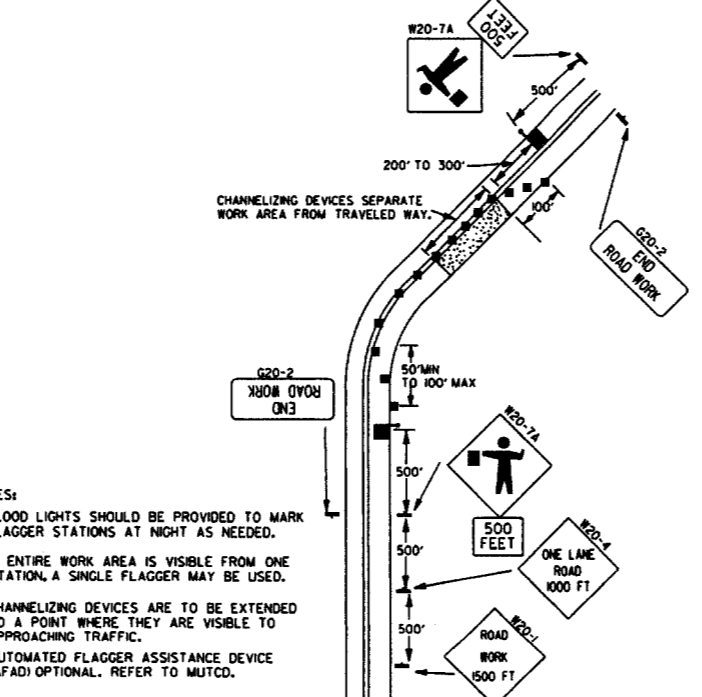

(E) TYPICAL APPLICATION OF TRAFFIC CONTROL DEVICES ON 2-LANE HIGHWAY WHERE ONE LANE IS CLOSED AND FLAGGING IS PROVIDED.

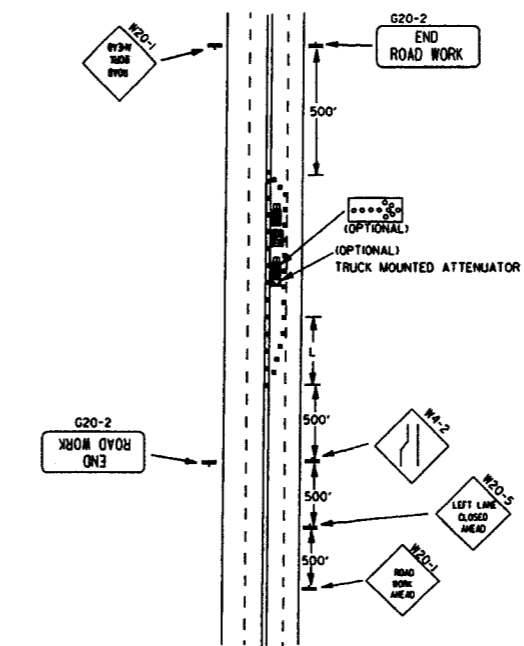

(F) TYPICAL APPLICATION - 4-LANE UNDIVIDED ROADWAY WITH INSIDE LANE CLOSED.

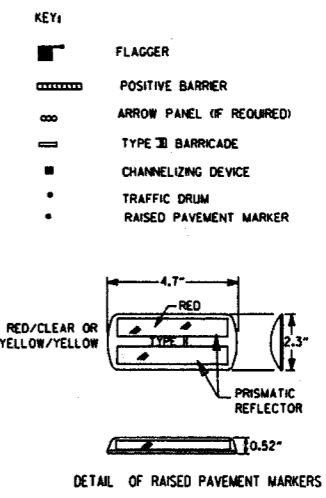

TYPICAL ADVANCE WARNING SIGN PLACEMENT

W20-1 500 FT
 W20-1 1000 FT
 W20-1 1500 FT


TAPER FORMULAE:
 L = SXW FOR SPEEDS OF 45MPH OR MORE.
 L = $\frac{WS^2}{60}$ FOR SPEEDS OF 40MPH OR LESS.
 WHERE:
 L = MINIMUM LENGTH OF TAPER.
 S = NUMERICAL VALUE OF POSTED SPEED LIMIT PRIOR TO WORK OR 85TH PERCENTILE SPEED.
 W = WIDTH OF OFFSET.

- GENERAL NOTES:**
- ADVISORY SPEED POSTED ON W1-3 OR W1-4 CURVE WARNING SIGNS TO BE DETERMINED AT SITE. USE W1-4 WHEN SPEED IS GREATER THAN 30MPH AND W1-3 WHEN 30MPH OR LESS.
 - WHEN THE EXISTING SPEED LIMIT IS 55MPH AND THE PLANS REQUIRE A SPEED LIMIT OF 45MPH, THE R2-1(55) SHALL BE OMITTED AND THE W3-5 SHALL BE INSTALLED AT THAT LOCATION. ADDITIONAL R2-1(45) SPEED LIMIT SIGNS SHALL BE INSTALLED AT A MAXIMUM OF 1 MILE INTERVALS. AT THE END OF THE WORK AREA A R2-1(XX) SHALL BE INSTALLED TO MATCH ORIGINAL SPEED LIMIT.
 - WHEN THE EXISTING SPEED LIMIT IS 65MPH AND THE PLANS REQUIRE A SPEED LIMIT OF 55MPH, THE R2-1(65) SHALL BE OMITTED. ADDITIONAL R2-1(55) SPEED LIMIT SIGNS SHALL BE INSTALLED AT A MAXIMUM OF 1 MILE INTERVALS. AT THE END OF THE WORK AREA A R2-1(XX) SHALL BE INSTALLED TO MATCH ORIGINAL SPEED LIMIT.
 - THE MAXIMUM SPACING BETWEEN CHANNELIZING DEVICES IN A TAPER SHOULD BE APPROXIMATELY EQUAL IN FEET TO THE SPEED LIMIT. BEYOND THE TAPER, MAXIMUM SPACING SHALL BE TWO TIMES THE SPEED LIMIT, OR AS DIRECTED BY THE ENGINEER.
 - WARNING LIGHTS AND/OR FLAGS MAY BE MOUNTED TO SIGNS OR CHANNELIZING DEVICES AT NIGHT AS NEEDED.
 - PAVEMENT MARKINGS NO LONGER APPLICABLE WHICH MIGHT CREATE CONFUSION IN THE MINDS OF VEHICLE OPERATORS SHALL BE REMOVED OR OBLITERATED AS SOON AS PRACTICABLE.
 - TRAILER MOUNTED DEVICES SUCH AS ARROW PANELS AND PORTABLE CHANGEABLE MESSAGE SIGNS SHALL BE DELINEATED BY AFFIXING CONSPICUITY MATERIAL IN A CONTINUOUS LINE ON THE FACE OF THE TRAILER. WHEN PLACED ON OR ADJACENT TO THE SHOULDER AND NOT BEHIND A POSITIVE BARRIER, THESE DEVICES SHALL BE DELINEATED BY PLACING FIVE (5) TRAFFIC DRUMS, EQUALLY SPACED ALONG THE TRAFFIC SIDE OF THE DEVICE.
 - DIMENSIONS SHOWN FOR RAISED PAVEMENT MARKERS ARE TYPICAL. THE CONTRACTOR MAY SUBSTITUTE SIMILAR MARKERS WITH THE APPROVAL OF THE ENGINEER. REQUESTING APPROVAL FOR SIMILAR MARKERS MAY BE MADE BY REFERRING TO THE AHTD QUALIFIED PRODUCTS LIST.


9-2-15	REVISED NOTE 2, ADDED NOTE 6, REVISED DRAWING (A) & REPLACED R2-5A WITH R3-5	
9-12-13	REVISED DETAIL OF RAISED PAVEMENT MARKERS	
3-1-10	ADDED (AFAD)	
1-20-08	REVISED SIGN DESIGNATIONS	
1-18-04	ADDED GENERAL NOTE	
10-18-96	ADDED R55-1	
4-26-96	CORRECTED (a) BEHIND G20-2	
6-8-95	CORRECTED SIGN IDENT. ON W-4A	6-8-95
2-2-95	REVISED PER PART VL MUTCD, SEPT. 3, 1993	
8-15-94	DRAWN AND PLACED IN USE	
DATE	REVISION	FILED

ARKANSAS STATE HIGHWAY COMMISSION
 STANDARD TRAFFIC CONTROLS
 FOR HIGHWAY CONSTRUCTION
 STANDARD DRAWING TC-2





Channelizing devices

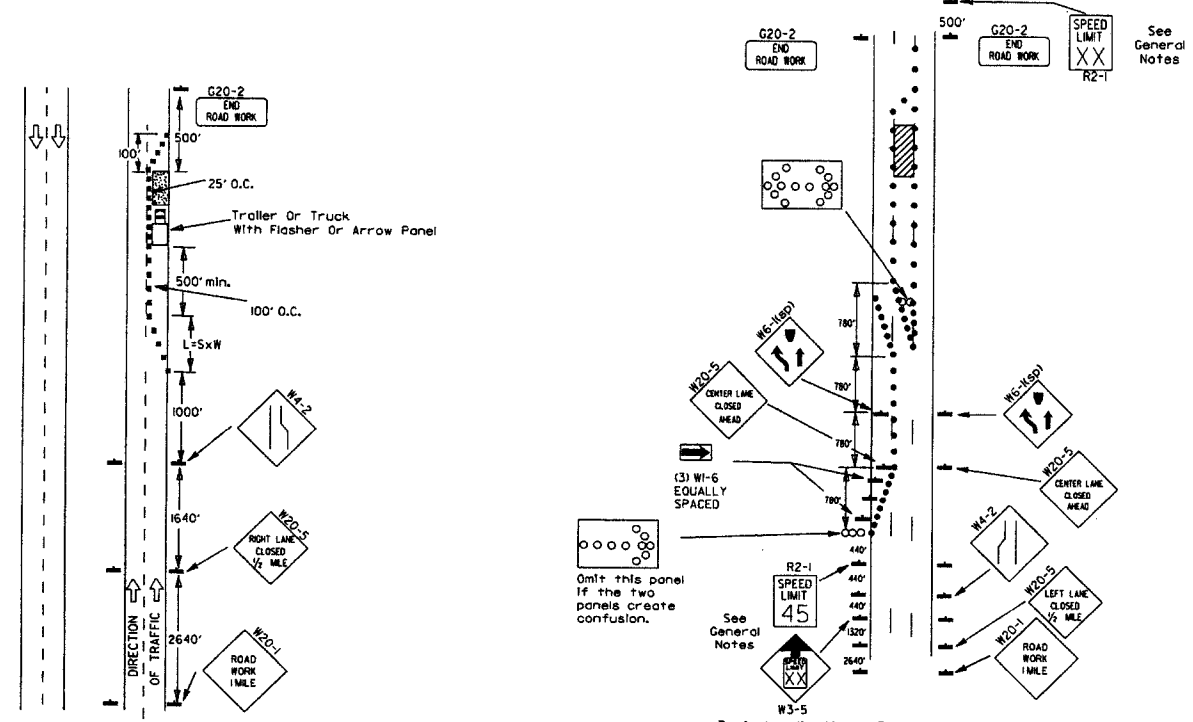


(A) Typical application - daytime maintenance operations of short duration on a 4-lane divided roadway where half of the roadway is closed.

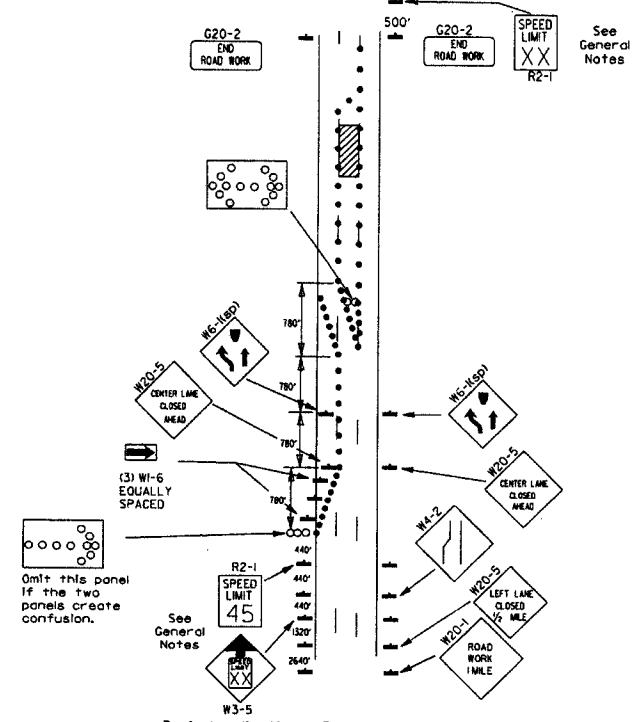

 
(B) Typical application - 3-lane oneway roadway where center lane is closed.

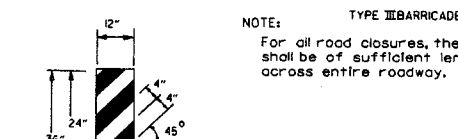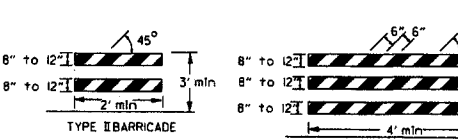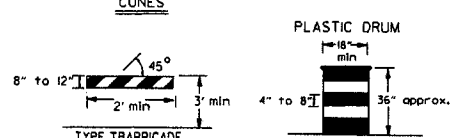

 NOTE: For all road closures, the Type III barricades shall be of sufficient length to extend across entire roadway.




VERTICAL PANEL PLACEMENT

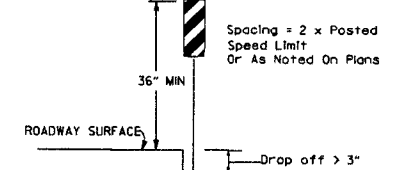


TRAFFIC CONTROL DEVICES FOR VERTICAL PAVEMENT DIFFERENTIALS

VERTICAL DIFFERENTIAL	LOCATIONS	TRAFFIC CONTROL
1" to 3"	Centerline, lane lines	W8-11
1" to 3"	Edge of shoulder	W8-9
Greater than 3"	Lane lines	Standard lane closure required
Greater than 3"	Edge of traveled lane	*RSP-land vertical panels, drums or concrete barrier
Greater than 3"	Edge of shoulder	*Vertical panels, drums or concrete barrier

* When shown on the plans concrete barrier will be used. When the shoulder area is used as part of the traveled lane and there is insufficient width to place drums on the remaining shoulder width, then vertical panels shall be used.

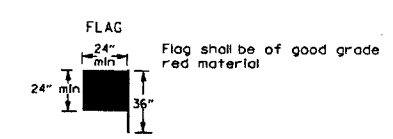


STOP SLOW PADDLE

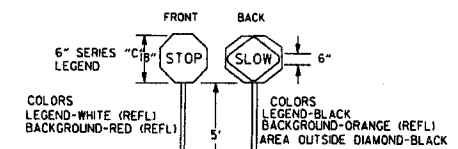


COLORS LEGEND-WHITE (REFL) BACKGROUND-RED (REFL) AREA OUTSIDE DIAMOND-BLACK

DETAIL OF SPLICES

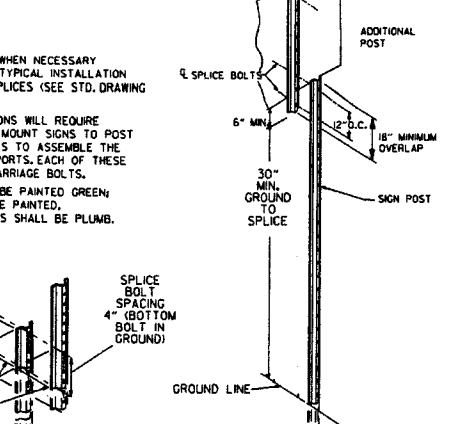

NOTE: USE SPLICES ONLY WHEN NECESSARY FOR INSTALLATION. TYPICAL INSTALLATION SHOULD HAVE NO SPLICES (SEE STD. DRAWING NO. SHS-2). NORMAL INSTALLATIONS WILL REQUIRE 1/4" DIA. BOLTS TO MOUNT SIGNS TO POST AND 5/16" DIA. BOLTS TO ASSEMBLE THE VARIOUS POST SUPPORTS. EACH OF THESE BOLTS SHALL BE CARRIAGE BOLTS. SIGN POSTS SHALL BE PAINTED GREEN; SIGNS SHALL NOT BE PAINTED, AND ALL SIGN POSTS SHALL BE PLUMB.

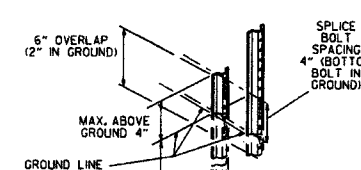


- KEYS:
- Arrow Panel (if Required)
 - Channelizing Device
 - Traffic drum

GENERAL NOTES:

- A speed limit reduction may be implemented ONLY when designated in the plan or when recommended by the Roadway Design Division.
- When the existing speed limit is 55mph and the plans require a speed limit of 45mph, the R2-1(55) shall be omitted and the W3-5 shall be installed at that location. Additional R2-1(45) speed limit signs shall be installed at a maximum of 1/2 mile intervals. At the end of the work area a R2-1(XX) shall be installed to match original speed limit.
- When the existing speed limit is 65mph and the plans require a speed limit of 55mph, the R2-1(65) shall be omitted. Additional R2-1(55) speed limit signs shall be installed at a maximum of 1/2 mile intervals. At the end of the work area a R2-1(XX) shall be installed to match original speed limit.
- The maximum spacing between channelizing devices in a taper should be approximately equal in feet to the speed limit. Beyond the taper, maximum spacing shall be two times the speed limit or as directed by the Engineer.
- Warning lights and/or flags may be mounted to signs or channelizing devices at night as needed.
- Pavement markings no longer applicable which might create confusion in the minds of vehicle operators shall be removed or obliterated as soon as practicable.
- The G20-1 sign will be required on jobs of over two miles in length. When the lane closure is not at the beginning of the project, the G20-1 sign shall be erected 125' in advance of the job limit. Additional W20-1(1/2 MILE) signs are not required in advance of lane closures that begin inside the project limits.
- Flaggers shall use STOP/SLOW paddles for controlling traffic through work zones. Flags may be used only for emergency situations.
- All plastic drums and cones shall meet the requirements of NCHRP-350 or Manual For Assessing Safety Hardware (MASH).
- Trawler mounted devices such as arrow panels and portable changeable message signs shall be delineated by affixing conspicuity material in a continuous line on the face of the trawler. When placed on or adjacent to the shoulder and not behind a positive barrier, these devices shall be delineated by placing five (5) traffic drums, equally spaced along the traffic side of the device.

(C) Typical application - construction operations of intermediate to long term duration on a 4-lane divided roadway where half of the roadway is closed.







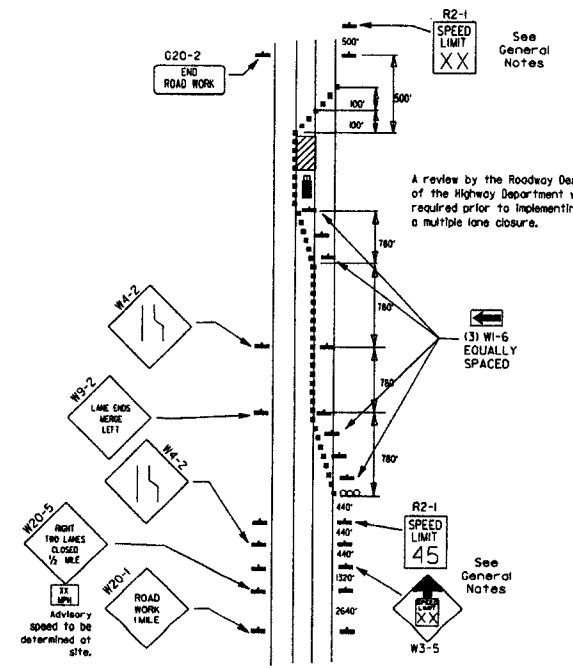


(D) Typical application - closing multiple lanes of a multilane highway.


DATE	REVISION	FILED
9-2-15	REVISED NOTE 2 & REPLACED R2-5A WITH W3-5	
10-15-09	ADDED REFERENCE TO MASH	
11-20-08	REVISED SIGN DESIGNATIONS	
1-18-04	ADDED NOTE	
10-1-98	ADDED NOTE	
4-03-97	ADDED (SP) TO W6-1 & REVISED TRAFFIC CONTROL DEVICES NOTE	
10-18-96	ADDED R55-1	
10-12-95	MOVED UPPER SPLICE	
6-8-95	REVISED SPLICE DETAIL, TEXT	6-8-95
2-2-95	REVISED PER PART VI, MUTCD, SEPT. 3, 1993	
8-15-91	DRAWN AND PLACED IN USE	

ARKANSAS STATE HIGHWAY COMMISSION
STANDARD TRAFFIC CONTROLS FOR HIGHWAY CONSTRUCTION
STANDARD DRAWING TC-3




REINFORCING BAR TABLE PER BARRIER UNIT			
MARK	LOCATION	BAR SIZE	(NO. BARS)
H-1	HORIZONTAL IN BARRIER TIED INSIDE V-1 BARS	#5	(16)
H-2	CENTERED ABOVE DRAIN SLOTS LONG. & TRANSVERSELY	#5	(16)
H-3	TIED ABOVE H-1 BARS TO SUPPORT H-2, TIED TO V-1	#4	(2)
S-1	OVER LIFT HOLES	#4	(2)
S-2	HORIZ. AROUND SLOTS BETWEEN V-1'S & DRAIN SLOTS	#4	(2)
V-1	VERTICAL IN BARRIER (3) EACH END & (2) AT EACH DRAIN SLOTS	#5	(16)

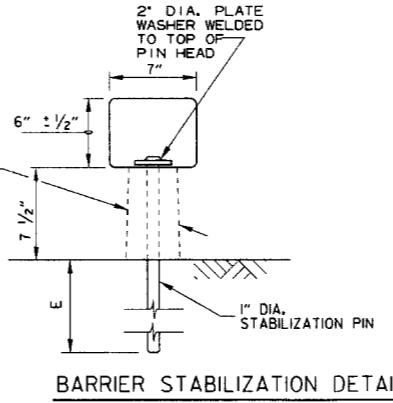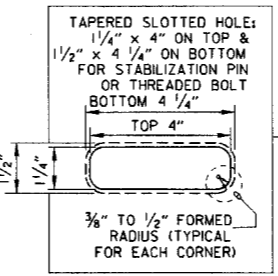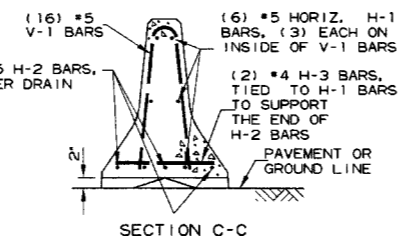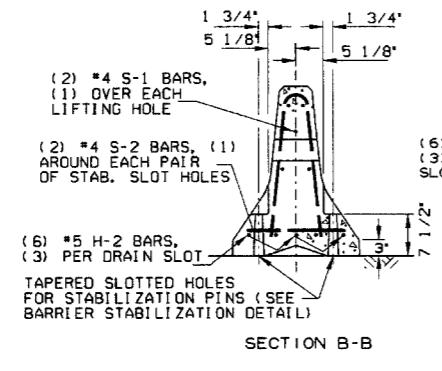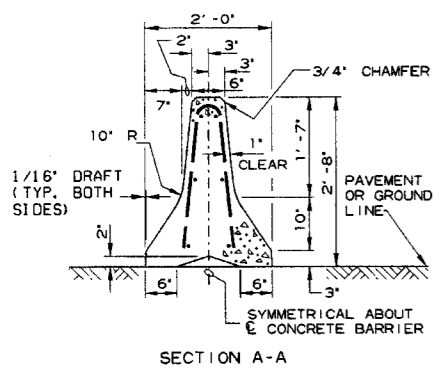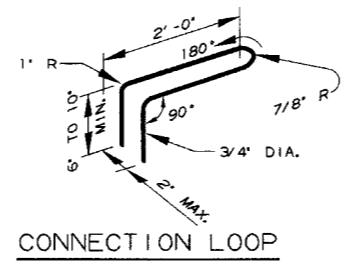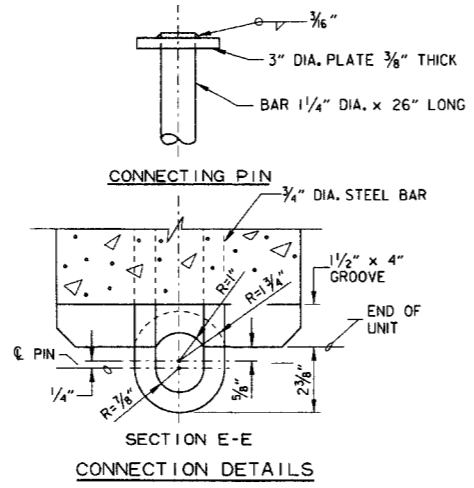

- E 4" - Concrete Pavement
- 8" - Asphalt Pavement
- 12" - Shoulder Areas

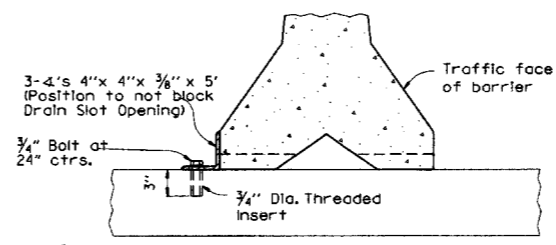

NOTE: 3/4" Threaded Inserts shall be cast in place for all new bridge decks and drilled and grouted for existing bridge decks. Inserts shall have a minimum ultimate load capacity of 8000 lbs. in tension. After removal of barrier, bolts, and angles, the inserts shall be filled with approved non-shrink epoxy.

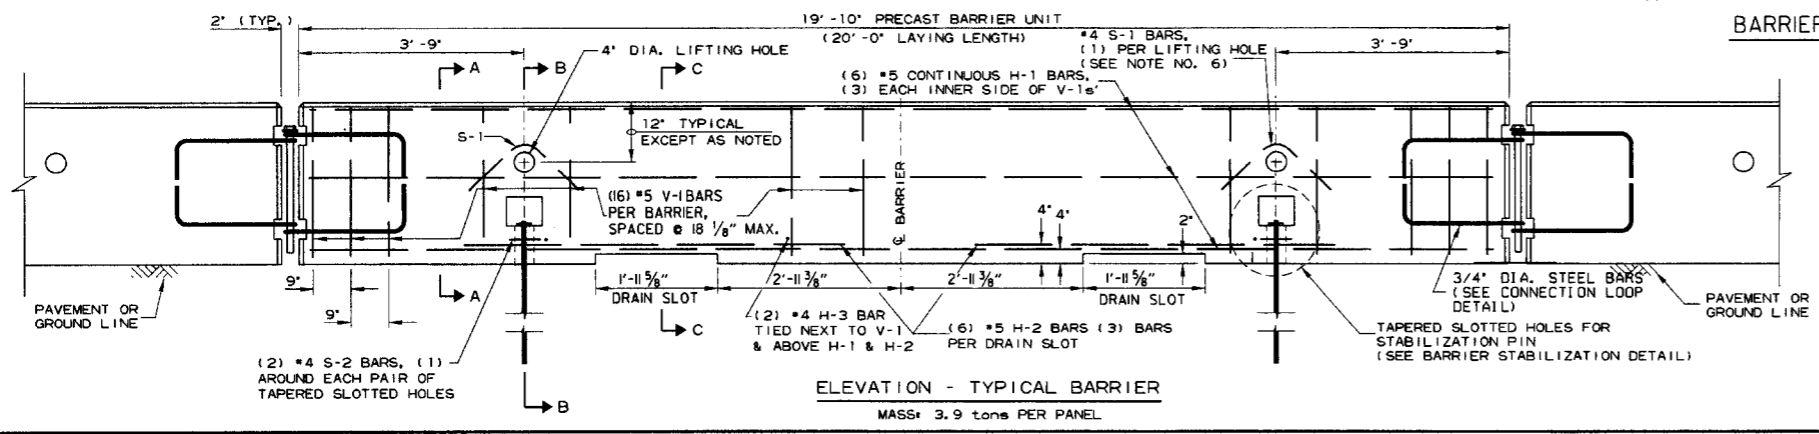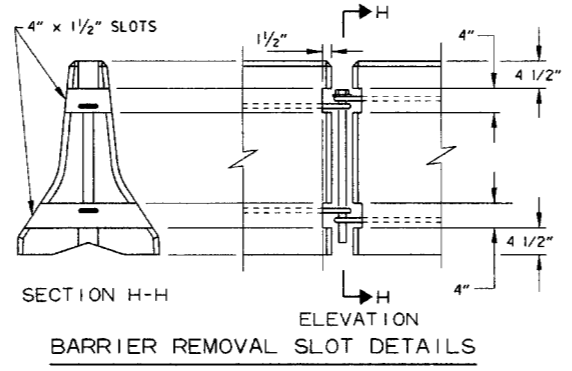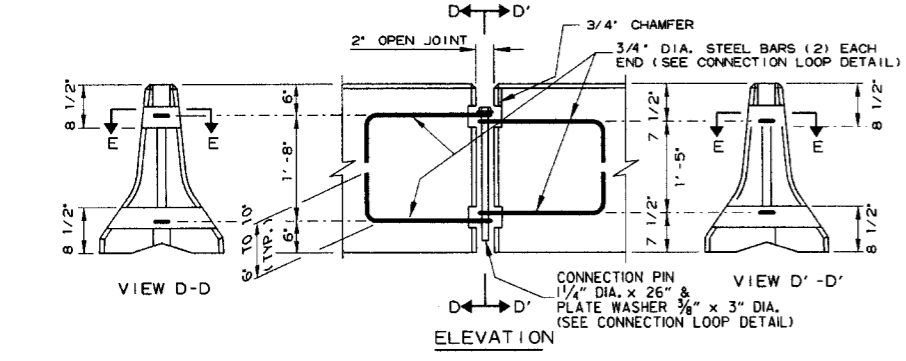


- General Notes**
- The contractor shall furnish the Precast Concrete Barrier Units and shall be responsible for the manufacture, shipment, storage, placement and removal. At the completion of the project, the precast units will remain the property of the contractor.
 - Materials shall meet the following minimum requirements:
 Concrete: 2500 psi compressive strength at 28 days.
 Reinforcing Steel: AASHTO M 31 or M 53, Grade 60
 Structural Steel: AASHTO-M270 Grade 36 shall be used for the Connection Pin, Connection Loops, and Stabilization Pins. A One Piece Pin with a 3" rounded top may be used in place of the detailed Connection Pin.
 Delineators: Delineators shall be mounted at 10' spacing on top of precast barrier.

 In applications where barrier walls within 6 feet of a traffic lane, additional delineators shall be placed on the barrier at 10' spacing approximately one (1) foot from the top of the barrier. Delineators shall be on the AHTD Qualified Products List for Construction Concrete Barrier Markers. Delineator color shall be in accordance with the Manual Uniform Traffic Control Devices. Payment for delineators shall be considered included in the price bid per Lin. Ft. for "Furnishing and Installing Precast Concrete Barrier". The contractor shall certify to the Engineer that the material and the design used in the precast barrier units meets the requirements as shown on this standard drawing.
 - Other Precast Concrete Barriers that have been crash tested and approved by the Federal Highway Administration to meet the requirements of NCHRP-350 test level 3 or Manual For Assessing Safety Hardware (MASH) will be accepted in lieu of the barrier shown. Drain slots shall be provided as needed or as directed by the Engineer. The Contractor shall furnish a certification of NCHRP Report 350 or Manual For Assessing Safety Hardware (MASH) compliance for any other types of precast barrier to be used. The certification shall state that the precast concrete barrier meets the requirements of NCHRP Report 350 or Manual For Assessing Safety Hardware (MASH) and include a copy of the Federal Highway Administration's (FHWA) approval letter with all attachments. Precast concrete barrier units shall be fabricated and installed in accordance with crash testing and documentation provided in the FHWA approval letter. Mixing of shapes will not be allowed in a continuous line of units.
 - Dowel holes in pavement or bridge slabs that are to remain in place shall be filled. Holes in concrete pavement and bridge slabs shall be filled with an approved non-shrink epoxy grout. Holes in asphalt pavement shall be filled with an approved asphalt joint filler. Payment for drilling and filling holes to be included in the price for various barrier items.
 - Attach Units To Roadway Surface with Stabilization Pins and to Deck Slabs using bolts when required.
 - A 4" White PVC Sleeve may be used to form the Lifting Hole and if used the Sleeve is to be left in place.

DATE	REVISION	FILED
2-27-14	REVISED BARRIER STABILIZATION DETAIL	
10-15-09	ADDED REFERENCE TO MASH	
8-5-09	REV. NOTE 3 CONCERNING DRAIN SLOTS	
8-29-07	REVISED NOTE 3	
5-25-06	DELETED GENERAL NOTE 7	
11-18-04	REVISED BARRIER STABILIZATION DETAIL BRIDGE DECKS	
4-10-03	REVISED GENERAL NOTE 2	
8-22-02	ISSUED NEW DRAWING	


ARKANSAS STATE HIGHWAY COMMISSION
 STANDARD TRAFFIC CONTROLS FOR HIGHWAY CONSTRUCTION - TEMPORARY PRECAST BARRIER
 STANDARD DRAWING TC-4

(A) 4 feet or greater preferred. If less than 4 feet, Precast Units shall be connected to slab (SEE BARRIER STABILIZATION DETAIL-BRIDGE DECKS STD. DRWG. TC-4)

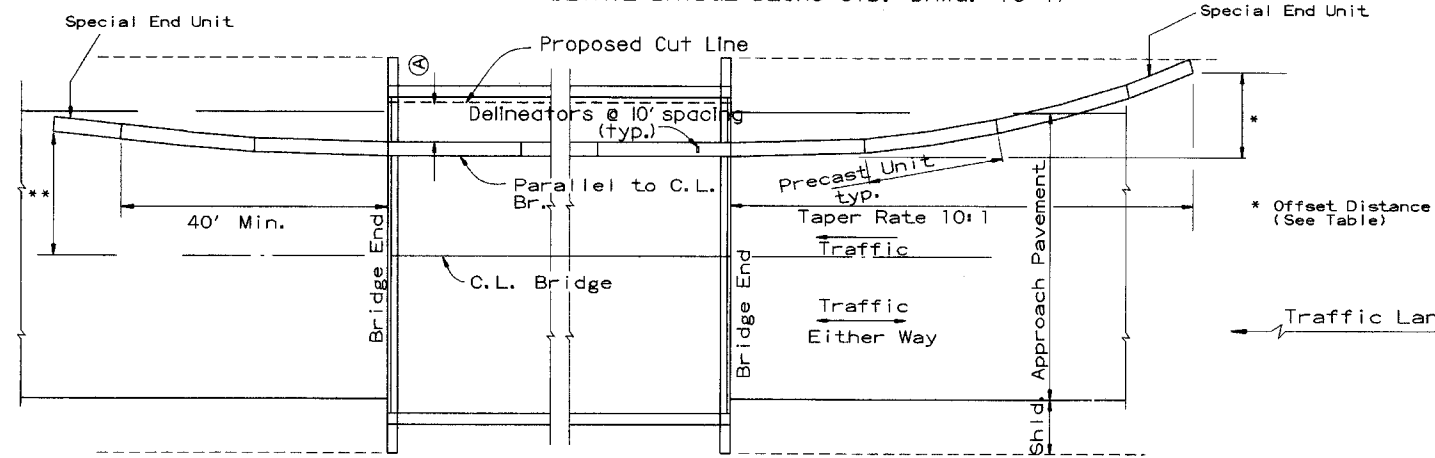

BARRIER PLACEMENT ALONG BRIDGE WITH OFFSET


No Scale

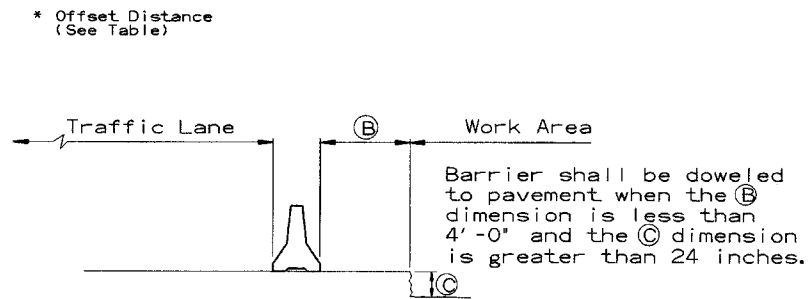

SECTION J-J

No Scale

** Offset Distance for Two Way Traffic Only

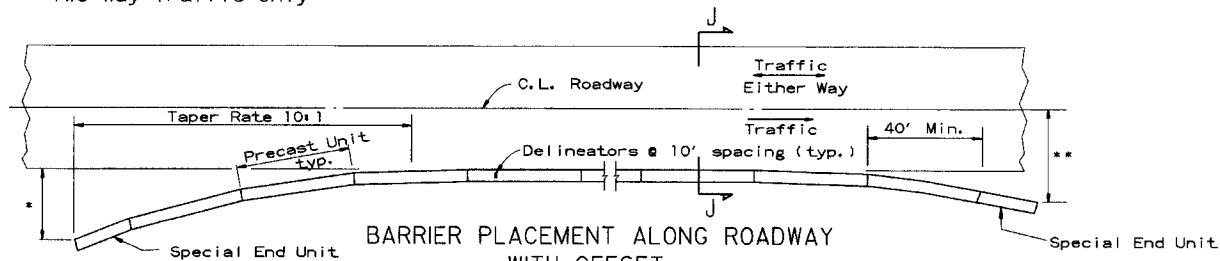

BARRIER PLACEMENT ALONG ROADWAY WITH OFFSET


No Scale

** Offset Distance for Two Way Traffic Only

* Offset Distance (See Table)

Speed (MPH)	Offset Distance (FT.)
≤ 45	12
> 45	18

If offset distance is not attainable, then see 'Barrier Placement With Attenuator' Detail shown below.

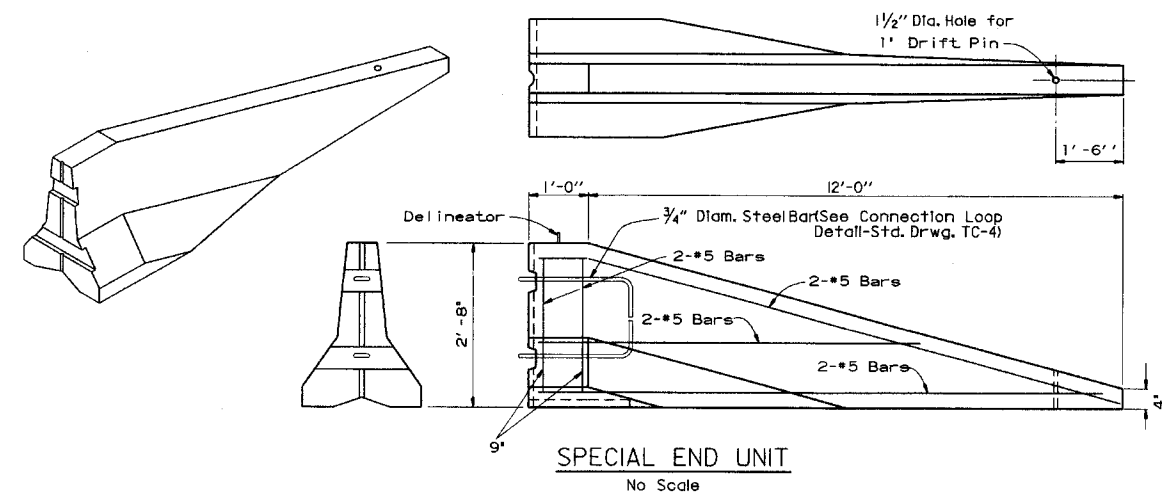


SPECIAL END UNIT

No Scale

General Notes

When shown on the Plans, the ends of the Temporary Precast Concrete Barrier shall be protected with an NCHRP-350 or Manual For Assessing Safety Hardware (MASH) approved Crash Cushion. Payment for Crash Cushions shall be made under the item of "Temporary Impact Attenuation Barrier."

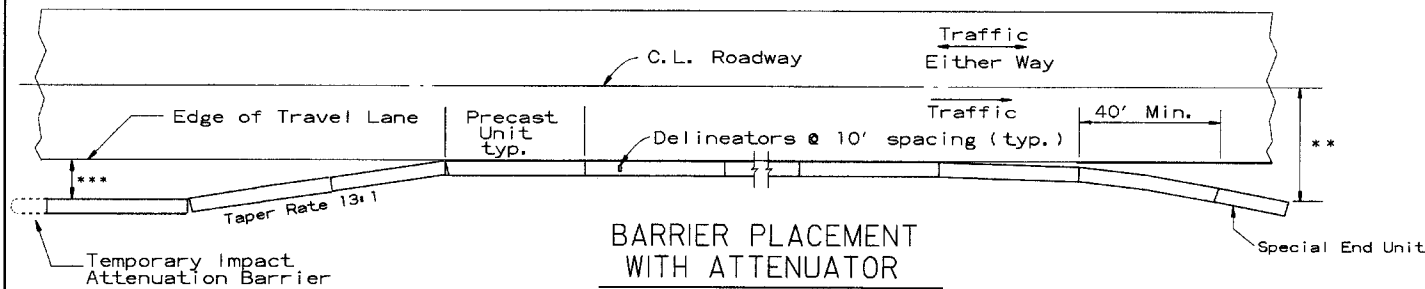

BARRIER PLACEMENT WITH ATTENUATOR

No Scale

** Offset Distance for Two Way Traffic Only

***Min. 3'-0" From Edge of Travel Lane to Nearest Edge of Attenuator

DATE	REVISION	FILMED
10-15-09	ADDED REFERENCE TO MASH	
5-25-06	REVISED BARRIER PLACEMENT	
8-22-02	ISSUED NEW DRAWING	


ARKANSAS STATE HIGHWAY COMMISSION

STANDARD TRAFFIC CONTROLS
FOR HIGHWAY CONSTRUCTION -
TEMPORARY PRECAST BARRIER


STANDARD DRAWING TC-5

GENERAL NOTES


INSTALL A MINIMUM OF 2 UPSLOPE STAKES AND 4 DOWNSLOPE STAKES AT AN ANGLE TO WEDGE WATTLE TO BOTTOM OF DITCH.

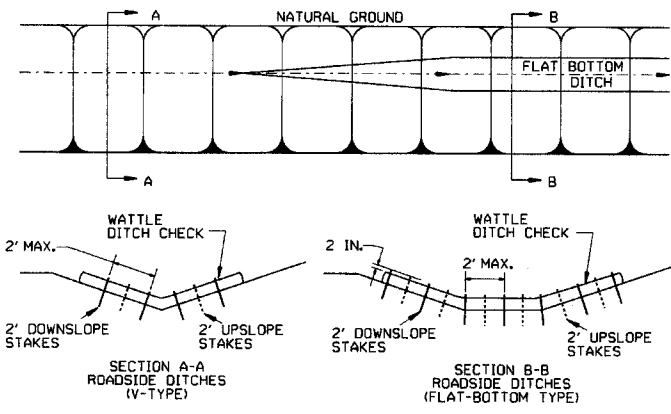

WATTLE DITCH CHECK (E-1)

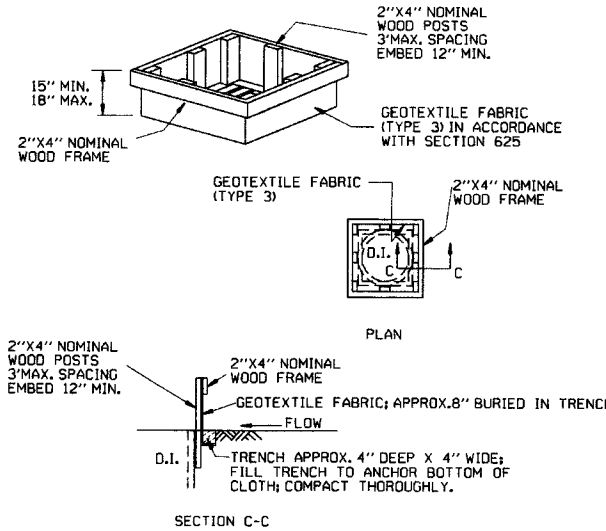


DROP INLET SILT FENCE (E-7)

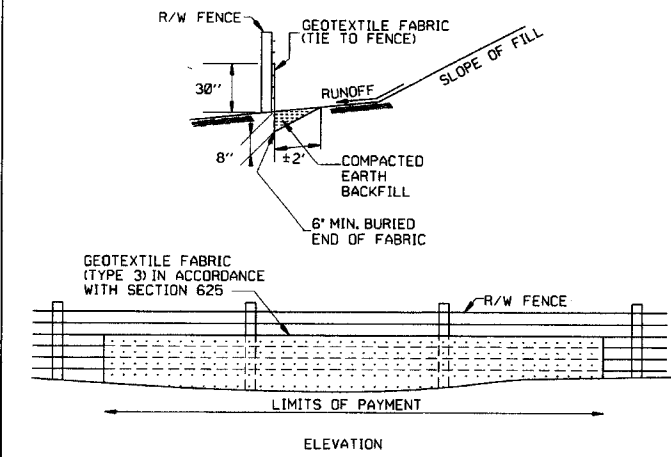


SILT FENCE ON R/W FENCE (E-4)

GENERAL NOTES
 GEOTEXTILE FABRIC SHALL BE SPliced TOGETHER WITH A SEWN SEAM ONLY AT A SUPPORT POST, OR TWO SECTIONS OF FENCE MAY BE OVERLAPPED INSTEAD. PAYMENT OF ADDITIONAL MATERIAL FOR OVERLAP WILL NOT BE MADE.


GENERAL NOTES
 1. STRAW BALES SHALL BE INSTALLED SO THAT THE BINDINGS ARE ORIENTED AROUND THE SIDES RATHER THAN ALONG THE TOPS AND BOTTOMS OF THE BALES. THE BALES SHALL BE A MINIMUM OF 30 INCHES IN LENGTH.
 2. NO GAPS SHALL BE LEFT BETWEEN BALES.
 3. BALED STRAW FILTER BARRIERS COMPLETED AND ACCEPTED WILL BE MEASURED BY THE BALE IN PLACE AS AUTHORIZED BY THE ENGINEER AND WILL BE PAID FOR AT THE CONTRACT UNIT PRICE BID PER BALE FOR BALED STRAW DITCH CHECKS.

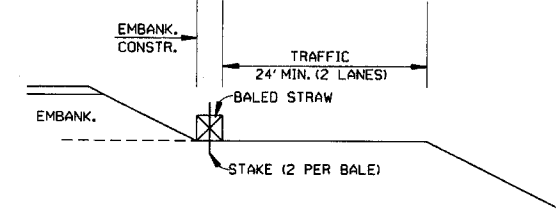

BALED STRAW FILTER BARRIER (E-2)

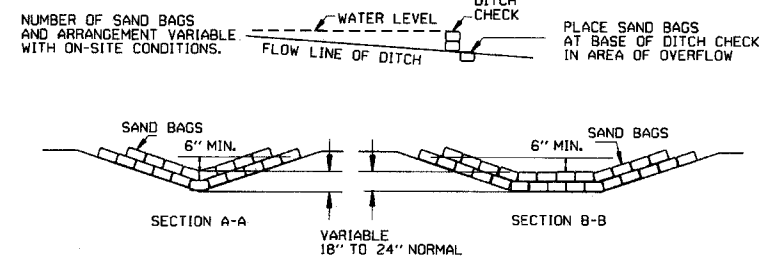


SAND BAG DITCH CHECK (E-5)

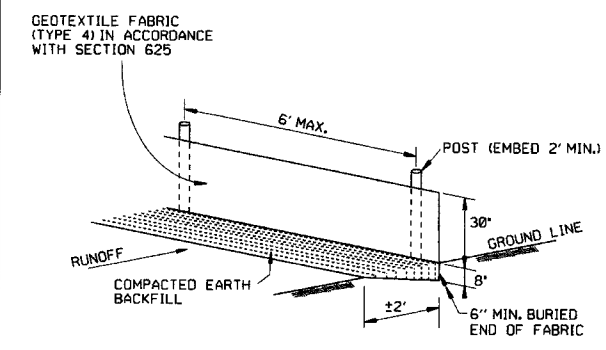


SILT FENCE (E-11)

GENERAL NOTES
 GEOTEXTILE FABRIC SHALL BE SPliced TOGETHER WITH A SEWN SEAM ONLY AT A SUPPORT POST OR TWO SECTIONS OF FENCE MAY BE OVERLAPPED INSTEAD. PAYMENT OF ADDITIONAL MATERIAL FOR OVERLAP WILL NOT BE MADE.

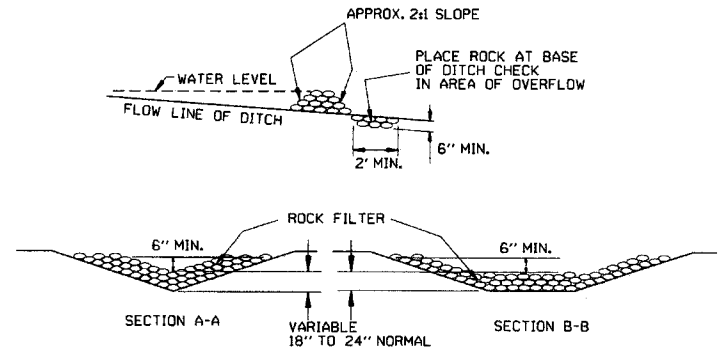


ROCK DITCH CHECK (E-6)


12-15-11	DELETED BALED STRAW DITCH CHECK & ADDED WATTLE DITCH CHECK		ARKANSAS STATE HIGHWAY COMMISSION
11-18-98	ADDED NOTES		
7-02-98	ADDED BALED STRAW FILTER BARRIER (E-2)		TEMPORARY EROSION CONTROL DEVICES
7-20-95	REVISED SILT FENCE E-4 AND E-11	7-20-95	
7-15-94	REV. E-4 & E-11 MIN. 13\"/>		
6-2-94	REVISED E-1, 4, 7 & 11; DELETED E-2 & 3	6-2-94	STANDARD DRAWING TEC-1
4-1-93	REDRAWN		
10-1-92	REDRAWN		
8-2-76	ISSUED R.D.M.	298-7-28-76	
DATE	REVISION	FILMED	

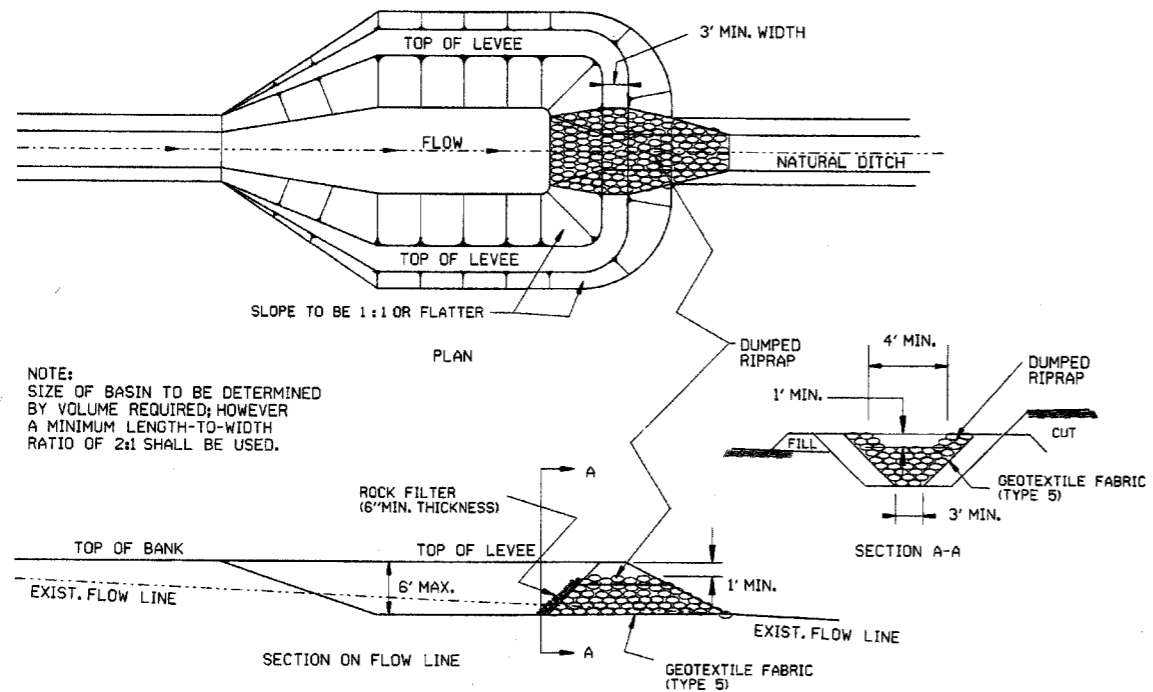


SEDIMENT BASIN WITH RIPRAP OUTLET (E-9)

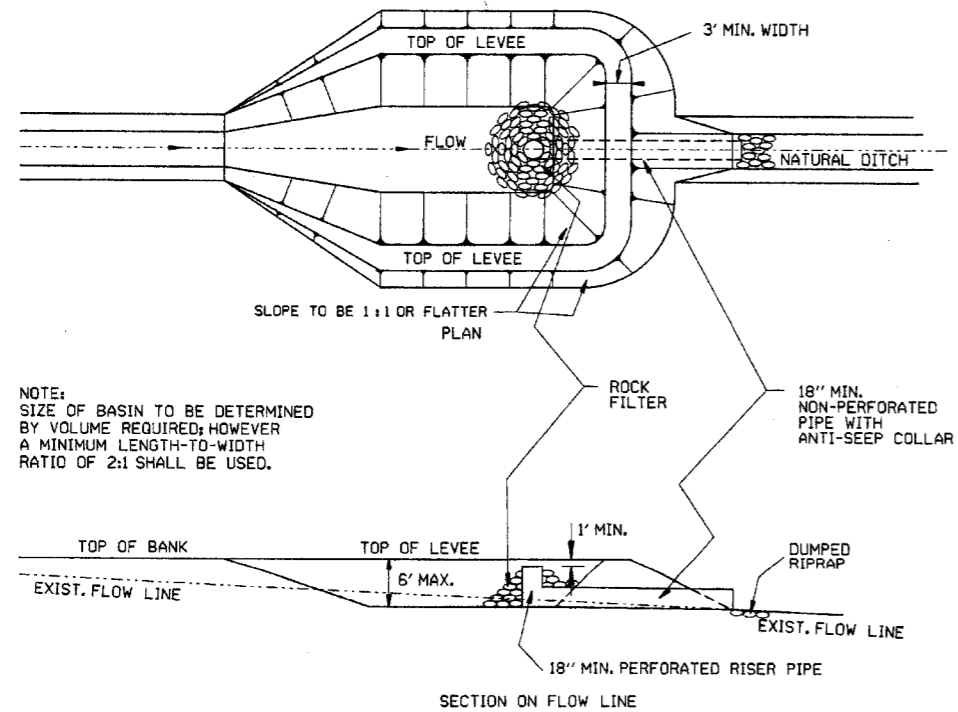


SEDIMENT BASIN WITH PIPE OUTLET (E-10)

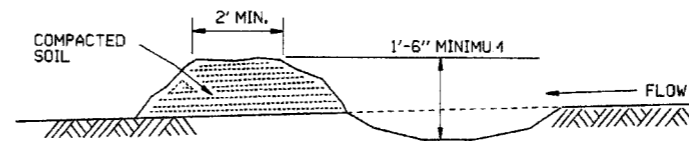

DIVERSION DITCH (E-8)

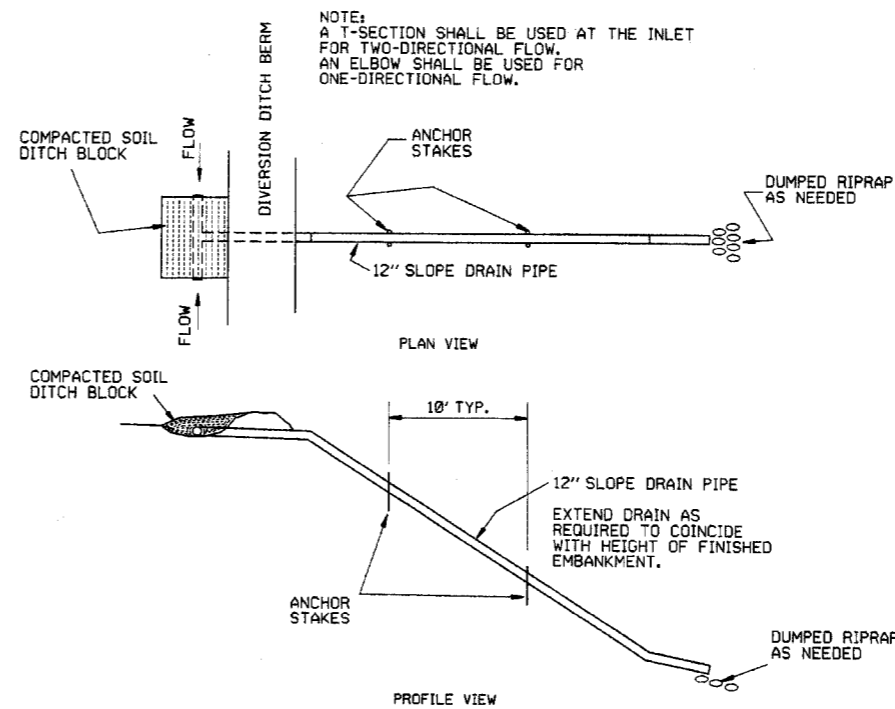

SLOPE DRAIN (E-12)

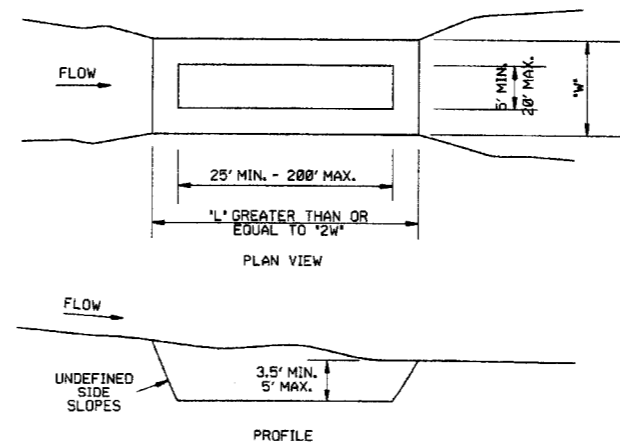

SEDIMENT BASIN (E-14)


			ARKANSAS STATE HIGHWAY COMMISSION
			TEMPORARY EROSION CONTROL DEVICES
6-2-94	Revised E-8 & E-12; Added E-14 & Deleted E-13		STANDARD DRAWING TEC-2
4-1-93	ISSUED		
DATE	REVISION	FILMED	

CLEARING AND GRUBBING

CONSTRUCTION SEQUENCE

1. PLACE PERIMETER CONTROLS (I.E. SILT FENCES, DIVERSION DITCHES, SEDIMENT BASINS, ETC.)
2. PERFORM CLEARING AND GRUBBING OPERATION.

EXCAVATION

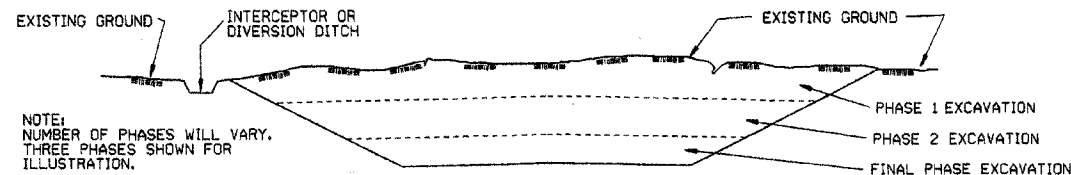

NOTE:
NUMBER OF PHASES WILL VARY.
THREE PHASES SHOWN FOR
ILLUSTRATION.


GENERAL NOTE

ALL CUT SLOPES SHALL BE DRESSED, PREPARED, SEEDED, AND MULCHED AS THE WORK PROGRESSES. SLOPES SHALL BE EXCAVATED AND STABILIZED IN EQUAL INCREMENTS NOT TO EXCEED 25 FEET, MEASURED VERTICALLY.

CONSTRUCTION SEQUENCE

1. EXCAVATE AND STABILIZE INTERCEPTOR AND/OR DIVERSION DITCHES.
2. PERFORM PHASE 1 EXCAVATION. PLACE PERMANENT OR TEMPORARY SEEDING.
3. PERFORM PHASE 2 EXCAVATION. PLACE PERMANENT OR TEMPORARY SEEDING.
4. PERFORM FINAL PHASE OF EXCAVATION. PLACE PERMANENT OR TEMPORARY SEEDING. STABILIZE DITCHES. CONSTRUCT DITCH CHECKS, DIVERSION DITCHES, SEDIMENT BASINS, OR OTHER EROSION CONTROL DEVICES AS REQUIRED.

EMBANKMENT

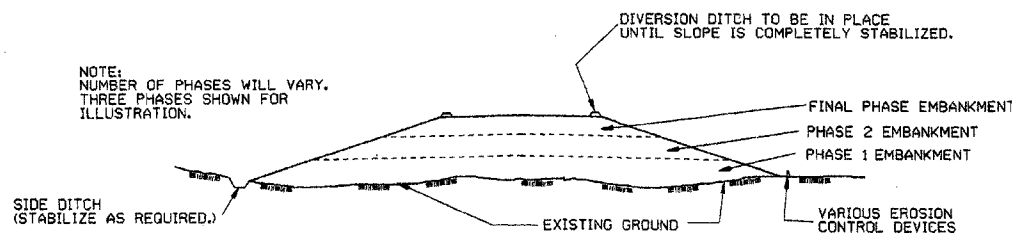

NOTE:
NUMBER OF PHASES WILL VARY.
THREE PHASES SHOWN FOR
ILLUSTRATION.


GENERAL NOTE

ALL EMBANKMENT SLOPES SHALL BE DRESSED, PREPARED, SEEDED, AND MULCHED AS THE WORK PROGRESSES. SLOPES SHALL BE CONSTRUCTED AND STABILIZED IN EQUAL INCREMENTS NOT TO EXCEED 25 FEET, MEASURED VERTICALLY.


CONSTRUCTION SEQUENCE

1. CONSTRUCT DIVERSION DITCHES, DITCH CHECKS, SEDIMENT BASINS, SILT FENCES, OR OTHER EROSION CONTROL DEVICES AS SPECIFIED.
2. PLACE PHASE 1 EMBANKMENT WITH PERMANENT OR TEMPORARY SEEDING. PROVIDE DIVERSION DITCHES AND SLOPE DRAINS IF EMBANKMENT CONSTRUCTION IS TO BE TEMPORARILY ABANDONED FOR A PERIOD OF GREATER THAN 21 DAYS.
3. PLACE PHASE 2 EMBANKMENT WITH PERMANENT OR TEMPORARY SEEDING. PROVIDE DIVERSION DITCHES AND SLOPE DRAINS IF EMBANKMENT CONSTRUCTION IS TO BE TEMPORARILY ABANDONED FOR A PERIOD OF GREATER THAN 21 DAYS.
4. PLACE FINAL PHASE OF EMBANKMENT WITH PERMANENT OR TEMPORARY SEEDING. PLACE DIVERSION DITCHES AND SLOPE DRAINS AND MAINTAIN UNTIL ENTIRE SLOPE IS STABILIZED.

ARKANSAS STATE HIGHWAY COMMISSION		
TEMPORARY EROSION CONTROL DEVICES		
STANDARD DRAWING TEC-3		
11-93-94	CORRECTED SPELLING	
8-2-94	Drawn & Issued	6-2-94
DATE	REVISION	FILMED

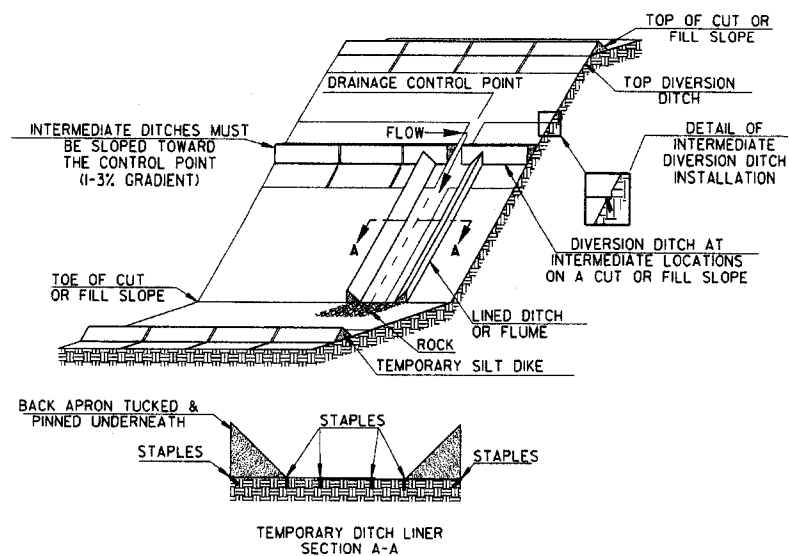


TRIANGULAR SILT DIKE INSTALLATION FOR DIVERSION DITCH AND/OR DITCH LINER

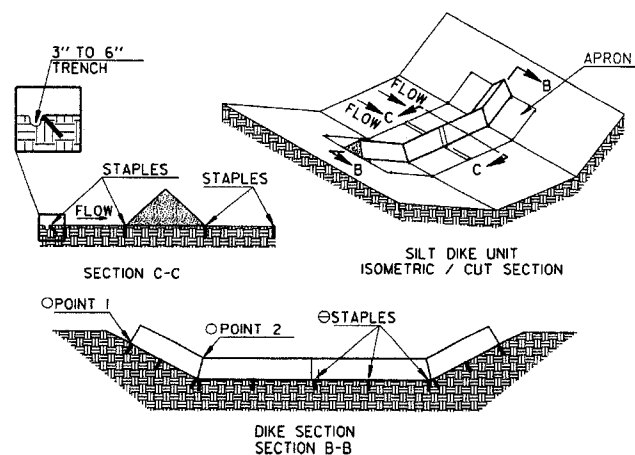


TRIANGULAR SILT DIKE INSTALLATION FOR ROADWAY DITCH OR DRAINAGE DITCH


○ POINT "1" MUST BE HIGHER THAN POINT "2" TO ENSURE THAT WATER FLOWS OVER THE DIKE AND NOT AROUND THE ENDS.
 ⊗ STAPLES SHALL BE PLACED WHERE THE UNITS OVERLAP AND IN THE CENTER OF THE UNIT AS SHOWN ON THE DIAGRAM.

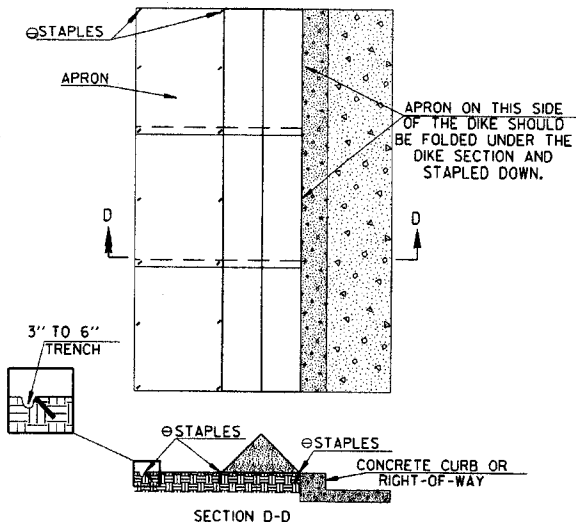

TRIANGULAR SILT DIKE INSTALLATION FOR CONTINUOUS BARRIER

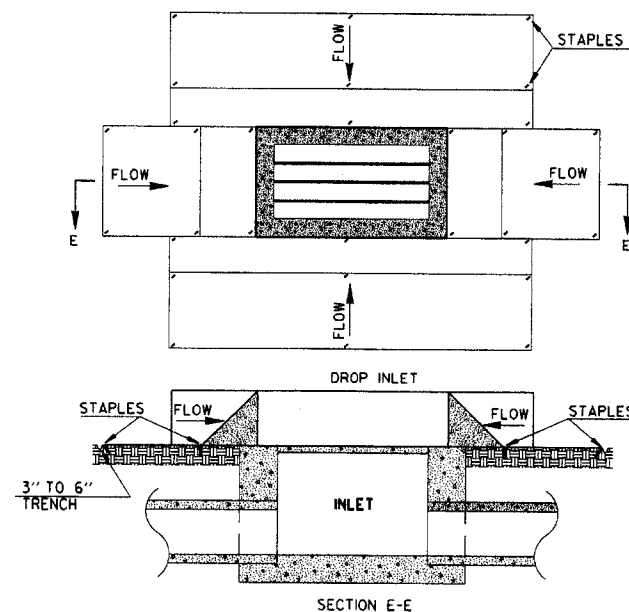

TRIANGULAR SILT DIKE INSTALLATION FOR DROP INLETS

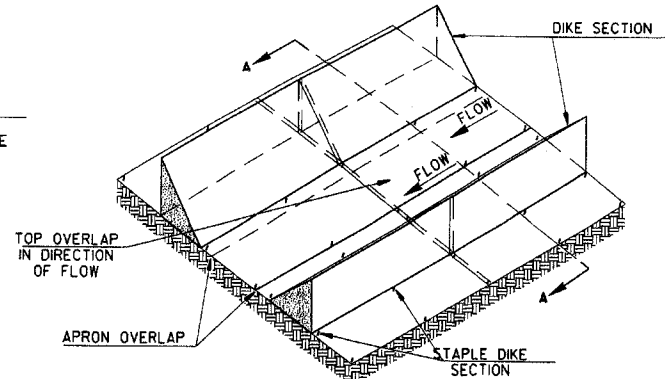


TRIANGULAR SILT DIKE INSTALLATION FOR TEMPORARY DITCH LINER

GENERAL NOTES

1. THIS WORK SHALL CONSIST OF FURNISHING, INSTALLING, AND MAINTAINING THE TRIANGULAR SILT DIKE. THE DIKES SHALL BE USED AS A CONTINUOUS LINE BARRIER AT THE TOE OF SLOPE OR ACROSS THE ROADWAY DITCH TO CONTAIN SEDIMENT AND MINIMIZE EROSION, OR AS DIRECTED BY THE ENGINEER. THESE DIKES SHALL BE INSTALLED AND LOCATED AS SOON AS CONSTRUCTION WILL ALLOW OR AS DIRECTED BY THE ENGINEER.
2. TRIANGULAR SILT DIKE SHALL BE TRIANGULAR SHAPED HAVING A HEIGHT OF AT LEAST 8" TO 10" IN THE CENTER WITH EQUAL SIDES AND A 16" TO 20" BASE. THE TRIANGULAR SHAPED INNER MATERIAL SHALL BE URETHANE FOAM. THE OUTER COVER SHALL BE A WOVEN GEOTEXTILE FABRIC PLACED AROUND THE INNER MATERIAL & ALLOWED TO EXTEND BEYOND BOTH SIDES OF THE TRIANGLE 24" TO 36". THIS FABRIC SHOULD BE MILDEW RESISTANT, ROT-PROOF AND RESISTANT TO HEAT AND ULTRAVIOLET RADIATION MEETING REQUIREMENTS FOR SEDIMENT CONTROL IN AASHTO M288. THE DIKES SHALL BE ATTACHED TO THE GROUND WITH WIRE STAPLES. THE STAPLES SHALL BE NO. 11 GAUGE WIRE AND BE AT LEAST 6" TO 8" LONG. STAPLES SHALL BE PLACED AS SHOWN ON THESE DETAILS.
3. ACCEPTED TRIANGULAR SILT DIKE, MEASURED AS PROVIDED ABOVE, WILL BE PAID FOR AT THE CONTRACT UNIT PRICE BID FOR TRIANGULAR SILT DIKE. PRICE BID WILL INCLUDE THE COST OF FURNISHING THE DIKES, INSTALLING, MAINTAINING AND REMOVAL WHEN DIRECTED BY THE ENGINEER.

THE CONTRACTOR SHALL INSPECT ALL DIKES AFTER EACH RAINFALL EVENT OF AT LEAST 0.5" OR GREATER. ANY DEFICIENCIES OR DAMAGE SHALL BE REPAIRED BY THE CONTRACTOR. ACCUMULATED SILT OR DEBRIS SHALL BE REMOVED AND RELOCATED AS DIRECTED BY THE ENGINEER. IF THE DIKES ARE DAMAGED OR INADVERTENTLY MOVED DURING THE SILT REMOVAL PROCESS, THE CONTRACTOR SHALL IMMEDIATELY REPLACE AFTER DAMAGE OCCURS.

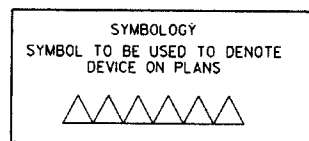

NOTE: SILT DIKE SHOULD ONLY BE USED FOR DROP INLETS IN SUMP LOCATIONS.

		ARKANSAS STATE HIGHWAY COMMISSION	
		TEMPORARY EROSION CONTROL DEVICES	
		STANDARD DRAWING TEC-4	
7-26-12	REVISED GENERAL NOTE 2.		
12-15-11	ISSUED		
DATE	REVISION		FILMED

GENERAL NOTES:

STEEL LINE POSTS SHALL BE PAINTED OR GALVANIZED. TUBULAR END, CORNER, PULL, OR DIAGONAL BRACES MUST CONFORM TO THE DIMENSIONS AND WEIGHTS SPECIFIED ON STANDARD DRAWING WF-3 (CHAIN LINK). APPROVED ALTERNATES ARE ACCEPTABLE. AN ACCEPTABLE TOLERANCE IN LENGTH OF TUBULAR OR WOODEN POSTS SHALL BE -1" TO +2". TUBULAR POSTS MUST BE PAINTED OR GALVANIZED.

THE CONTRACTOR SHALL FURNISH AT LEAST 25% OF TIMBER LINE POSTS OF 7 FOOT LENGTHS IN ORDER TO PROVIDE SUFFICIENT SET IN SOFT GROUND OR SMALL DEPRESSIONS.

DRIVEWAY GATES, EITHER SINGLE 12' TO 16' OR DOUBLE 6' TO 8' OPENING OF THE SAME TYPE AS THE PEDESTRIAN GATE, SHALL BE INSTALLED ON THE RIGHT SIDE OF EACH THROUGH LANE ROAD AT LARGE CULVERTS OR BRIDGE CROSS FENCE, FOR USE OF MAINTENANCE EQUIPMENT. LOCATION OF GATES TO BE SHOWN ON PLANS OR AS DESIGNATED BY THE ENGINEER.


AT STREAM CROSSINGS, THE FENCE SHALL NOT BE CONSTRUCTED ACROSS LARGE STREAMS. WHERE CLEARANCE IS SUFFICIENT FROM THE TOP OF THE BANK TO THE BRIDGE STRUCTURE A CROSS CONNECTION SHALL BE CONSTRUCTED BETWEEN THE FENCE ON EACH SIDE OF THE ROAD. WHERE THE CLEARANCE IS NOT SUFFICIENT, THE FENCE SHALL BE TERMINATED WITH CROSS CONNECTIONS AND END POSTS ADJACENT TO BRIDGE ABUTMENTS OR CULVERT WINGWALLS.

SPLICE FOR BARBED WIRE BETWEEN PULL POST ASSEMBLY SHALL BE BY THE 'EYE METHOD' AS DESCRIBED AS FOLLOWS: THE ENDS OF THE BARBED WIRE SHALL BE BENT TO FORM A LOOP, THE LOOPS SHALL BE CONNECTED. AFTER THE LOOPS ARE CONNECTED THE ENDS OF THE WIRE SHALL BE WRAPPED AROUND THE PROJECTING WIRES A MINIMUM OF 4 TIMES FOR EACH WIRE LOOP.


SPLICE FOR WOVEN WIRE BETWEEN PULL POST SHALL BE BY THE 'WESTERN UNION METHOD' AS DESCRIBED AS FOLLOWS: THE VERTICAL WIRES FOR EACH END OF THE FENCE FABRIC SHALL BE PLACED SIDE BY SIDE AND THE PROJECTING HORIZONTAL WIRES SHALL BE WRAPPED A MINIMUM OF 4 TIMES AROUND THE HORIZONTAL WIRES OF THE FIRST WEB.

STAPLE AT LEAST TOP, BOTTOM AND ALTERNATE WIRES OF WOVEN FABRIC FOR WOOD LINE POSTS.


NOTE: USE 3/4" X 1 1/2" LAG BOLT & SHIELD OR AS APPROVED BY THE ENGINEER.

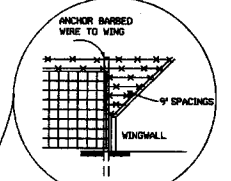



DETAIL OF FENCE CONSTRUCTION AT LARGE CULVERTS (5' IN HEIGHT AND OVER)

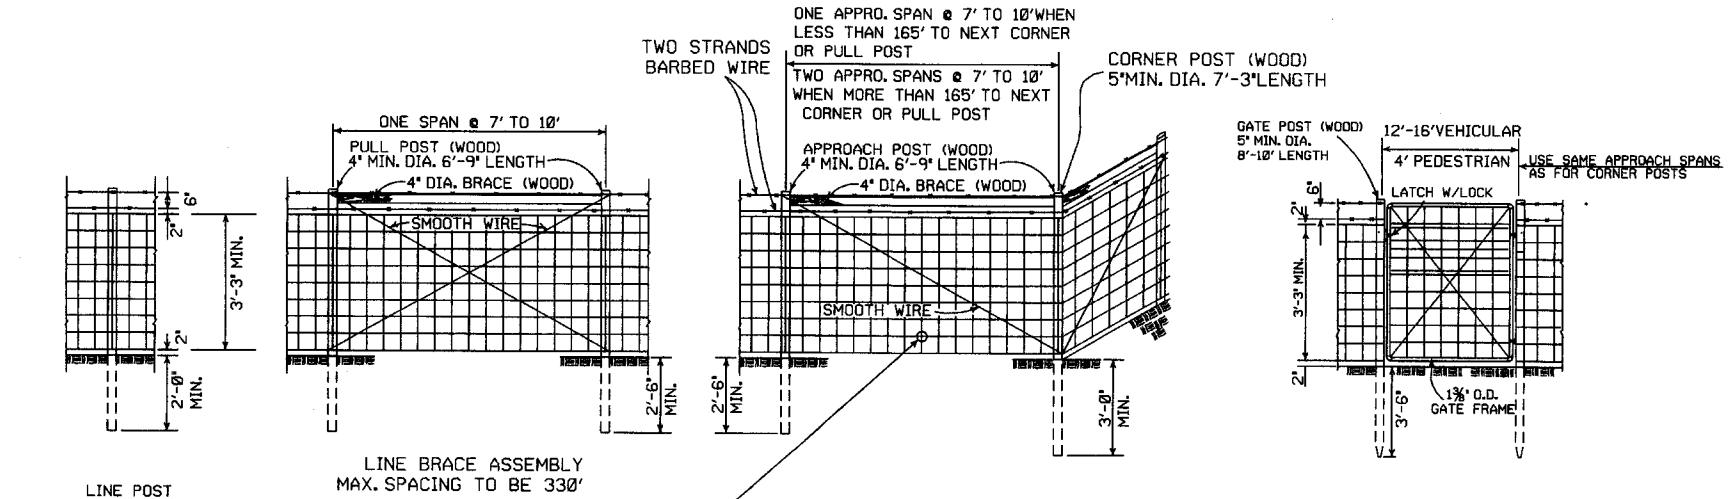

TYPE C FENCE (WOOD POSTS)

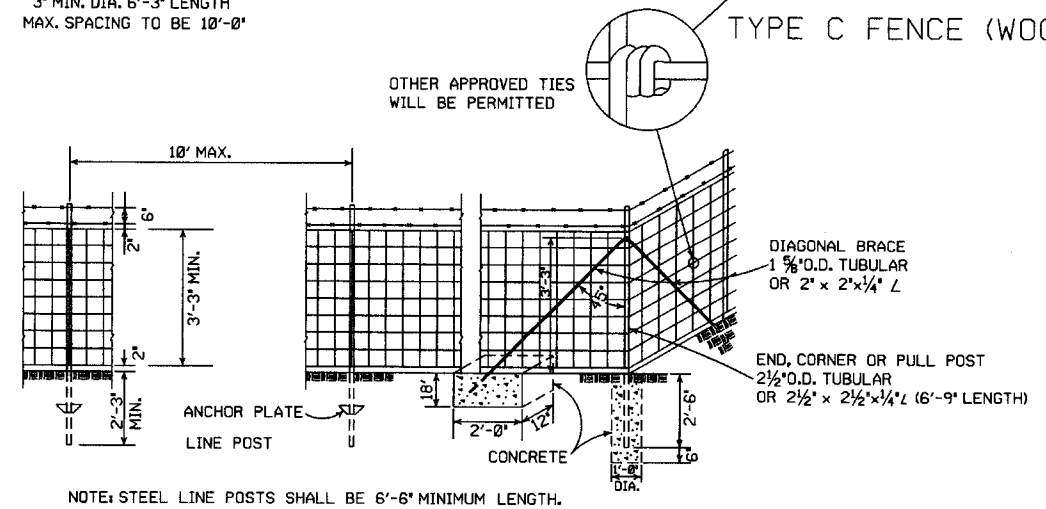


TYPE C FENCE (STEEL POSTS)

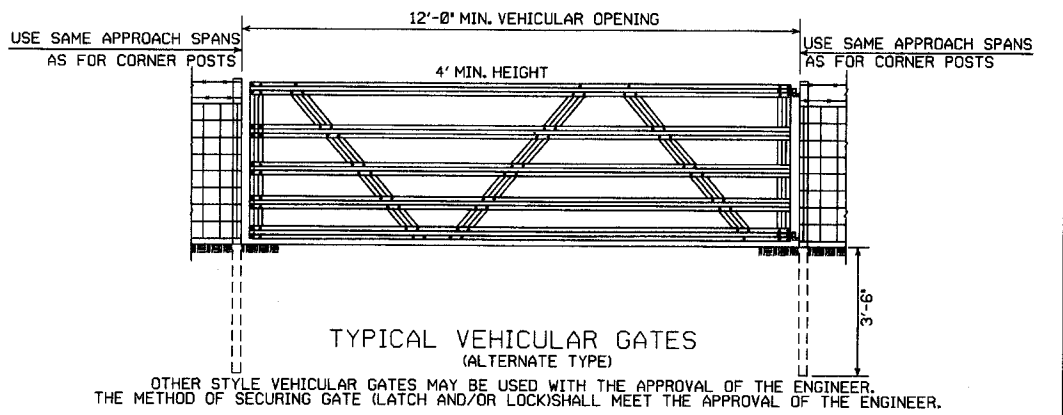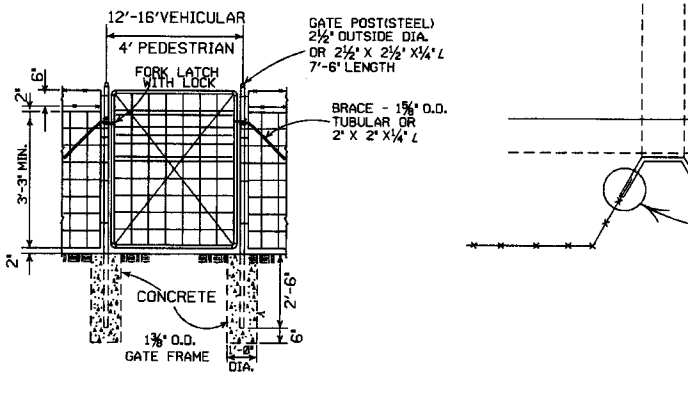

TYPICAL VEHICULAR GATES (ALTERNATE TYPE)

OTHER STYLE VEHICULAR GATES MAY BE USED WITH THE APPROVAL OF THE ENGINEER. THE METHOD OF SECURING GATE (LATCH AND/OR LOCK) SHALL MEET THE APPROVAL OF THE ENGINEER.


- 4 STRANDS BARBED WIRE (D)
- 5 STRANDS BARBED WIRE (D-1)
- 6 STRANDS BARBED WIRE (D-2)

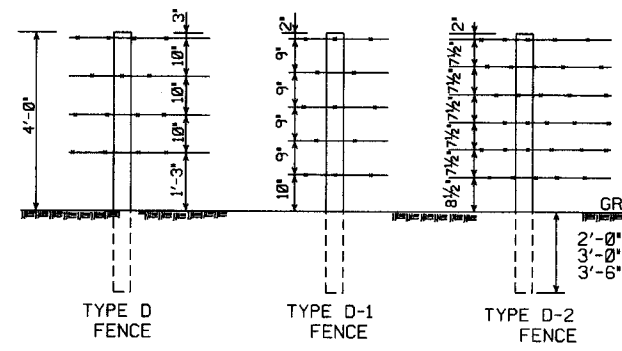

NOTE: SPACING AND SIZE (EXCEPT LENGTH) OF POSTS, APPROACH SPANS, PULL POST ASSEMBLIES, AND CORNER BRACING FOR TYPE D FENCE SHALL CONFORM TO TYPE C FENCE. USE GALVANIZED STAPLES ON WOOD POSTS AND APPROVED FASTENERS ON STEEL POSTS.

NOTE: RIGHT-OF-WAY MONUMENTS SHALL NOT BE DISTURBED BY FENCE CONSTRUCTION. CORNER POSTS SHALL BE CONSTRUCTED 2' FROM THE RIGHT-OF-WAY MONUMENT OR AS DIRECTED BY THE ENGINEER.

RIGHT-OF-WAY FENCE LOCATION

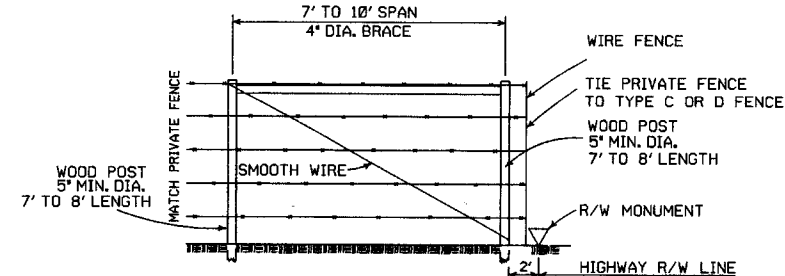

PRIVATE FENCE TERMINAL INSTALLATION

WHERE EXISTING FENCE CONSISTS OF STEEL POSTS, USE END POST ASSEMBLY AS SHOWN IN TYPE C FENCE OR OTHER END POST ASSEMBLY AS APPROVED BY THE ENGINEER.

DATE	REVISION	FILED
8-22-82	REVISED GENERAL NOTES	
10-18-96	REVISED AASHTO	
11-22-95	REVISED R-O-W LOCATION DETAIL	
6-2-94	REVISED BARB WIRE AND ADDED CORNER POST NOTES	6-2-94
8-5-93	REVISED R/W INSTALLATION FENCE	8-5-93
10-1-92	ADDED STAPLE NOTE	10-1-92
8-15-91	ADDED TYPE D-2 FENCE	8-15-91
11-30-89	DELETED CLASS CONCRETE	11-30-89
7-15-88	ADDED SPLICE NOTE	700-7-15-88
10-30-87	GENERAL REVISIONS	549-10-30-87
11-1-84	MAX. POST SPACING MIN. WIRE GAUGE	507-11-1-84
1-4-83	MIN. DIA. LINE POST	648-1-4-83
3-2-81	TOLERANCE FOR POST LENGTH	722-3-2-81
12-1-72	ADDED D-1 & FENCE INSTALLATION	564-12-1-72
10-2-72	REVISED AND REDRAWN	540-10-2-72




ARKANSAS STATE HIGHWAY COMMISSION

WIRE FENCE
TYPE C AND D

STANDARD DRAWING WF-4

DATE REVISED	DATE FILMED	DATE REVISED	DATE FILMED	FED. RD. DIST. NO.	STATE	FED. AID PROJ. NO.	SHEET NO.	TOTAL SHEETS
				6	ARK.			
JOB NO. 090346							50	56

② CROSS SECTIONS

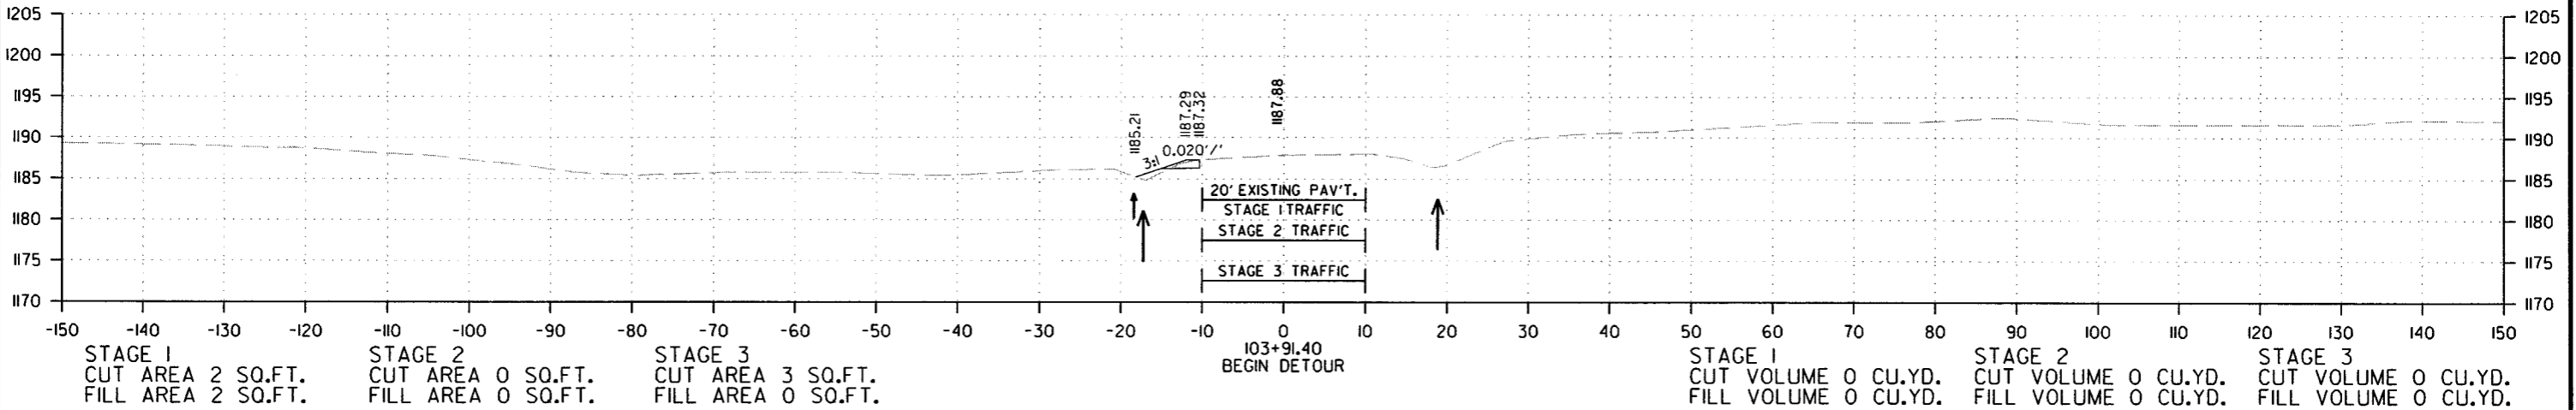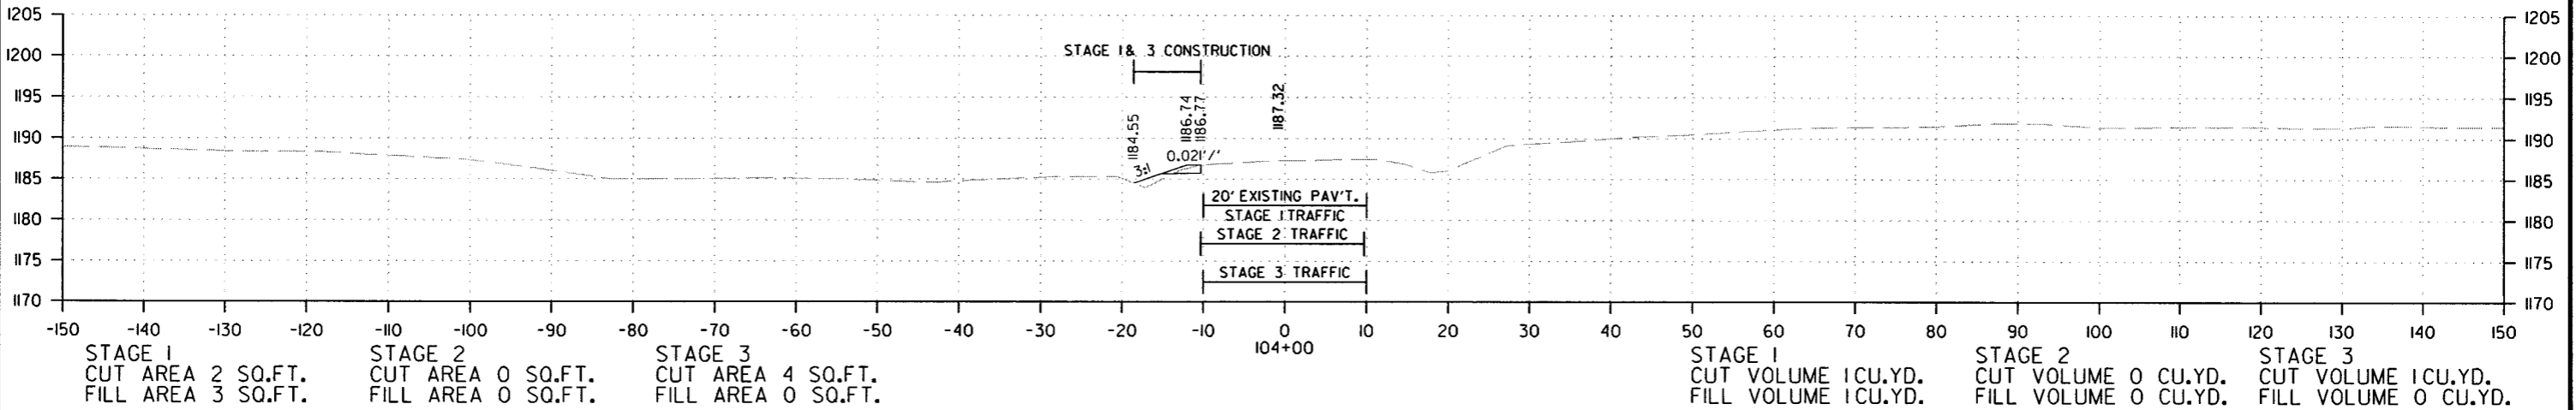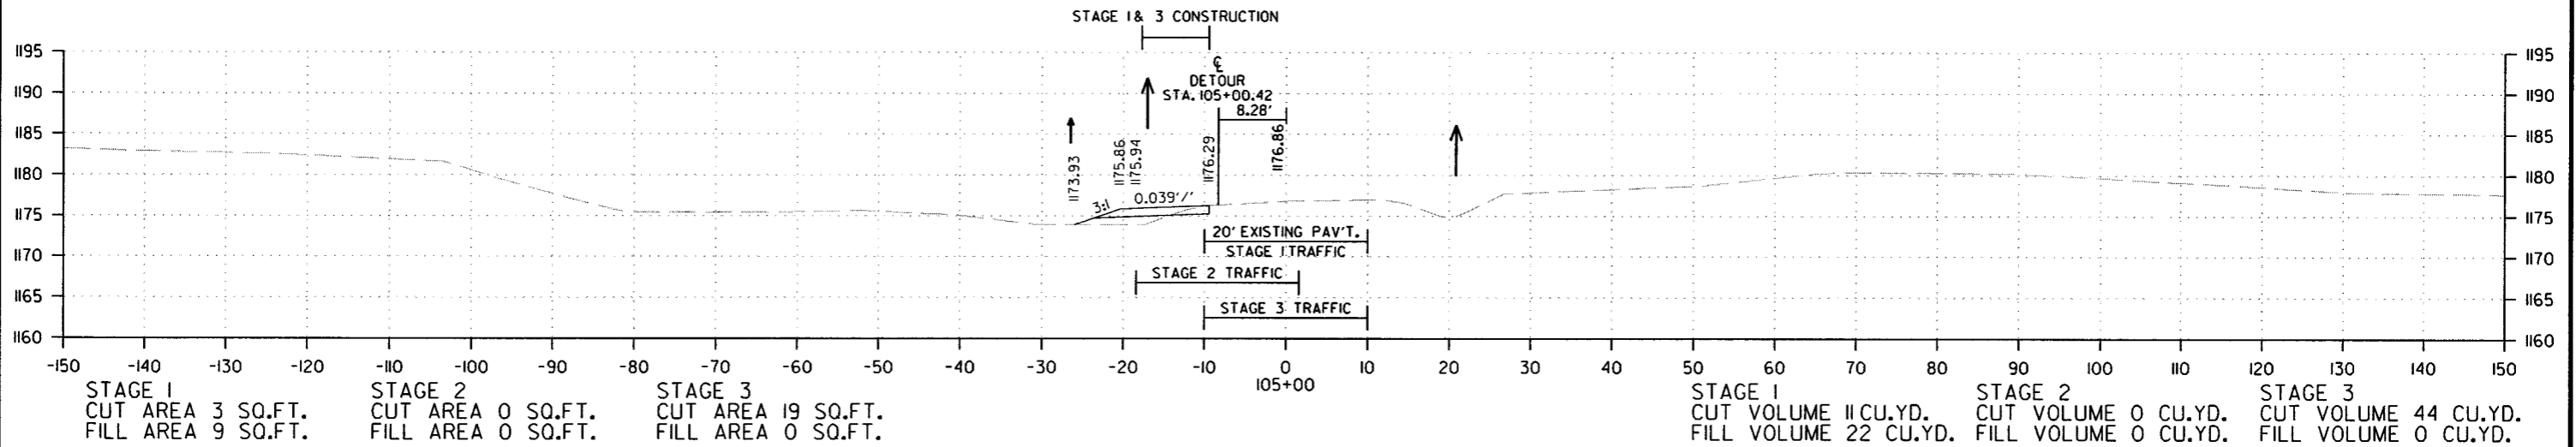


CROSS SECTION STA. 103+91.40 TO STA. 105+00

7/21/2016


R090346.DGN

DATE REVISED	DATE FILMED	DATE REVISED	DATE FILMED	FED. DIST. NO.	STATE	FED. AID PROJ. NO.	SHEET NO.	TOTAL SHEETS
				6	ARK.			
						JOB NO. 090346	51	56


2 CROSS SECTIONS

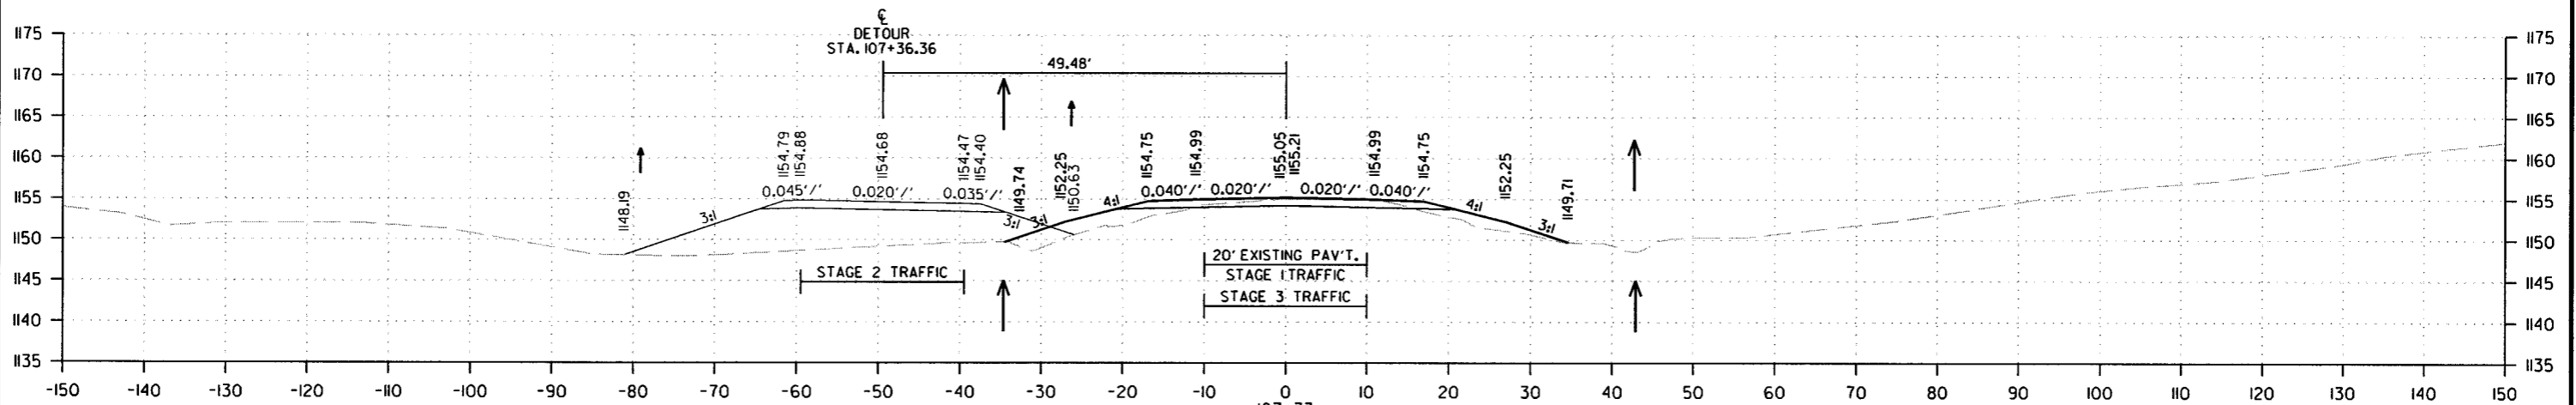

STAGE 1 CUT AREA 0 SQ.FT. FILL AREA 203 SQ.FT.	STAGE 2 CUT AREA 19 SQ.FT. FILL AREA 38 SQ.FT.	STAGE 3 CUT AREA 218 SQ.FT. FILL AREA 0 SQ.FT.		STAGE 1 CUT VOLUME 0 CU.YD. FILL VOLUME 182 CU.YD.	STAGE 2 CUT VOLUME 12 CU.YD. FILL VOLUME 23 CU.YD.	STAGE 3 CUT VOLUME 218 CU.YD. FILL VOLUME 0 CU.YD.
--	--	--	--	--	--	--

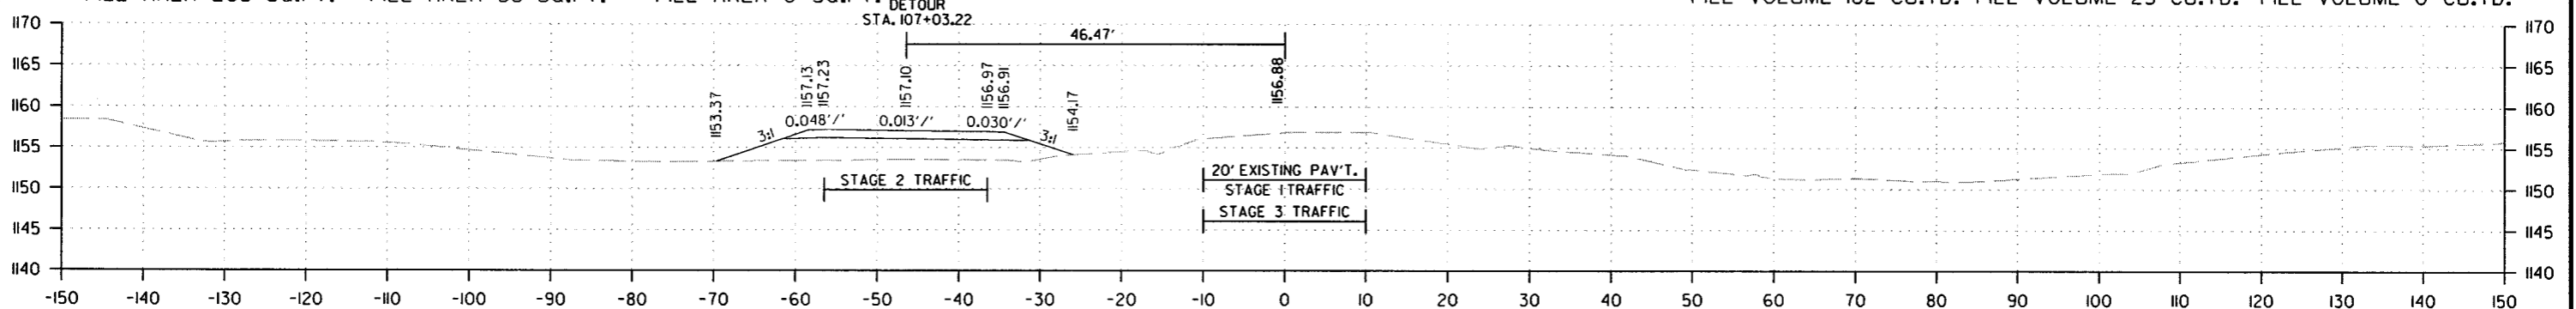

STAGE 1 CUT AREA 0 SQ.FT. FILL AREA 95 SQ.FT.	STAGE 2 CUT AREA 0 SQ.FT. FILL AREA 0 SQ.FT.	STAGE 3 CUT AREA 122 SQ.FT. FILL AREA 0 SQ.FT.		STAGE 1 CUT VOLUME 15 CU.YD. FILL VOLUME 226 CU.YD.	STAGE 2 CUT VOLUME 0 CU.YD. FILL VOLUME 0 CU.YD.	STAGE 3 CUT VOLUME 326 CU.YD. FILL VOLUME 11 CU.YD.
---	--	--	--	---	--	---

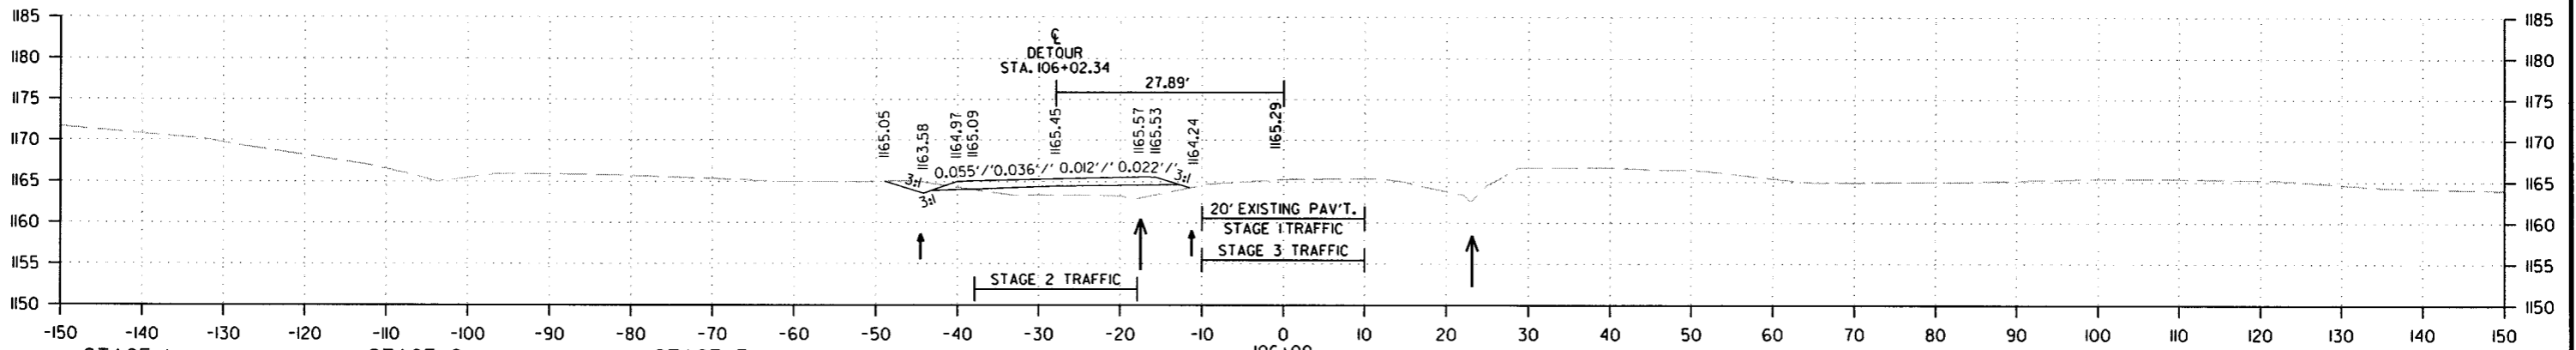

STAGE 1 CUT AREA 7 SQ.FT. FILL AREA 27 SQ.FT.	STAGE 2 CUT AREA 0 SQ.FT. FILL AREA 0 SQ.FT.	STAGE 3 CUT AREA 53 SQ.FT. FILL AREA 5 SQ.FT.		STAGE 1 CUT VOLUME 19 CU.YD. FILL VOLUME 67 CU.YD.	STAGE 2 CUT VOLUME 0 CU.YD. FILL VOLUME 0 CU.YD.	STAGE 3 CUT VOLUME 133 CU.YD. FILL VOLUME 11 CU.YD.
---	--	---	--	--	--	---




CROSS SECTION STA. 106+00 TO STA. 107+33

7/21/2016

R090346.DGN

DATE REVISED	DATE FILMED	DATE REVISED	DATE FILMED	FED. RD. DIST. NO.	STATE	FED. AID PROJ. NO.	SHEET NO.	TOTAL SHEETS
				6	ARK.			
						JOB NO. 090346	52	56

2 CROSS SECTIONS

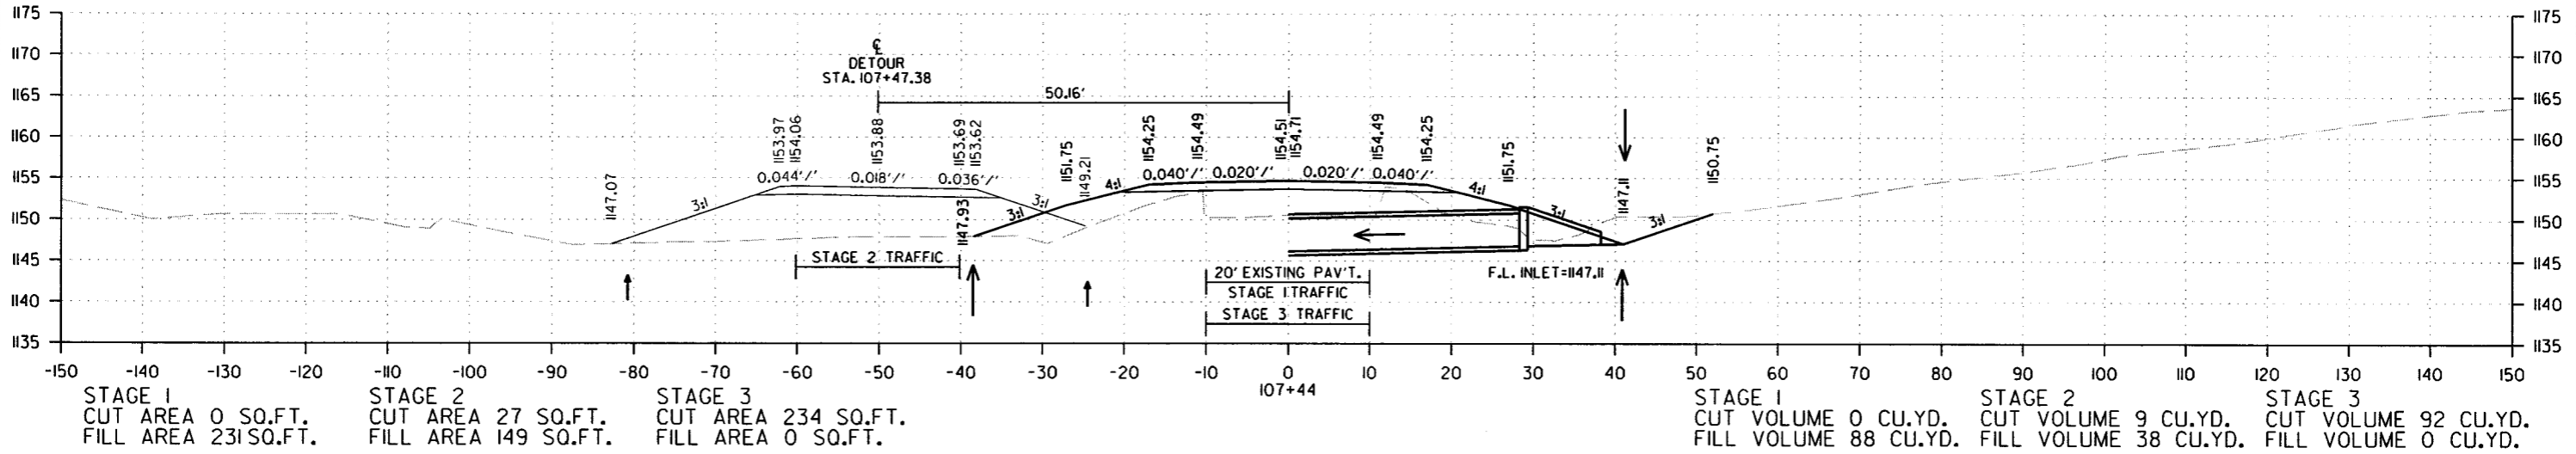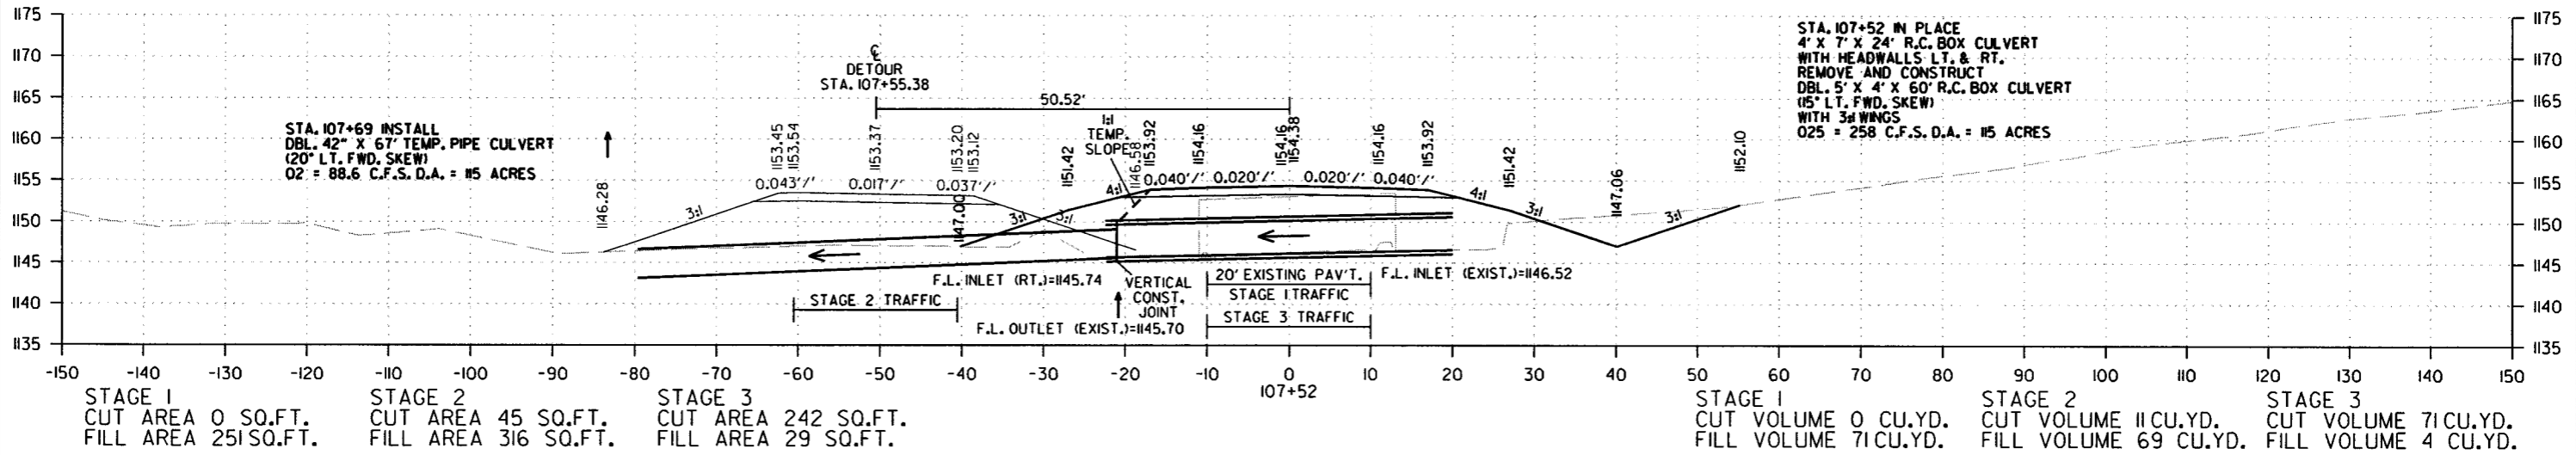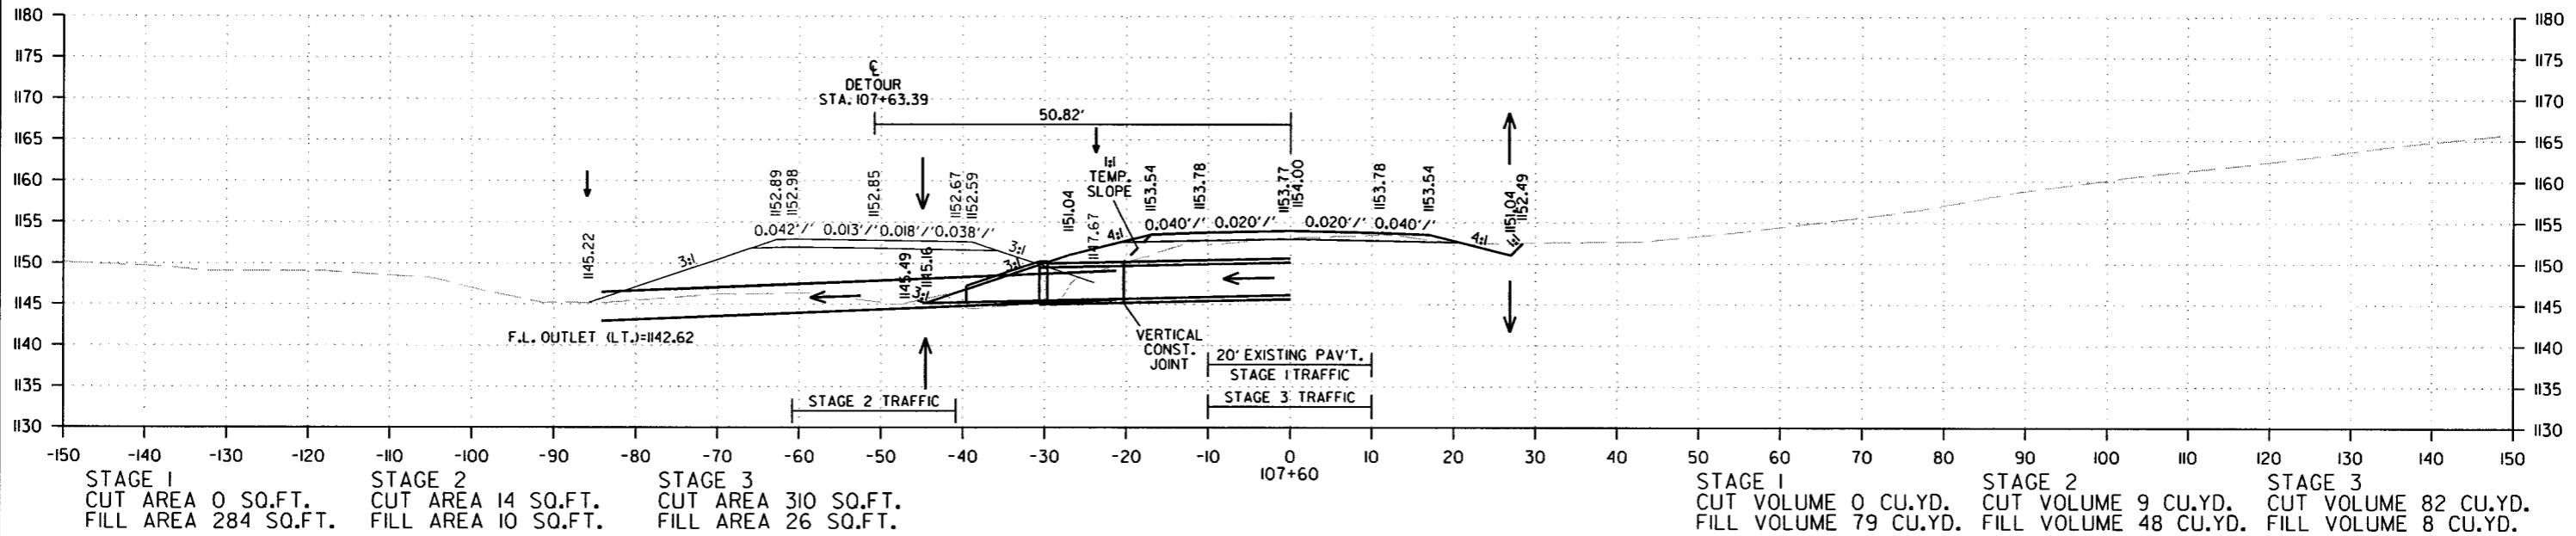


CROSS SECTION STA. 107+44 TO STA. 107+60


7/21/2016 R090346.DGN

DATE REVISED	DATE FILMED	DATE REVISED	DATE FILMED	FED. RD. DIST. NO.	STATE	FED. AID PROJ. NO.	SHEET NO.	TOTAL SHEETS
				6	ARK.			
						JOB NO. 090346	53	56

2 CROSS SECTIONS

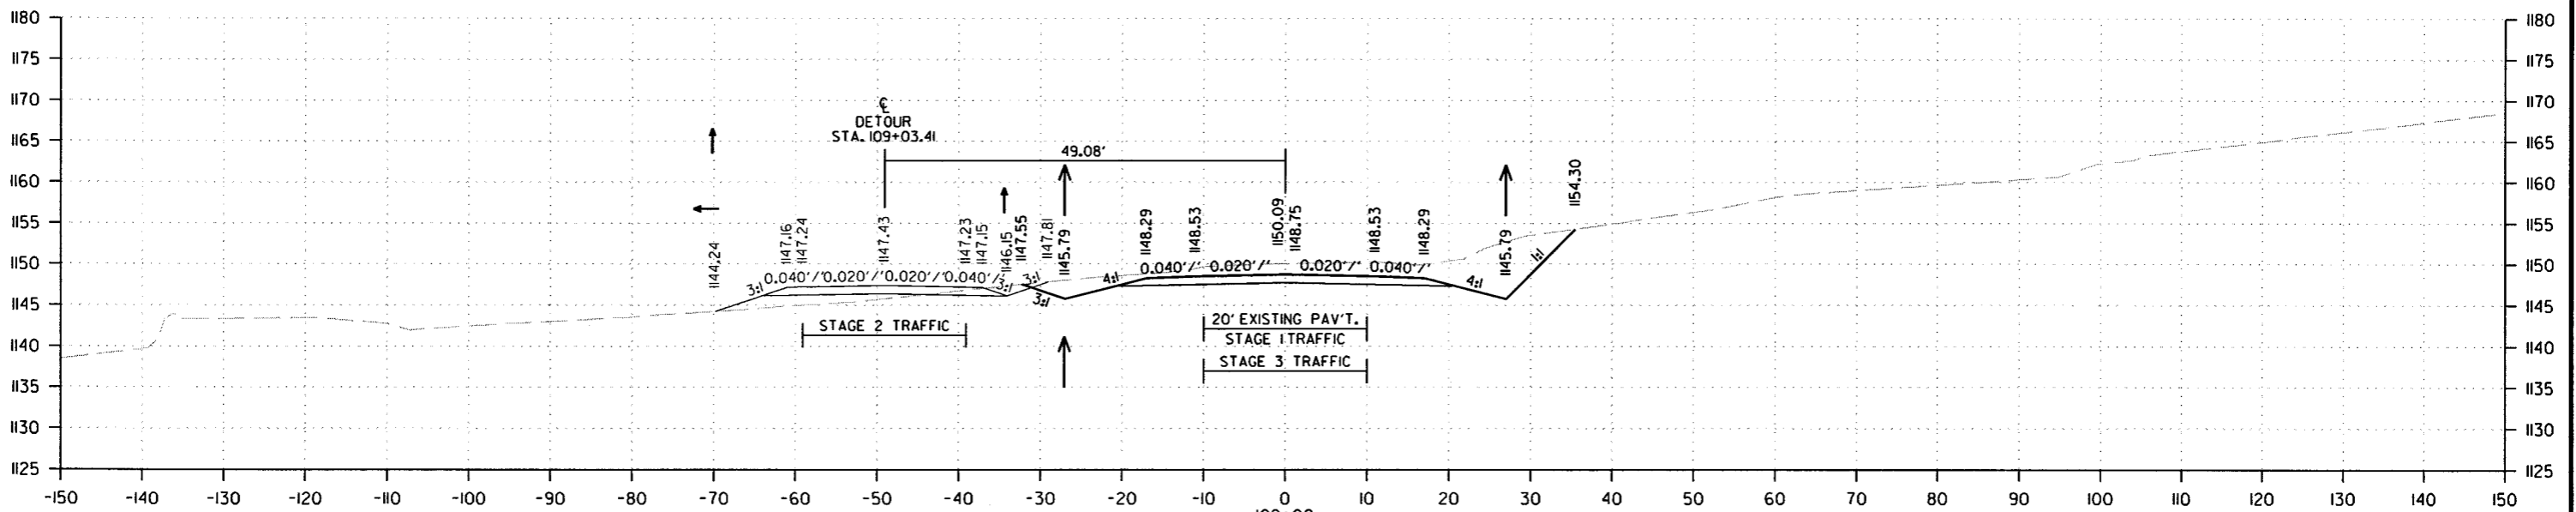

STAGE 1 CUT AREA 9 SQ.FT. FILL AREA 23 SQ.FT.	STAGE 2 CUT AREA 172 SQ.FT. FILL AREA 0 SQ.FT.	STAGE 3 CUT AREA 45 SQ.FT. FILL AREA 5 SQ.FT.	109+00	STAGE 1 CUT VOLUME 148 CU.YD. FILL VOLUME 85 CU.YD.	STAGE 2 CUT VOLUME 581 CU.YD. FILL VOLUME 0 CU.YD.	STAGE 3 CUT VOLUME 130 CU.YD. FILL VOLUME 85 CU.YD.
---	--	---	--------	---	--	---

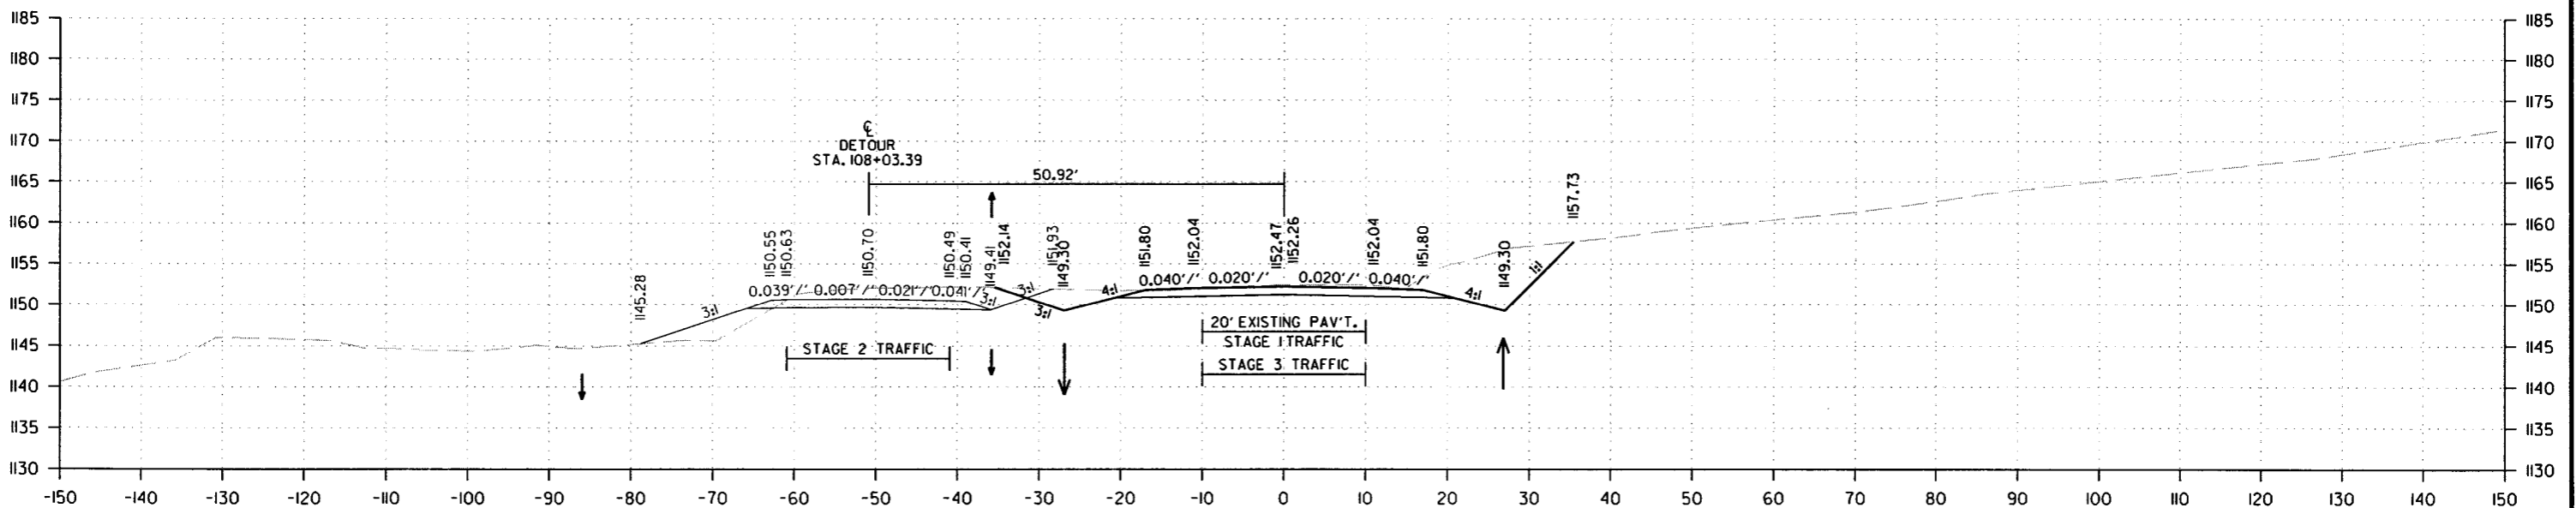

STAGE 1 CUT AREA 70 SQ.FT. FILL AREA 23 SQ.FT.	STAGE 2 CUT AREA 141 SQ.FT. FILL AREA 0 SQ.FT.	STAGE 3 CUT AREA 25 SQ.FT. FILL AREA 41 SQ.FT.	108+00	STAGE 1 CUT VOLUME 52 CU.YD. FILL VOLUME 228 CU.YD.	STAGE 2 CUT VOLUME 116 CU.YD. FILL VOLUME 7 CU.YD.	STAGE 3 CUT VOLUME 249 CU.YD. FILL VOLUME 50 CU.YD.
--	--	--	--------	---	--	---




CROSS SECTION STA. 108+00 TO STA. 109+00

7/21/2016

R090346.DGN

DATE REVISED	DATE FILMED	DATE REVISED	DATE FILMED	FED. RD. DIST. NO.	STATE	FED. AID PROJ. NO.	SHEET NO.	TOTAL SHEETS
				6	ARK.			
						JOB NO. 090346	54	56

2 CROSS SECTIONS

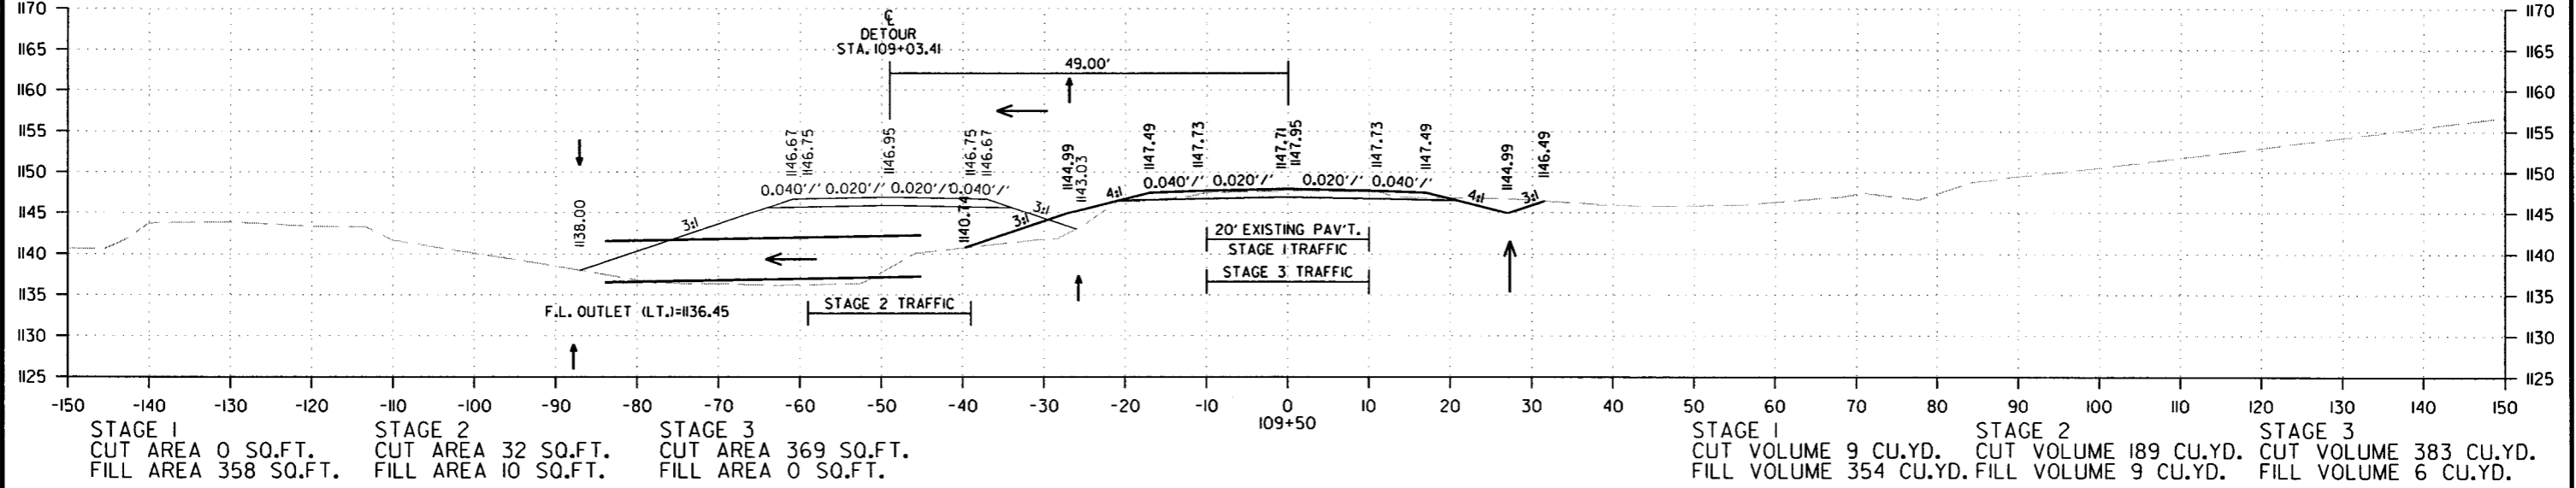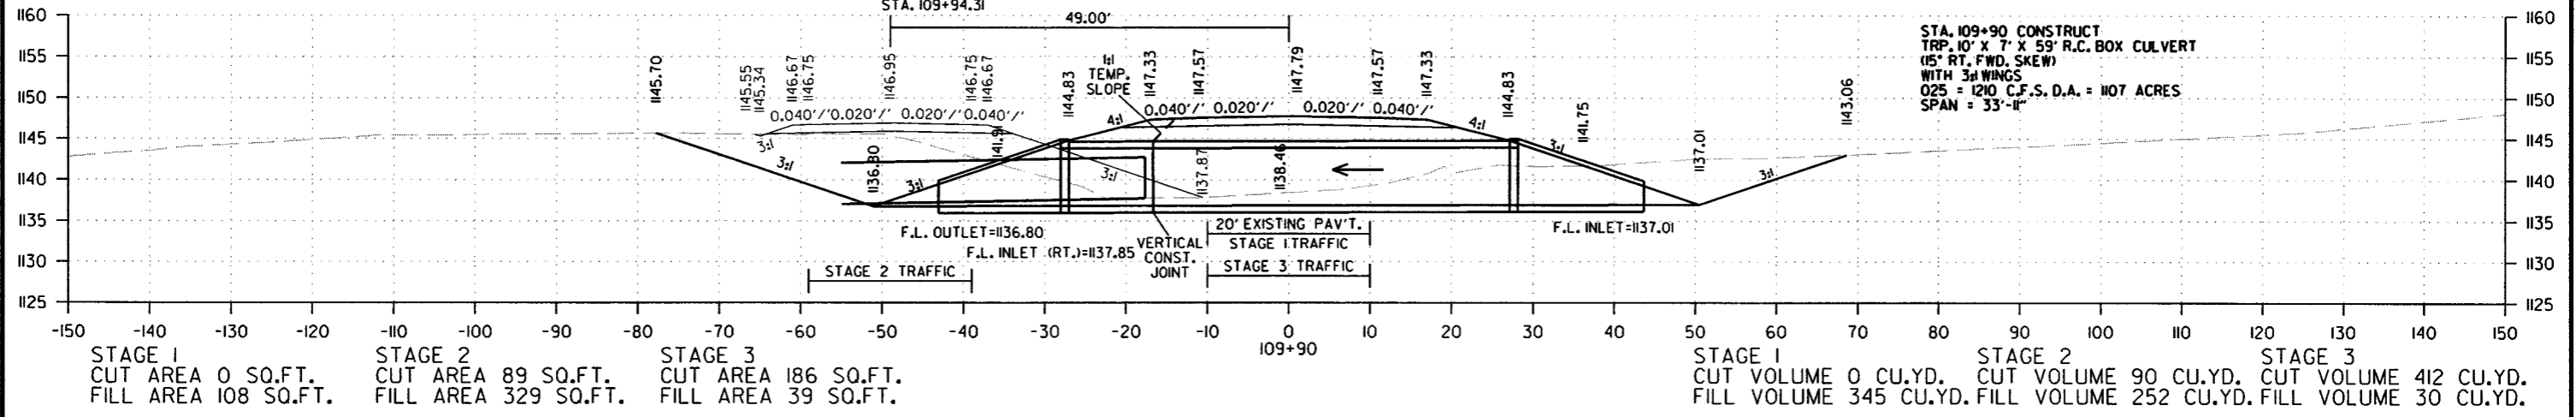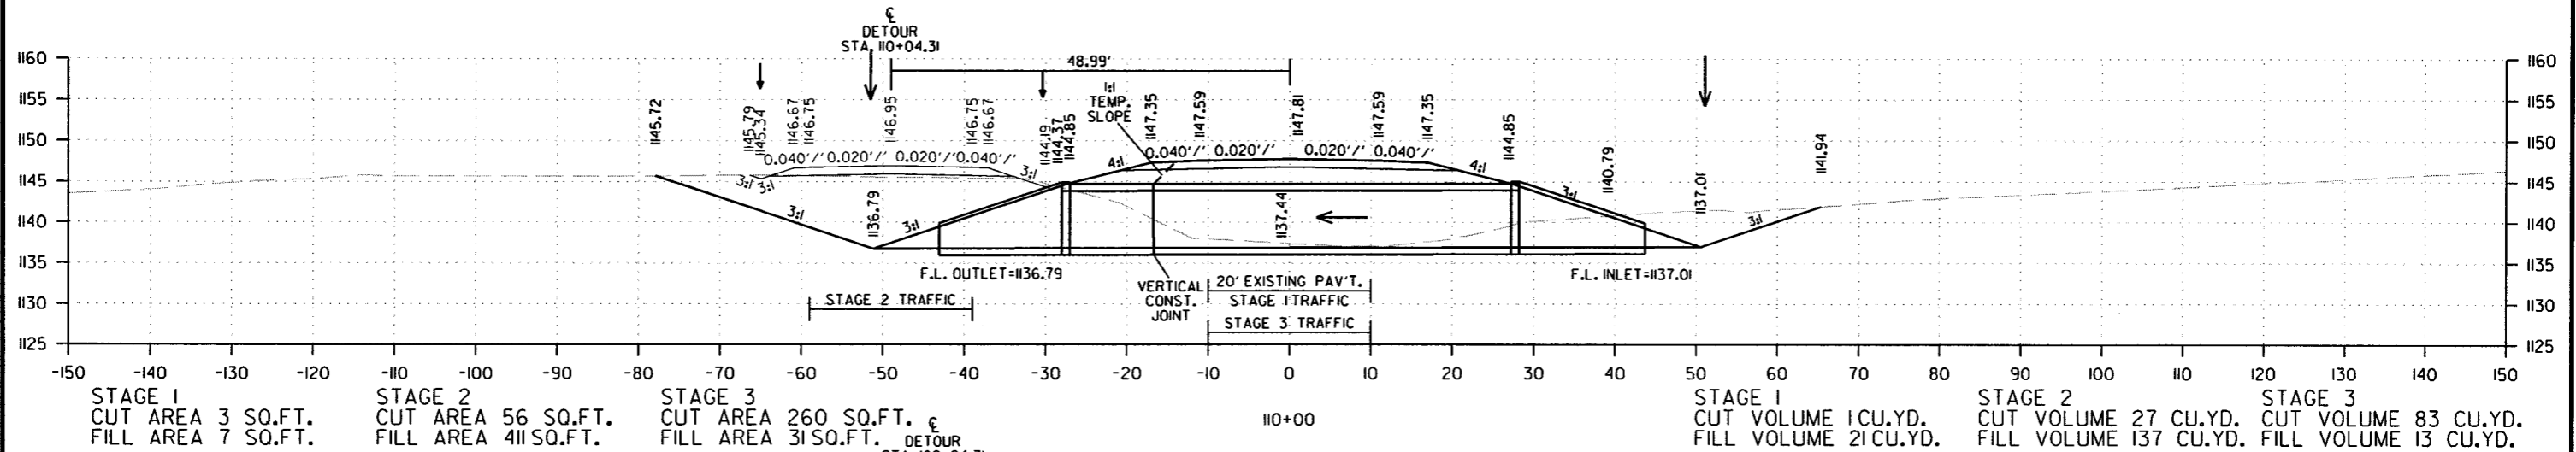


CROSS SECTION STA. 109+50 TO STA. 110+00

7/21/2016
R090346.DGN

DATE REVISED	DATE FILMED	DATE REVISED	DATE FILMED	FED. RD. DIST. NO.	STATE	FED. AID PROJ. NO.	SHEET NO.	TOTAL SHEETS
				6	ARK.			
JOB NO. 090346							55	56

2 CROSS SECTIONS

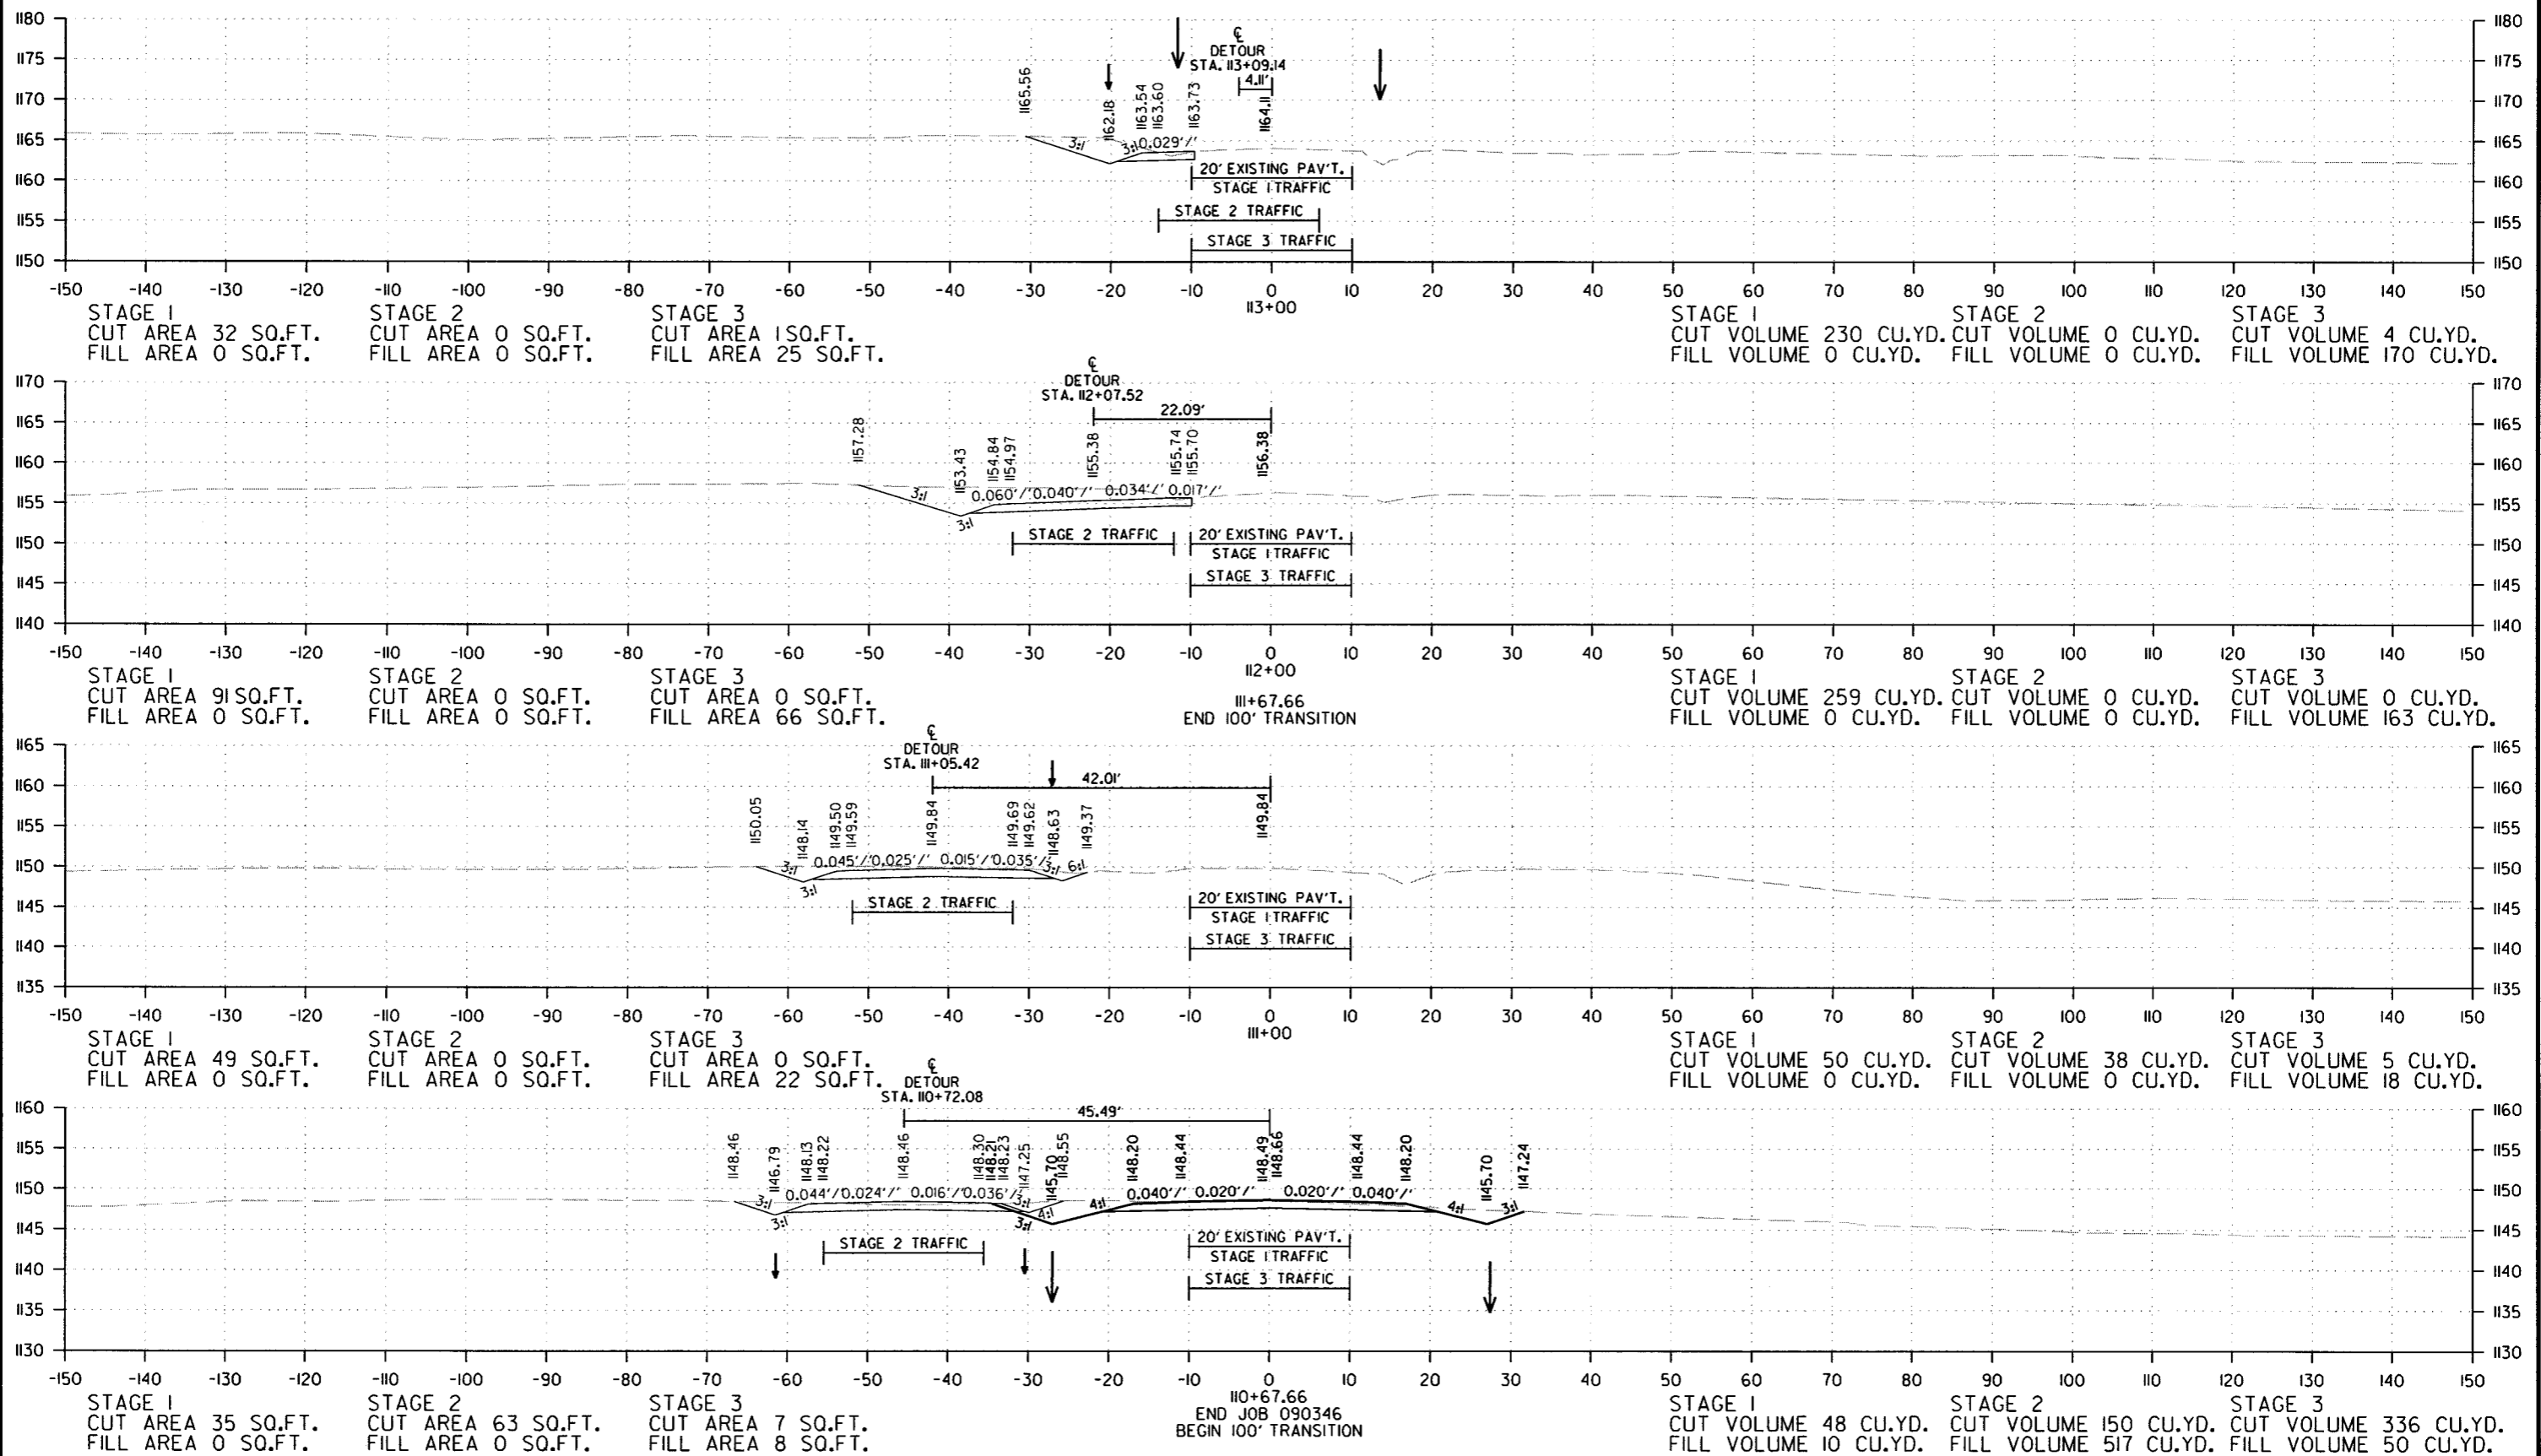


CROSS SECTION STA. 110+67.66 TO STA. 113+00

7/21/2016 R090346.DGN

DATE REVISED	DATE FILMED	DATE REVISED	DATE FILMED	FED. RD. DIST. NO.	STATE	FED. AID PROJ. NO.	SHEET NO.	TOTAL SHEETS
				6	ARK.			
						JOB NO. 090346	56	56

2 CROSS SECTIONS

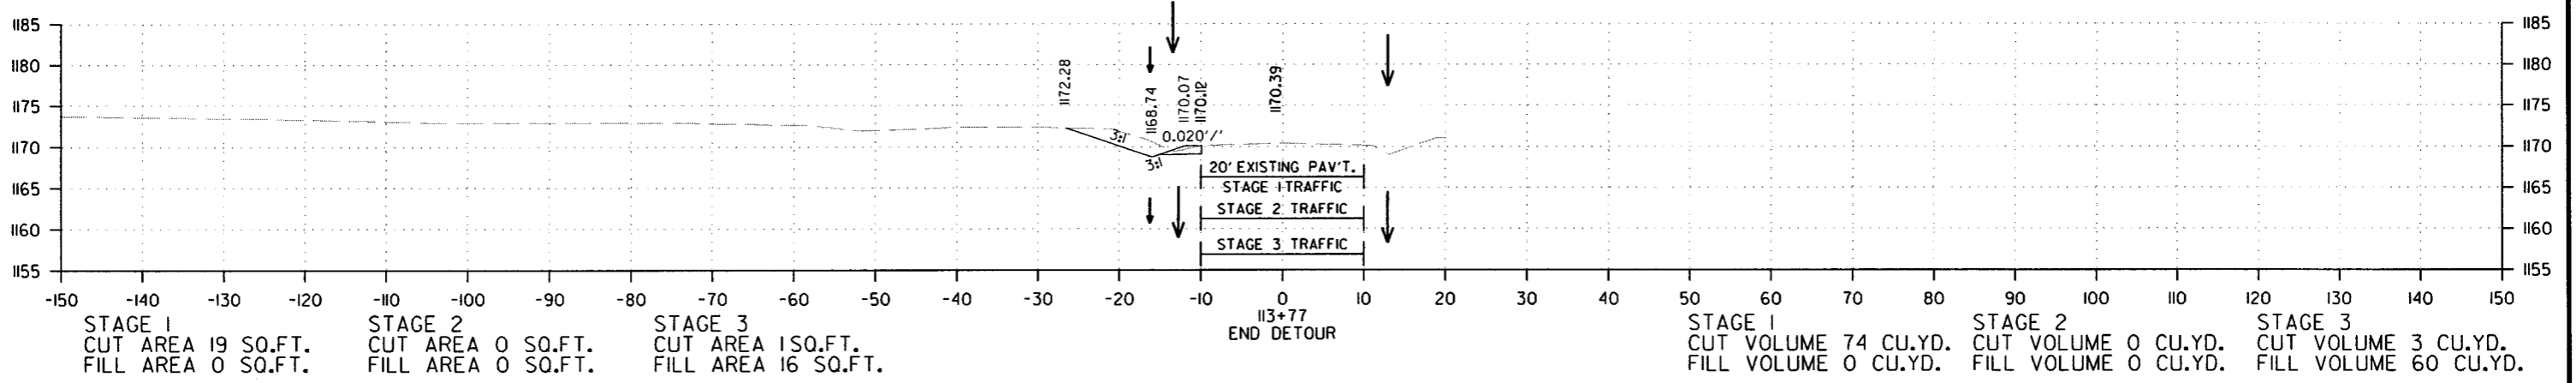

CROSS SECTION STA. 113+77 TO STA. 113+77

7/21/2016

R090346.DGN